


FINE ARTS BUILDING

ST. CLOUD STATE COLLEGE


SHEET INDEX

ARCHITECTURAL	STRUCTURAL	MECHANICAL	ELECTRICAL
A-1 SITE PLAN & SITE PLAN	S-1 FOUNDATION PLAN	M-1 PLOT PLAN	E-1 PLOT PLAN & SCHEDULE OF SYMBOLS
A-2 SUMMARY	S-2 FIRST FLOOR FRAMING	M-2 UNDERGROUND PLUMBING & HEATING	E-2 BASEMENT LIGHT, POWER, COMMUNICATIONS & DETAILS
A-3 ROOF & PLOT PLAN	S-3 LOW ROOF FRAMING PLAN	M-3 LOWER LEVEL PLUMBING & HEATING	E-3 GROUND FLOOR LIGHT & POWER
A-4 LOWER LEVEL PLAN	S-4 HIGH ROOF GRID IRON	M-4 LOWER LEVEL VENTILATION	E-4 FIRST FLOOR LIGHT & POWER
A-5 FIRST FLOOR PLAN	S-5 HIGH ROOF CROSS BRACING	M-5 FIRST FLOOR PLUMBING & HEATING	E-5 GROUND FLOOR COMMUNICATIONS
A-6 BUILDING ELEVATIONS	S-6 CONCRETE SECTIONS	M-6 FIRST FLOOR VENTILATION	E-6 FIRST FLOOR COMMUNICATIONS
A-7 BUILDING ELEVATIONS	S-7 STAIRS A B C D E F	M-7 MECHANICAL ROOM PLANS & DETAILS	E-7 1/4" SCALE PLAN OF MAIN THEATER & STAGE, LIGHTING & POWER
A-8 ROOM SCHEDULE & DOOR SCHEDULE	S-8 SECTIONS	M-8 MECHANICAL ROOM PLANS & DETAILS	E-8 1/4" SCALE PLAN OF T.V. STUDIO, REHEARSAL HALL & LECTURE HALL
A-9 BUILDING SECTIONS	S-9 SECTIONS	M-9 MECHANICAL DETAILS	E-9 DETAILS
A-10 EXTERIOR BUILDING DETAILS	S-10 TRUSSES 1, 2, 3, 4	M-10 PIPING SYSTEM DIAGRAMS	E-10 RISER DIAGRAMS
A-11 EXTERIOR BUILDING DETAILS	S-11 FOUNDATION SECTIONS	M-11 SCHEDULES	
A-12 CATWALK PLAN & STAIR DETAILS	S-12 CONCRETE BEAMS SCHEDULE	M-12 MECHANICAL DETAILS	
A-13 REFLECTIVE CEILING PLAN	S-13 CONCRETE SLAB & JOIST SCHEDULE		
A-14 THEATER DETAILS	S-14 GRID IRON SECTIONS & DETAILS		
A-15 RECITAL DETAILS	S-15 CATWALK PLAN & SECTIONS		
A-16 ROOM ELEVATIONS	S-16 COLUMN & FOOTING SCHEDULE		
A-17 ROOM ELEVATIONS	S-17 COLUMN & FOOTING SCHEDULE		
A-18 TOILET ROOM PLANS & ELEVATIONS	S-18 MAIN ENTRANCE DETAILS		
A-19 MISCELLANEOUS DETAILS	S-19 MISCELLANEOUS STRUCTURAL DETAILS		

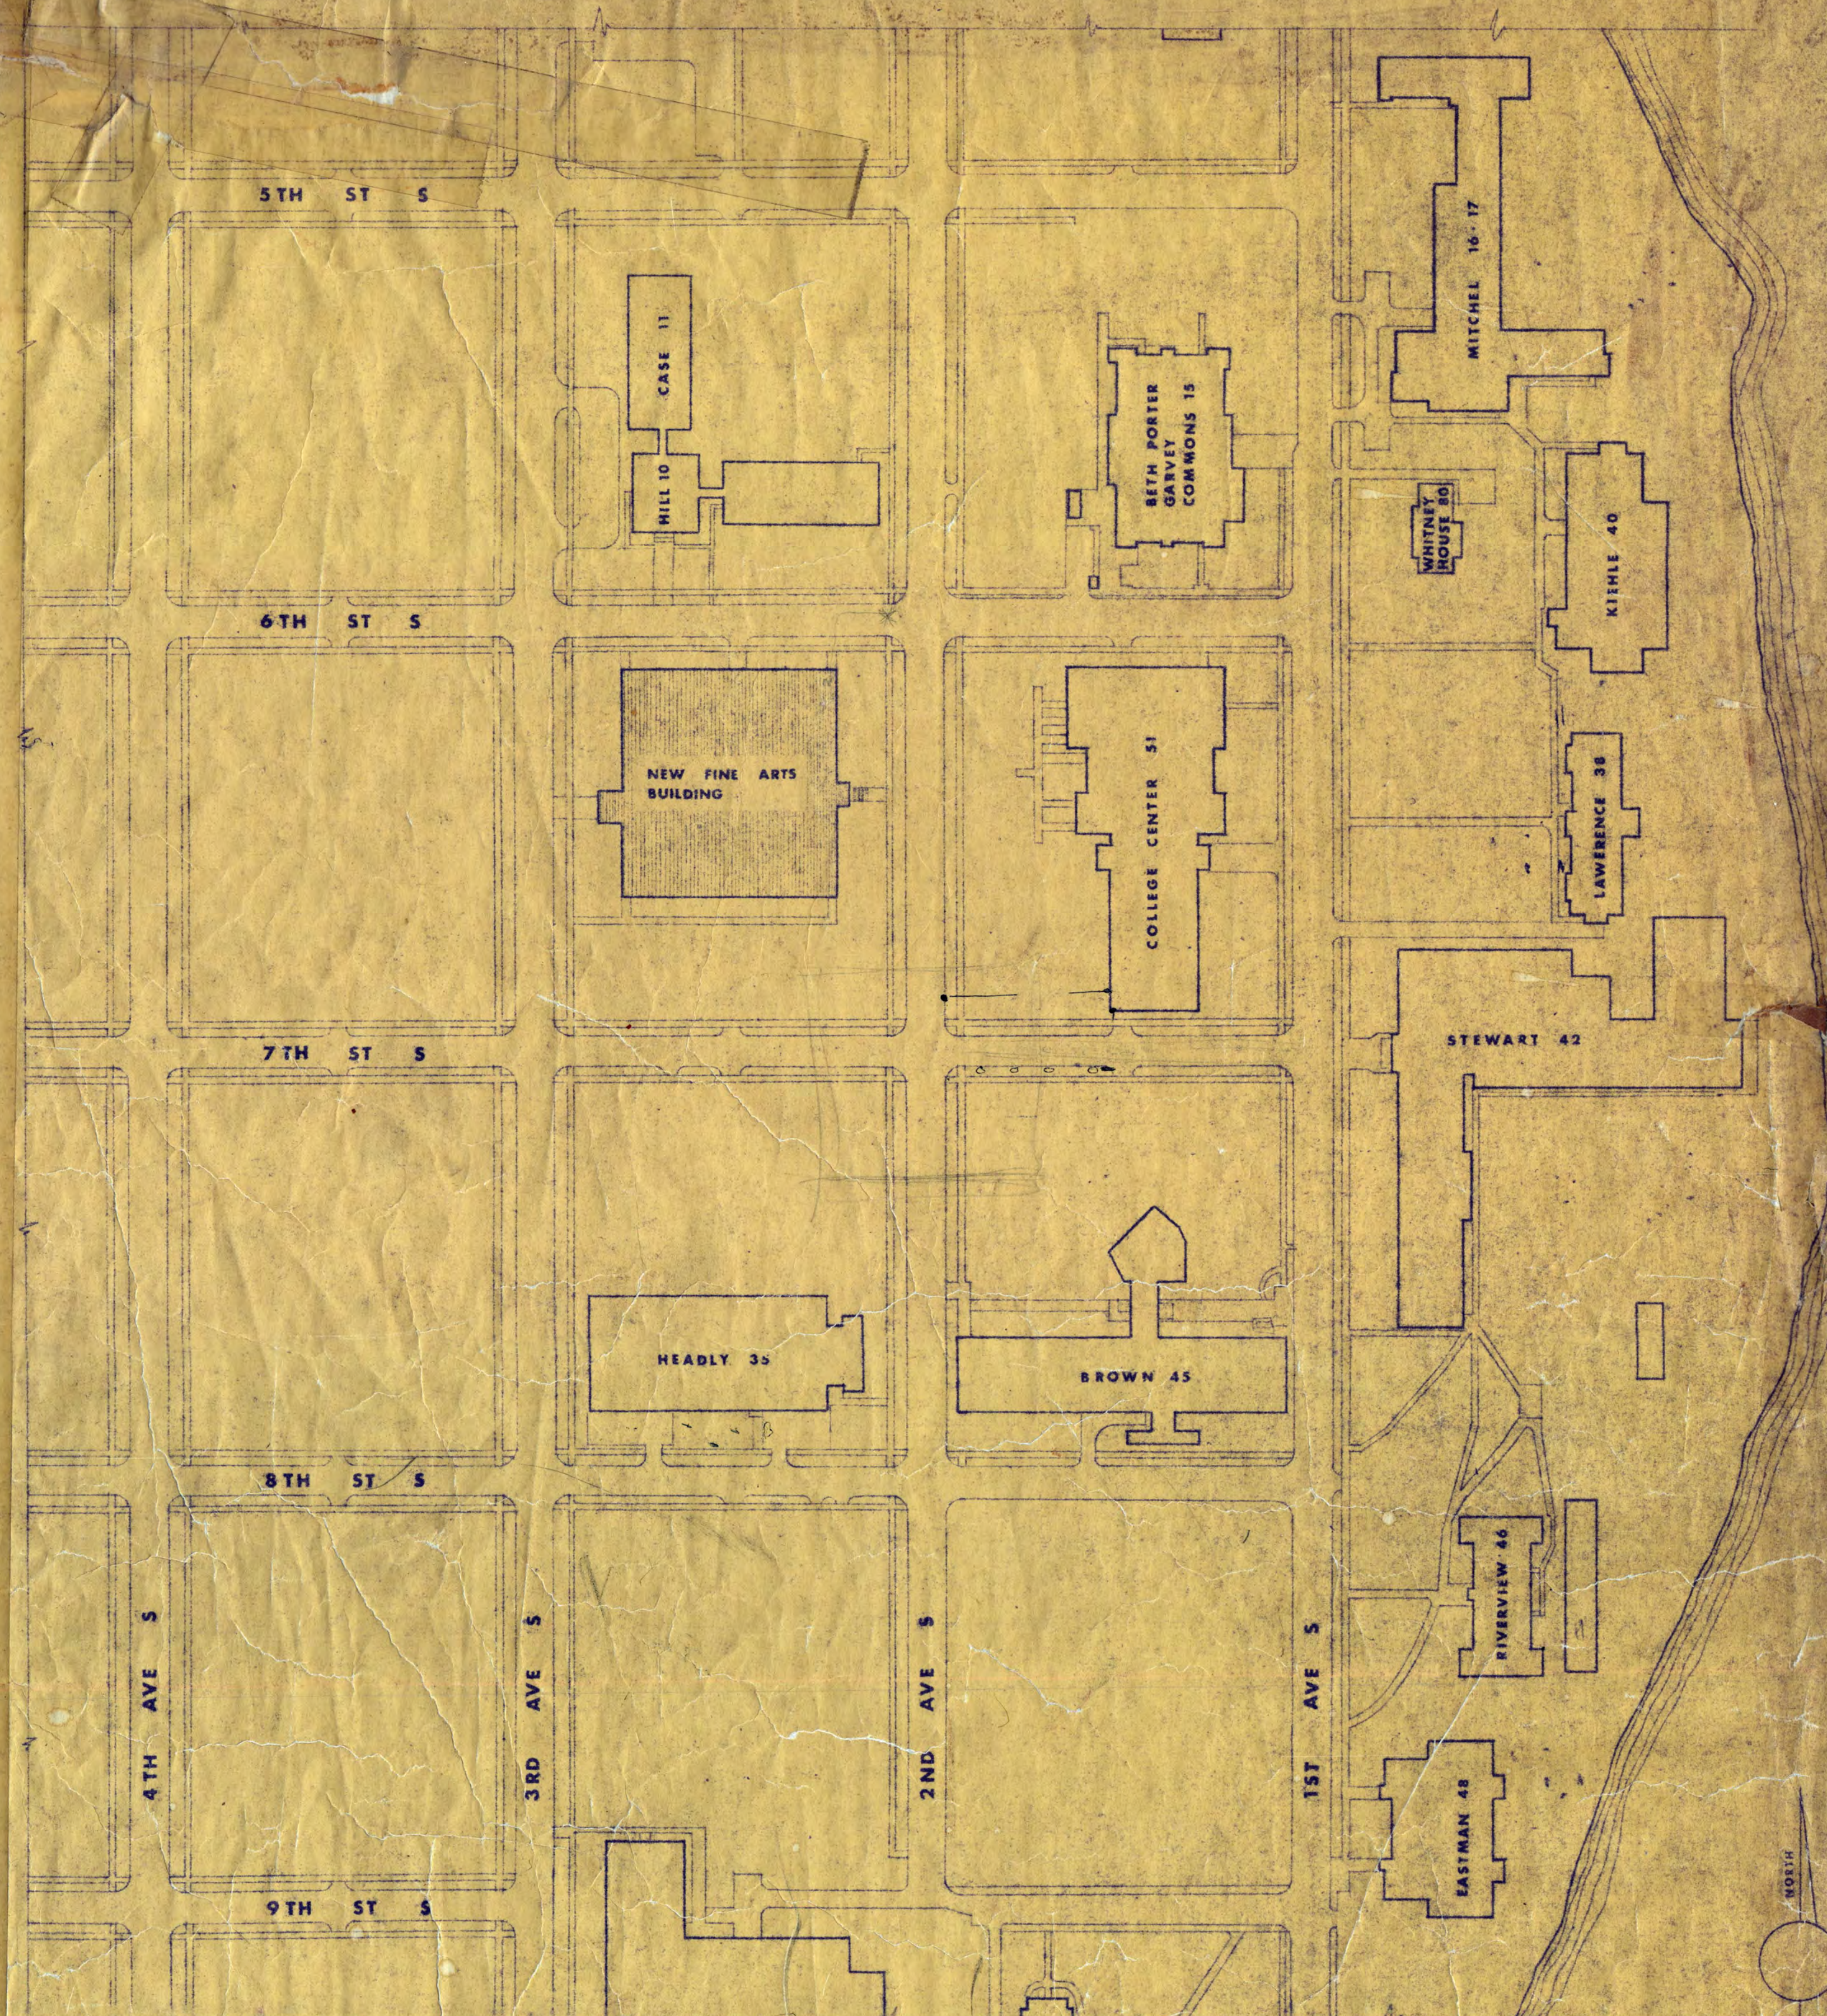

ABBREVIATIONS

ADJ. TILE	FLR	FLOOR FINISH	OPF	OPPOSITE
ALUMINUM	FRF	FIRE PROOF (F.P.)	OZ	OUNCE
ANGLE	FT	FOOT, FEET	PASS	PASSENGER PASSAGE
ARCHITECTURAL	FTG	FOOTING	PKG	PITCH AND GRAVEL
ASBESTOS	GL	GLASS	PL	PLASTER
BALANCE	GLD	GLAZED	PLB	PLUMBING
BALCONY	GLS	GLASS	PLC	PLATE GLASS
BALCONY MARK	GR	GRASS	PLD	PLAIN
BALCONY	GRU	GRASS	PLF	PLAIN
BALCONY	GRV	GRASS	PLG	PLAIN
BALCONY	GRW	GRASS	PLH	PLAIN
BALCONY	GRX	GRASS	PLI	PLAIN
BALCONY	GRY	GRASS	PLJ	PLAIN
BALCONY	GRZ	GRASS	PLK	PLAIN
BALCONY	GR1	GRASS	PLL	PLAIN
BALCONY	GR2	GRASS	PLM	PLAIN
BALCONY	GR3	GRASS	PLN	PLAIN
BALCONY	GR4	GRASS	PLO	PLAIN
BALCONY	GR5	GRASS	PLP	PLAIN
BALCONY	GR6	GRASS	PLQ	PLAIN
BALCONY	GR7	GRASS	PLR	PLAIN
BALCONY	GR8	GRASS	PLS	PLAIN
BALCONY	GR9	GRASS	PLT	PLAIN
BALCONY	GR0	GRASS	PLU	PLAIN
BALCONY	GR1	GRASS	PLV	PLAIN
BALCONY	GR2	GRASS	PLW	PLAIN
BALCONY	GR3	GRASS	PLX	PLAIN
BALCONY	GR4	GRASS	PLY	PLAIN
BALCONY	GR5	GRASS	PLY	PLAIN
BALCONY	GR6	GRASS	PLY	PLAIN
BALCONY	GR7	GRASS	PLY	PLAIN
BALCONY	GR8	GRASS	PLY	PLAIN
BALCONY	GR9	GRASS	PLY	PLAIN
BALCONY	GR0	GRASS	PLY	PLAIN
BALCONY	GR1	GRASS	PLY	PLAIN
BALCONY	GR2	GRASS	PLY	PLAIN
BALCONY	GR3	GRASS	PLY	PLAIN
BALCONY	GR4	GRASS	PLY	PLAIN
BALCONY	GR5	GRASS	PLY	PLAIN
BALCONY	GR6	GRASS	PLY	PLAIN
BALCONY	GR7	GRASS	PLY	PLAIN
BALCONY	GR8	GRASS	PLY	PLAIN
BALCONY	GR9	GRASS	PLY	PLAIN
BALCONY	GR0	GRASS	PLY	PLAIN
BALCONY	GR1	GRASS	PLY	PLAIN
BALCONY	GR2	GRASS	PLY	PLAIN
BALCONY	GR3	GRASS	PLY	PLAIN
BALCONY	GR4	GRASS	PLY	PLAIN
BALCONY	GR5	GRASS	PLY	PLAIN
BALCONY	GR6	GRASS	PLY	PLAIN
BALCONY	GR7	GRASS	PLY	PLAIN
BALCONY	GR8	GRASS	PLY	PLAIN
BALCONY	GR9	GRASS	PLY	PLAIN
BALCONY	GR0	GRASS	PLY	PLAIN
BALCONY	GR1	GRASS	PLY	PLAIN
BALCONY	GR2	GRASS	PLY	PLAIN
BALCONY	GR3	GRASS	PLY	PLAIN
BALCONY	GR4	GRASS	PLY	PLAIN
BALCONY	GR5	GRASS	PLY	PLAIN
BALCONY	GR6	GRASS	PLY	PLAIN
BALCONY	GR7	GRASS	PLY	PLAIN
BALCONY	GR8	GRASS	PLY	PLAIN
BALCONY	GR9	GRASS	PLY	PLAIN
BALCONY	GR0	GRASS	PLY	PLAIN
BALCONY	GR1	GRASS	PLY	PLAIN
BALCONY	GR2	GRASS	PLY	PLAIN
BALCONY	GR3	GRASS	PLY	PLAIN
BALCONY	GR4	GRASS	PLY	PLAIN
BALCONY	GR5	GRASS	PLY	PLAIN
BALCONY	GR6	GRASS	PLY	PLAIN
BALCONY	GR7	GRASS	PLY	PLAIN
BALCONY	GR8	GRASS	PLY	PLAIN
BALCONY	GR9	GRASS	PLY	PLAIN
BALCONY	GR0	GRASS	PLY	PLAIN
BALCONY	GR1	GRASS	PLY	PLAIN
BALCONY	GR2	GRASS	PLY	PLAIN
BALCONY	GR3	GRASS	PLY	PLAIN
BALCONY	GR4	GRASS	PLY	PLAIN
BALCONY	GR5	GRASS	PLY	PLAIN
BALCONY	GR6	GRASS	PLY	PLAIN
BALCONY	GR7	GRASS	PLY	PLAIN
BALCONY	GR8	GRASS	PLY	PLAIN
BALCONY	GR9	GRASS	PLY	PLAIN
BALCONY	GR0	GRASS	PLY	PLAIN
BALCONY	GR1	GRASS	PLY	PLAIN
BALCONY	GR2	GRASS	PLY	PLAIN
BALCONY	GR3	GRASS	PLY	PLAIN
BALCONY	GR4	GRASS	PLY	PLAIN
BALCONY	GR5	GRASS	PLY	PLAIN
BALCONY	GR6	GRASS	PLY	PLAIN
BALCONY	GR7	GRASS	PLY	PLAIN
BALCONY	GR8	GRASS	PLY	PLAIN
BALCONY	GR9	GRASS	PLY	PLAIN
BALCONY	GR0	GRASS	PLY	PLAIN
BALCONY	GR1	GRASS	PLY	PLAIN
BALCONY	GR2	GRASS	PLY	PLAIN
BALCONY	GR3	GRASS	PLY	PLAIN
BALCONY	GR4	GRASS	PLY	PLAIN
BALCONY	GR5	GRASS	PLY	PLAIN
BALCONY	GR6	GRASS	PLY	PLAIN
BALCONY	GR7	GRASS	PLY	PLAIN
BALCONY	GR8	GRASS	PLY	PLAIN
BALCONY	GR9	GRASS	PLY	PLAIN
BALCONY	GR0	GRASS	PLY	PLAIN
BALCONY	GR1	GRASS	PLY	PLAIN
BALCONY	GR2	GRASS	PLY	PLAIN
BALCONY	GR3	GRASS	PLY	PLAIN
BALCONY	GR4	GRASS	PLY	PLAIN
BALCONY	GR5	GRASS	PLY	PLAIN
BALCONY	GR6	GRASS	PLY	PLAIN
BALCONY	GR7	GRASS	PLY	PLAIN
BALCONY	GR8	GRASS	PLY	PLAIN
BALCONY	GR9	GRASS	PLY	PLAIN
BALCONY	GR0	GRASS	PLY	PLAIN
BALCONY	GR1	GRASS	PLY	PLAIN
BALCONY	GR2	GRASS	PLY	PLAIN
BALCONY	GR3	GRASS	PLY	PLAIN
BALCONY	GR4	GRASS	PLY	PLAIN
BALCONY	GR5	GRASS	PLY	PLAIN
BALCONY	GR6	GRASS	PLY	PLAIN
BALCONY	GR7	GRASS	PLY	PLAIN
BALCONY	GR8	GRASS	PLY	PLAIN
BALCONY	GR9	GRASS	PLY	PLAIN
BALCONY	GR0	GRASS	PLY	PLAIN
BALCONY	GR1	GRASS	PLY	PLAIN
BALCONY	GR2	GRASS	PLY	PLAIN
BALCONY	GR3	GRASS	PLY	PLAIN
BALCONY	GR4	GRASS	PLY	PLAIN
BALCONY	GR5	GRASS	PLY	PLAIN
BALCONY	GR6	GRASS	PLY	PLAIN
BALCONY	GR7	GRASS	PLY	PLAIN
BALCONY	GR8	GRASS	PLY	PLAIN
BALCONY	GR9	GRASS	PLY	PLAIN
BALCONY	GR0	GRASS	PLY	PLAIN
BALCONY	GR1	GRASS	PLY	PLAIN
BALCONY	GR2	GRASS	PLY	PLAIN
BALCONY	GR3	GRASS	PLY	PLAIN
BALCONY	GR4	GRASS	PLY	PLAIN
BALCONY	GR5	GRASS	PLY	PLAIN
BALCONY	GR6	GRASS	PLY	PLAIN
BALCONY	GR7	GRASS	PLY	PLAIN
BALCONY	GR8	GRASS	PLY	PLAIN
BALCONY	GR9	GRASS	PLY	PLAIN
BALCONY	GR0	GRASS	PLY	PLAIN
BALCONY	GR1	GRASS	PLY	PLAIN
BALCONY	GR2	GRASS	PLY	PLAIN
BALCONY	GR3	GRASS	PLY	PLAIN
BALCONY	GR4	GRASS	PLY	PLAIN
BALCONY	GR5	GRASS	PLY	PLAIN
BALCONY	GR6	GRASS	PLY	PLAIN
BALCONY	GR7	GRASS	PLY	PLAIN
BALCONY	GR8	GRASS	PLY	PLAIN
BALCONY	GR9	GRASS	PLY	PLAIN
BALCONY	GR0	GRASS	PLY	PLAIN
BALCONY	GR1	GRASS	PLY	PLAIN
BALCONY	GR2	GRASS	PLY	PLAIN
BALCONY	GR3	GRASS	PLY	PLAIN
BALCONY	GR4	GRASS	PLY	PLAIN
BALCONY	GR5	GRASS	PLY	PLAIN
BALCONY	GR6	GRASS	PLY	PLAIN
BALCONY	GR7	GRASS	PLY	PLAIN
BALCONY	GR8	GRASS	PLY	PLAIN
BALCONY	GR9	GRASS	PLY	PLAIN
BALCONY	GR0	GRASS	PLY	PLAIN
BALCONY	GR1	GRASS	PLY	PLAIN
BALCONY	GR2	GRASS	PLY	PLAIN
BALCONY	GR3	GRASS	PLY	PLAIN
BALCONY	GR4	GRASS	PLY	PLAIN
BALCONY	GR5	GRASS	PLY	PLAIN
BALCONY	GR6	GRASS	PLY	PLAIN
BALCONY	GR7	GRASS	PLY	PLAIN
BALCONY	GR8	GRASS	PLY	PLAIN
BALCONY	GR9	GRASS	PLY	PLAIN
BALCONY	GR0	GRASS	PLY	PLAIN
BALCONY	GR1	GRASS	PLY	PLAIN
BALCONY	GR2	GRASS	PLY	PLAIN
BALCONY	GR3	GRASS	PLY	PLAIN
BALCONY	GR4	GRASS	PLY	PLAIN
BALCONY	GR5	GRASS	PLY	PLAIN
BALCONY	GR6	GRASS	PLY	PLAIN
BALCONY	GR7	GRASS	PLY	PLAIN
BALCONY	GR8	GRASS	PLY	PLAIN
BALCONY	GR9	GRASS	PLY	PLAIN
BALCONY	GR0	GRASS	PLY	PLAIN
BALCONY	GR1	GRASS	PLY	PLAIN
BALCONY	GR2	GRASS	PLY	PLAIN
BALCONY	GR3	GRASS	PLY	PLAIN
BALCONY	GR4	GRASS	PLY	PLAIN
BALCONY	GR5	GRASS	PLY	PLAIN
BALCONY	GR6	GRASS	PLY	PLAIN
BALCONY	GR7	GRASS	PLY	PLAIN
BALCONY	GR8	GRASS	PLY	PLAIN
BALCONY	GR9	GRASS	PLY	PLAIN
BALCONY	GR0	GRASS	PLY	PLAIN
BALCONY	GR1	GRASS	PLY	PLAIN
BALCONY	GR2	GRASS	PLY	PLAIN
BALCONY	GR3	GRASS	PLY	PLAIN
BALCONY	GR4	GRASS	PLY	PLAIN
BALCONY	GR5	GRASS	PLY	PLAIN
BALCONY	GR6	GRASS	PLY	PLAIN
BALCONY	GR7	GRASS	PLY	PLAIN
BALCONY	GR8	GRASS	PLY	PLAIN
BALCONY	GR9	GRASS	PLY	PLAIN
BALCONY	GR0	GRASS	PLY	PLAIN
BALCONY	GR1	GRASS	PLY	PLAIN
BALCONY	GR2	GRASS	PLY	PLAIN
BALCONY	GR3	GRASS	PLY	PLAIN
BALCONY	GR4	GRASS	PLY	PLAIN
BALCONY	GR5	GRASS	PLY	PLAIN
BALCONY	GR6	GRASS	PLY	PLAIN
BALCONY	GR7	GRASS	PLY	PLAIN
BALCONY	GR8	GRASS	PLY	PLAIN
BALCONY	GR9	GRASS	PLY	PLAIN
BALCONY	GR0	GRASS	PLY	PLAIN
BALCONY	GR1	GRASS	PLY	PLAIN
BALCONY	GR2	GRASS	PLY	PLAIN
BALCONY	GR3	GRASS	PLY	PLAIN
BALCONY	GR4	GRASS	PLY	PLAIN
BALCONY	GR5	GRASS	PLY	PLAIN
BALCONY	GR6	GRASS	PLY	PLAIN
BALCONY	GR7	GRASS	PLY	PLAIN
BALCONY	GR8	GRASS	PLY	PLAIN
BALCONY	GR9	GRASS	PLY	PLAIN
BALCONY	GR0	GRASS	PLY	PLAIN
BALCONY	GR1	GRASS	PLY	PLAIN
BALCONY	GR2	GRASS	PLY	PLAIN
BALCONY	GR3	GRASS	PLY	PLAIN
BALCONY	GR4	GRASS	PLY	PLAIN
BALCONY	GR5	GRASS	PLY	PLAIN
BALCONY	GR6	GRASS	PLY	PLAIN
BALCONY	GR7	GRASS	PLY	PLAIN
BALCONY	GR8	GRASS	PLY	PLAIN
BALCONY	GR9	GRASS	PLY	

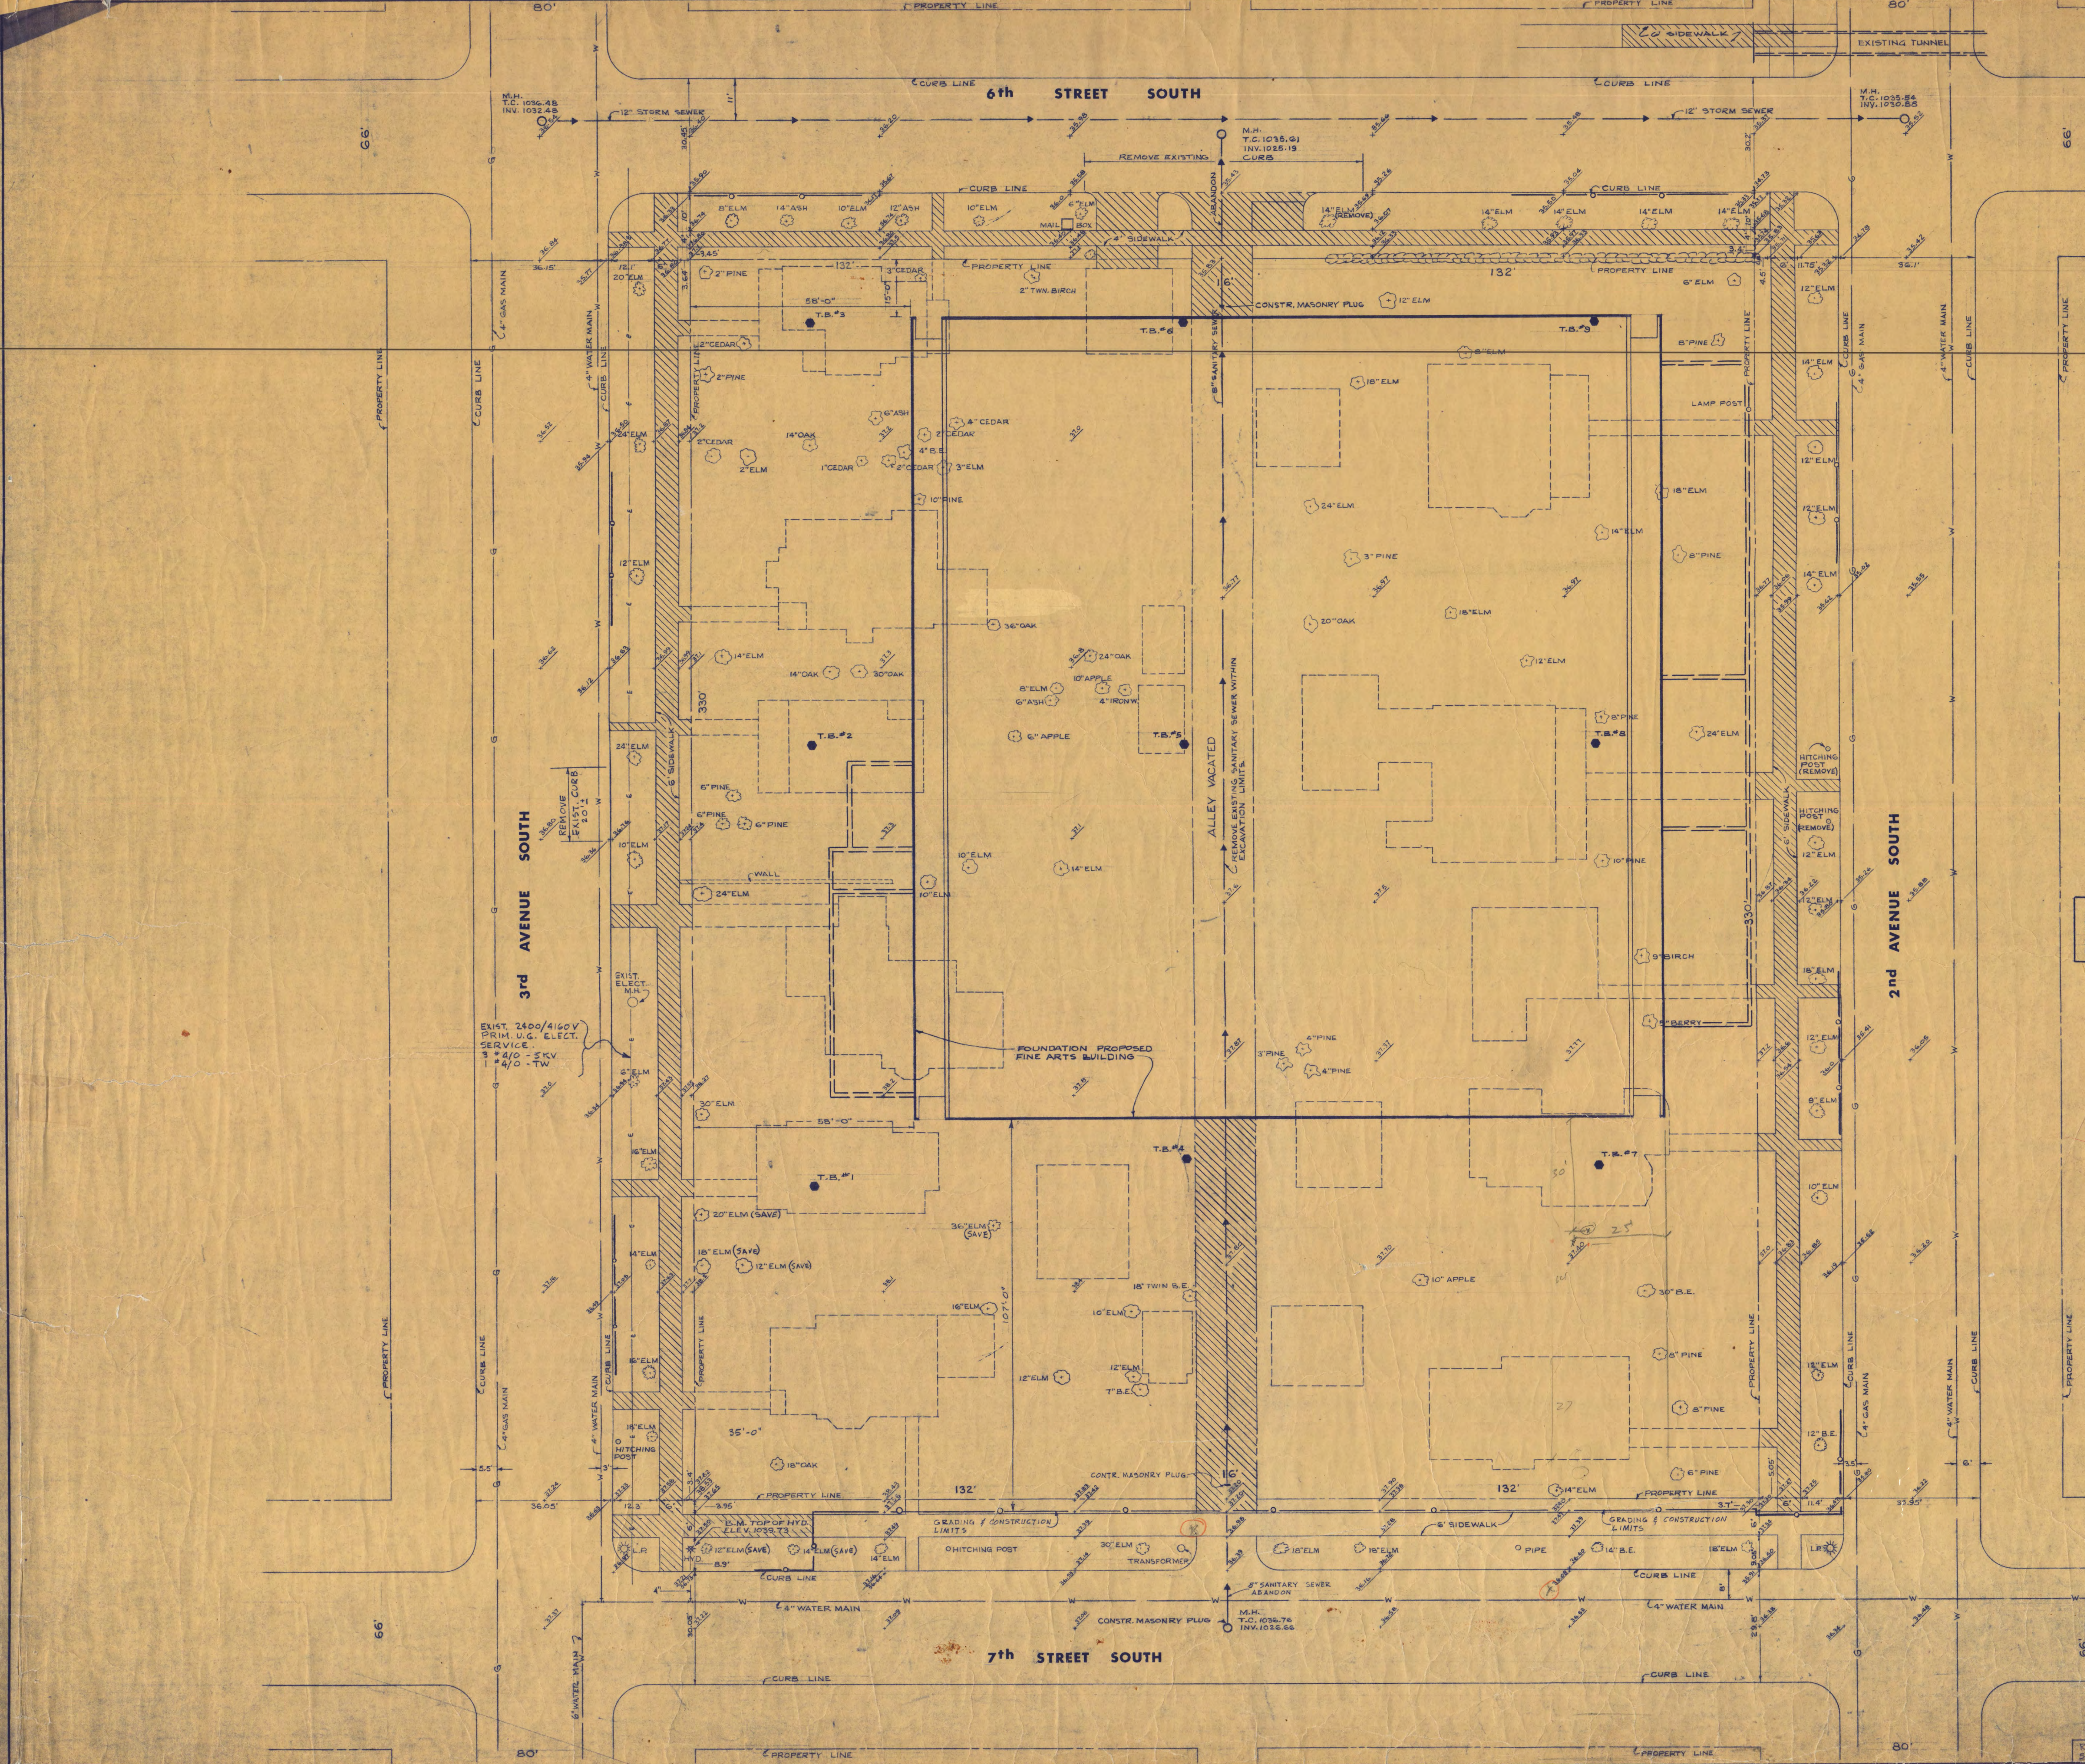

- NOTES:
- 1- ALL BUILDINGS WITHIN PROPERTY LINES ARE OR WILL BE REMOVED PRIOR TO ANY CONSTRUCTION. THESE REMOVALS ARE NOT PART OF THIS CONTRACT.
 - 2- ALL TREES LOCATED WITHIN SWD. AREAS SHALL BE SAVED UNLESS NOTED OTHERWISE. ALL TREES LOCATED WITHIN THE BLDG. LINES SHALL BE REMOVED.
 - 3- HATCHED AREA INDICATES REMOVAL.

BENCH MARK DATA

NO. 1 TOP HYD. N.E. COR. 2ND AVE. & 7TH ST. ELEV. 1039.67
NO. 2 TOP HYD. N.E. COR. 2ND AVE. & 6TH ST. ELEV. 1038.07
NO. 3 TOP HYD. N.E. COR. 3RD AVE. & 7TH ST. ELEV. 1039.73
NO. 4 TOP HYD. N.E. COR. 3RD AVE. & 6TH ST. ELEV. 1039.01

COPY OF ORIGINAL SURVEY BY
MILNER W. CARLEY & ASSOCIATES
ST. CLOUD, MINNESOTA
DATED APRIL 20, 1964
SIGNED BY MILNER W. CARLEY
REGISTERED LAND SURVEYOR

SCALE 1/16" = 1'-0"

WALTER BUTLER COMPANY
HAARSTICK LUNDGREN AND ASSOCIATES INC.
 ARCHITECTS ENGINEERS
 ST. PAUL MINN.

FINE ARTS BUILDING
 ST. CLOUD STATE COLLEGE
 ST. CLOUD, MINNESOTA

DEPARTMENT OF ADMINISTRATION - STATE OF MINNESOTA
 ST. PAUL, MINNESOTA STATE ARCHITECT

A. J. NELSON



STATE PROJECT NO. 3750	APPROVED BY: _____	PRESIDENT, ST. CLOUD STATE COLLEGE
CONTRACT NO. 6401	APPROVED BY: _____	EXECUTIVE DIRECTOR, STATE COLLEGE BOARD
DATE: 6-15-65	APPROVED BY: _____	COMMISSIONER OF ADMINISTRATION (AN AUTHORIZED SIGNATURE)

DATE: 6-15-65
 DRAWN BY: L.O.E.
 CHECKED BY: G.L.
 SHEET NO. **A-2**







I HEREBY CERTIFY THAT THIS DRAWING WAS PREPARED BY ME OR UNDER MY DIRECT SUPERVISION AND THAT I AM A REGISTERED ARCHITECT UNDER THE LAWS OF THE STATE OF MINNESOTA.

ARCHITECTURAL SURVEY

REV. DATE: 8-16-66

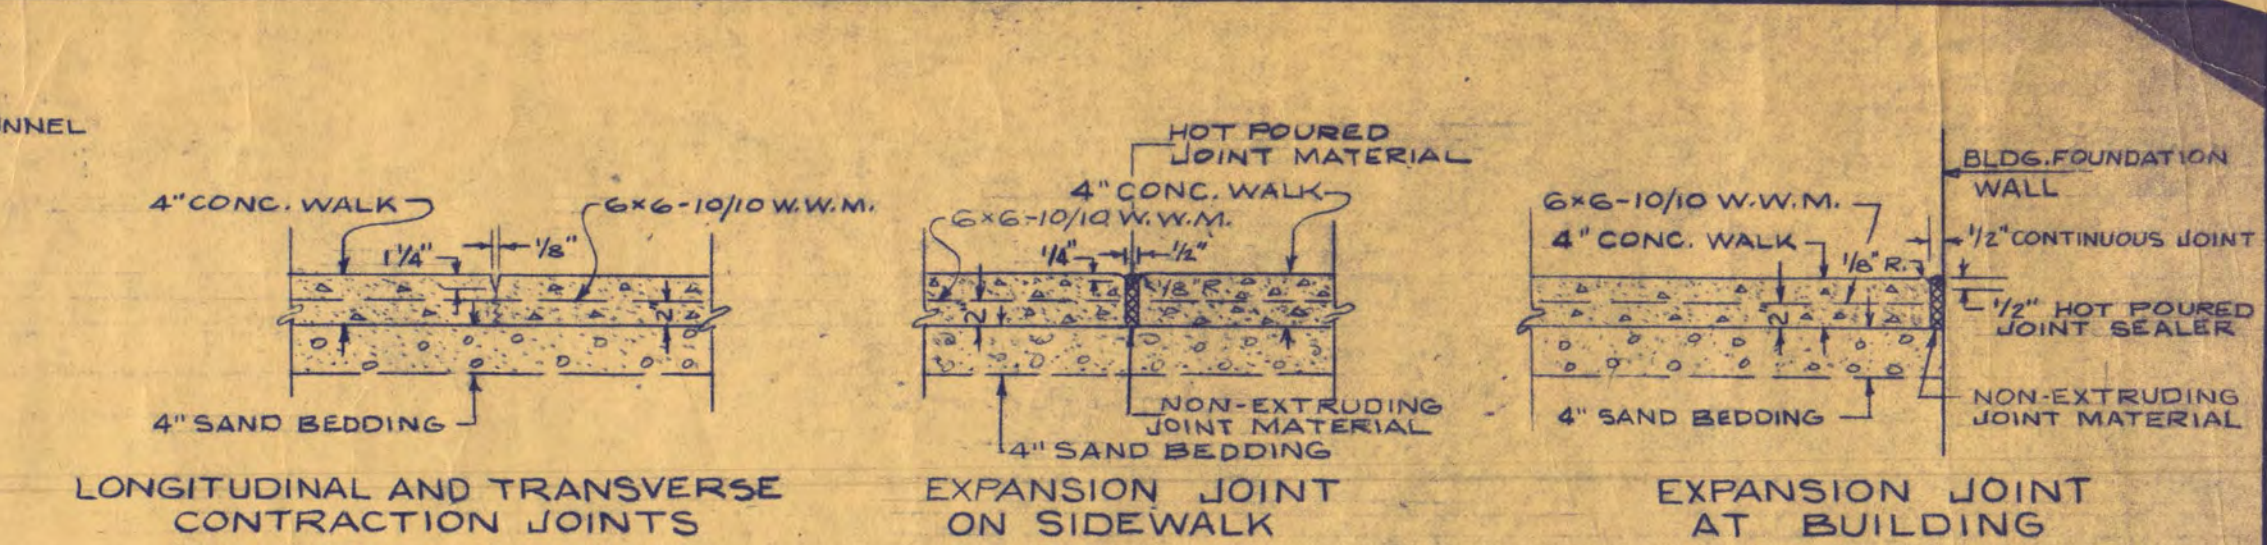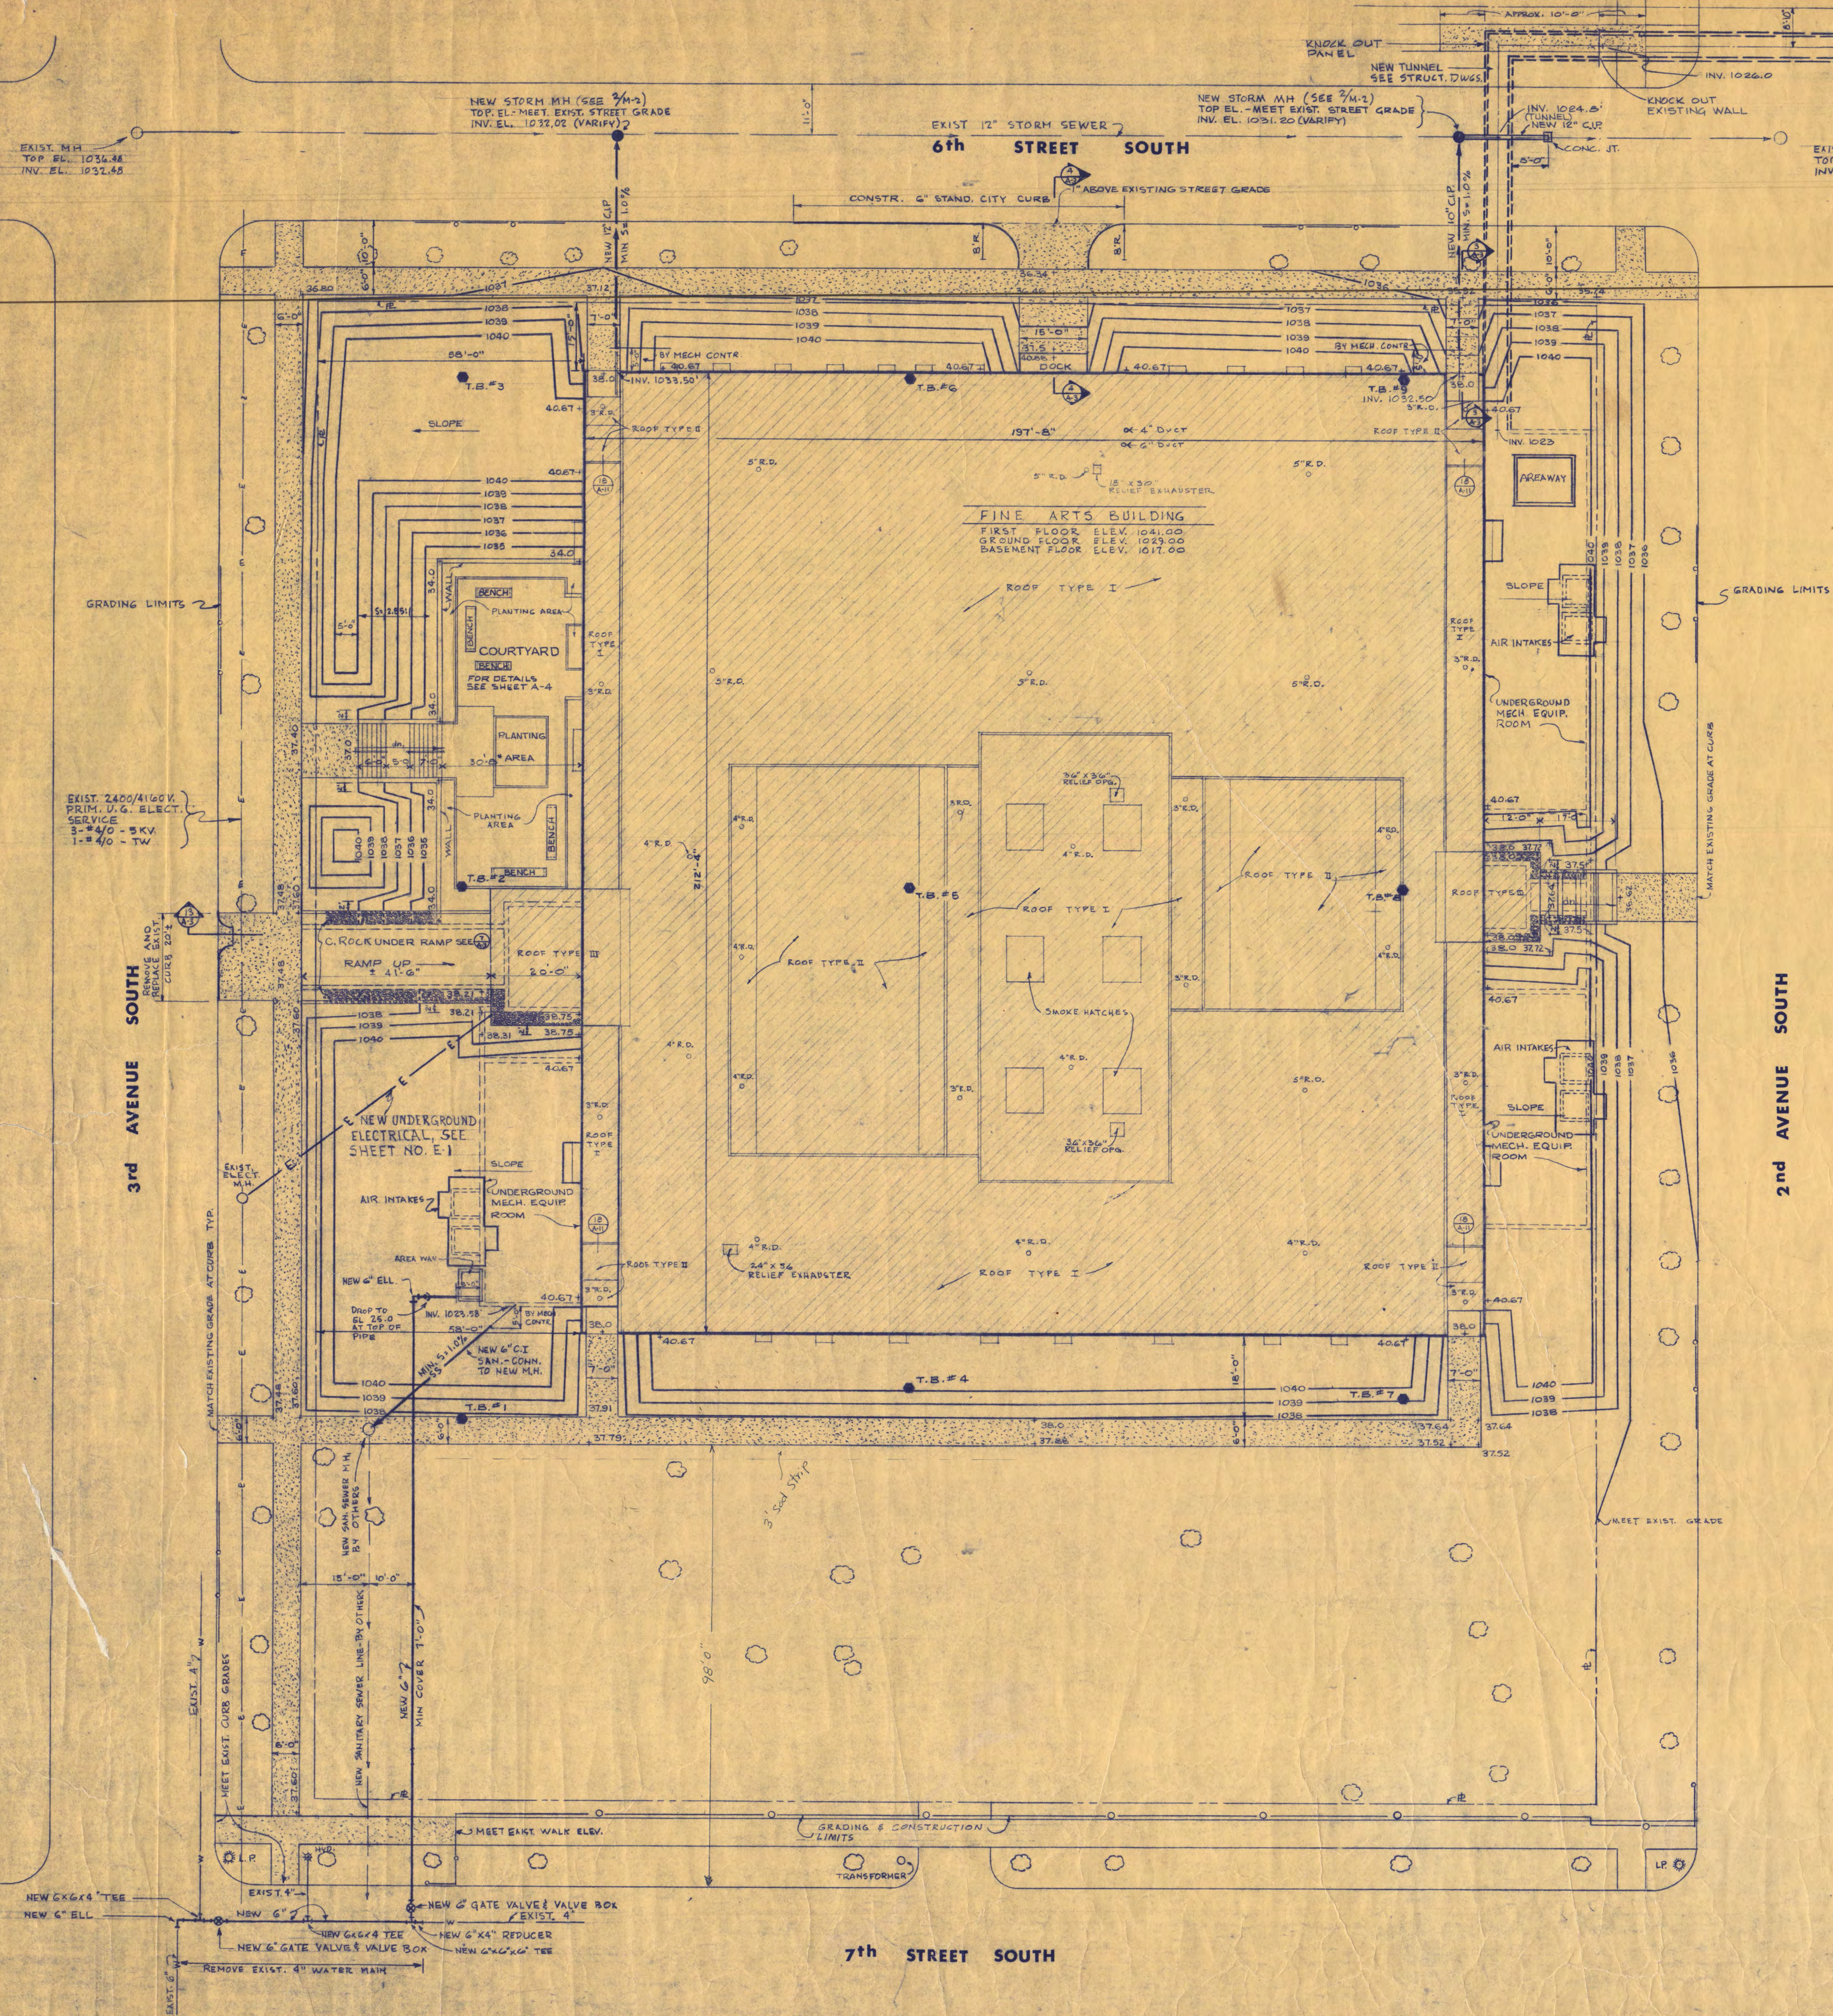


GENERAL NOTES:
 1. EXPANSION JOINTS SHALL BE PLACED AT ALL INTERSECTIONS OF WALKS AND WHERE WALKS BUTT AGAINST BUILDING, CURB OR OTHER IMMOVABLE OBJECTS.
 2. ALL WALKS SHALL BE EDGED WITH 1/2" RADIUS AT ALL EXPOSED EDGES.
 3. TRANSVERSE EXPANSION JOINTS SHALL BE PLACED AT UNIFORM INTERVALS OF NOT MORE THAN 30'-0".
 4. NO SIDEWALK PANEL SHALL BE GREATER THAN 36 SQ. FT. IN AREA. IN GENERAL, CONTRACTION JOINTS SHALL EQUAL WALK WIDTHS.

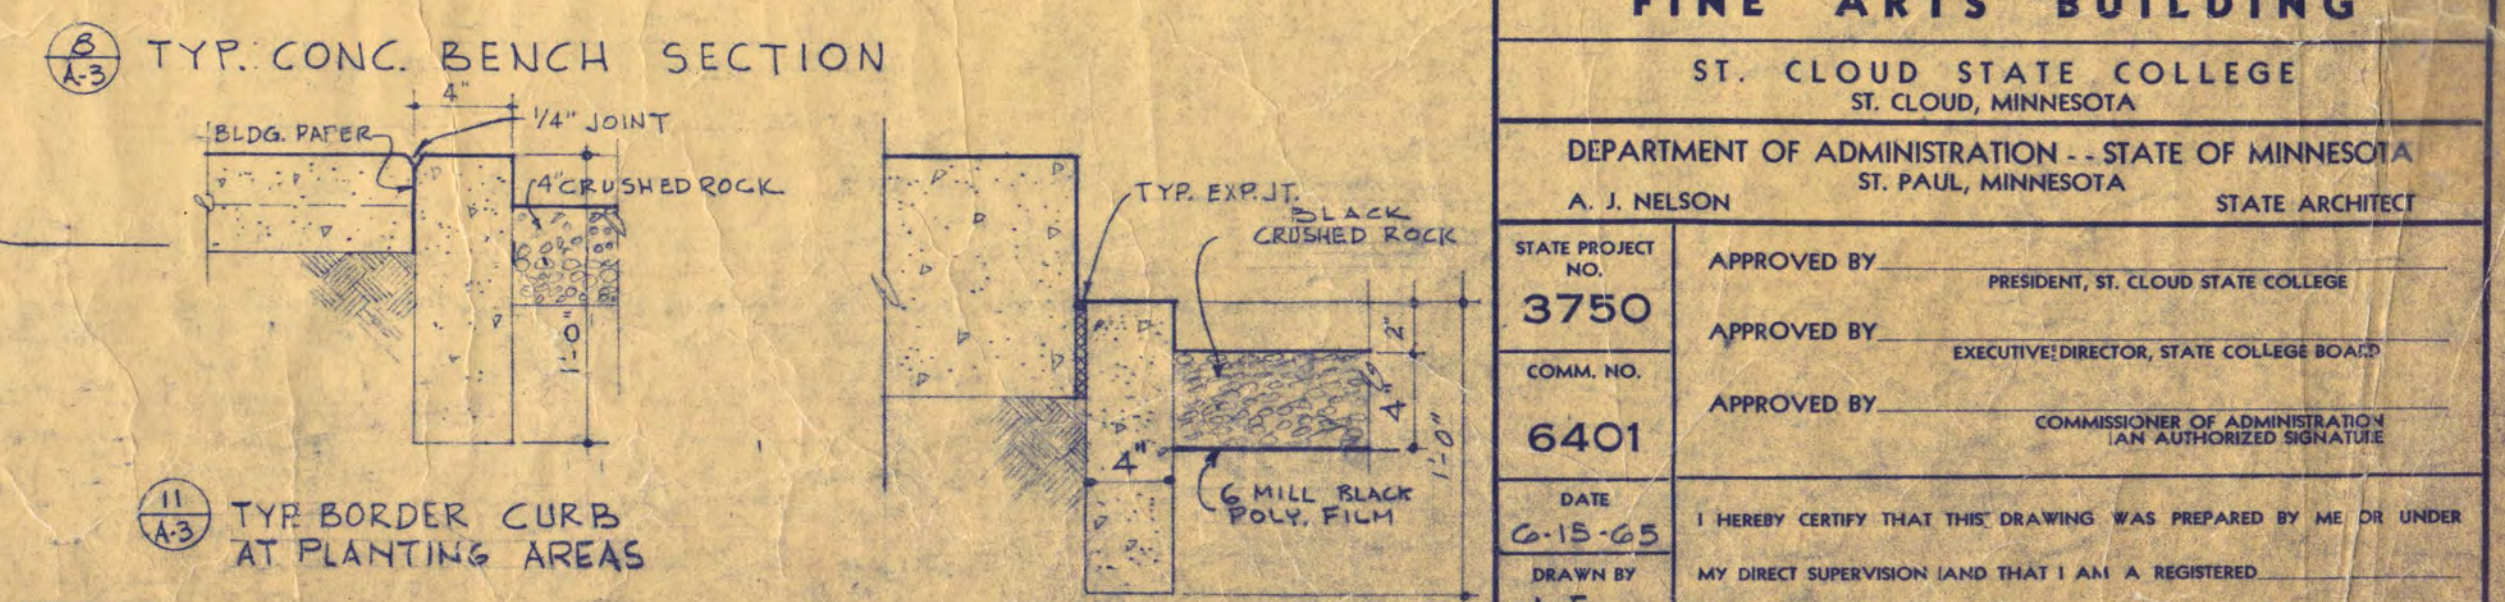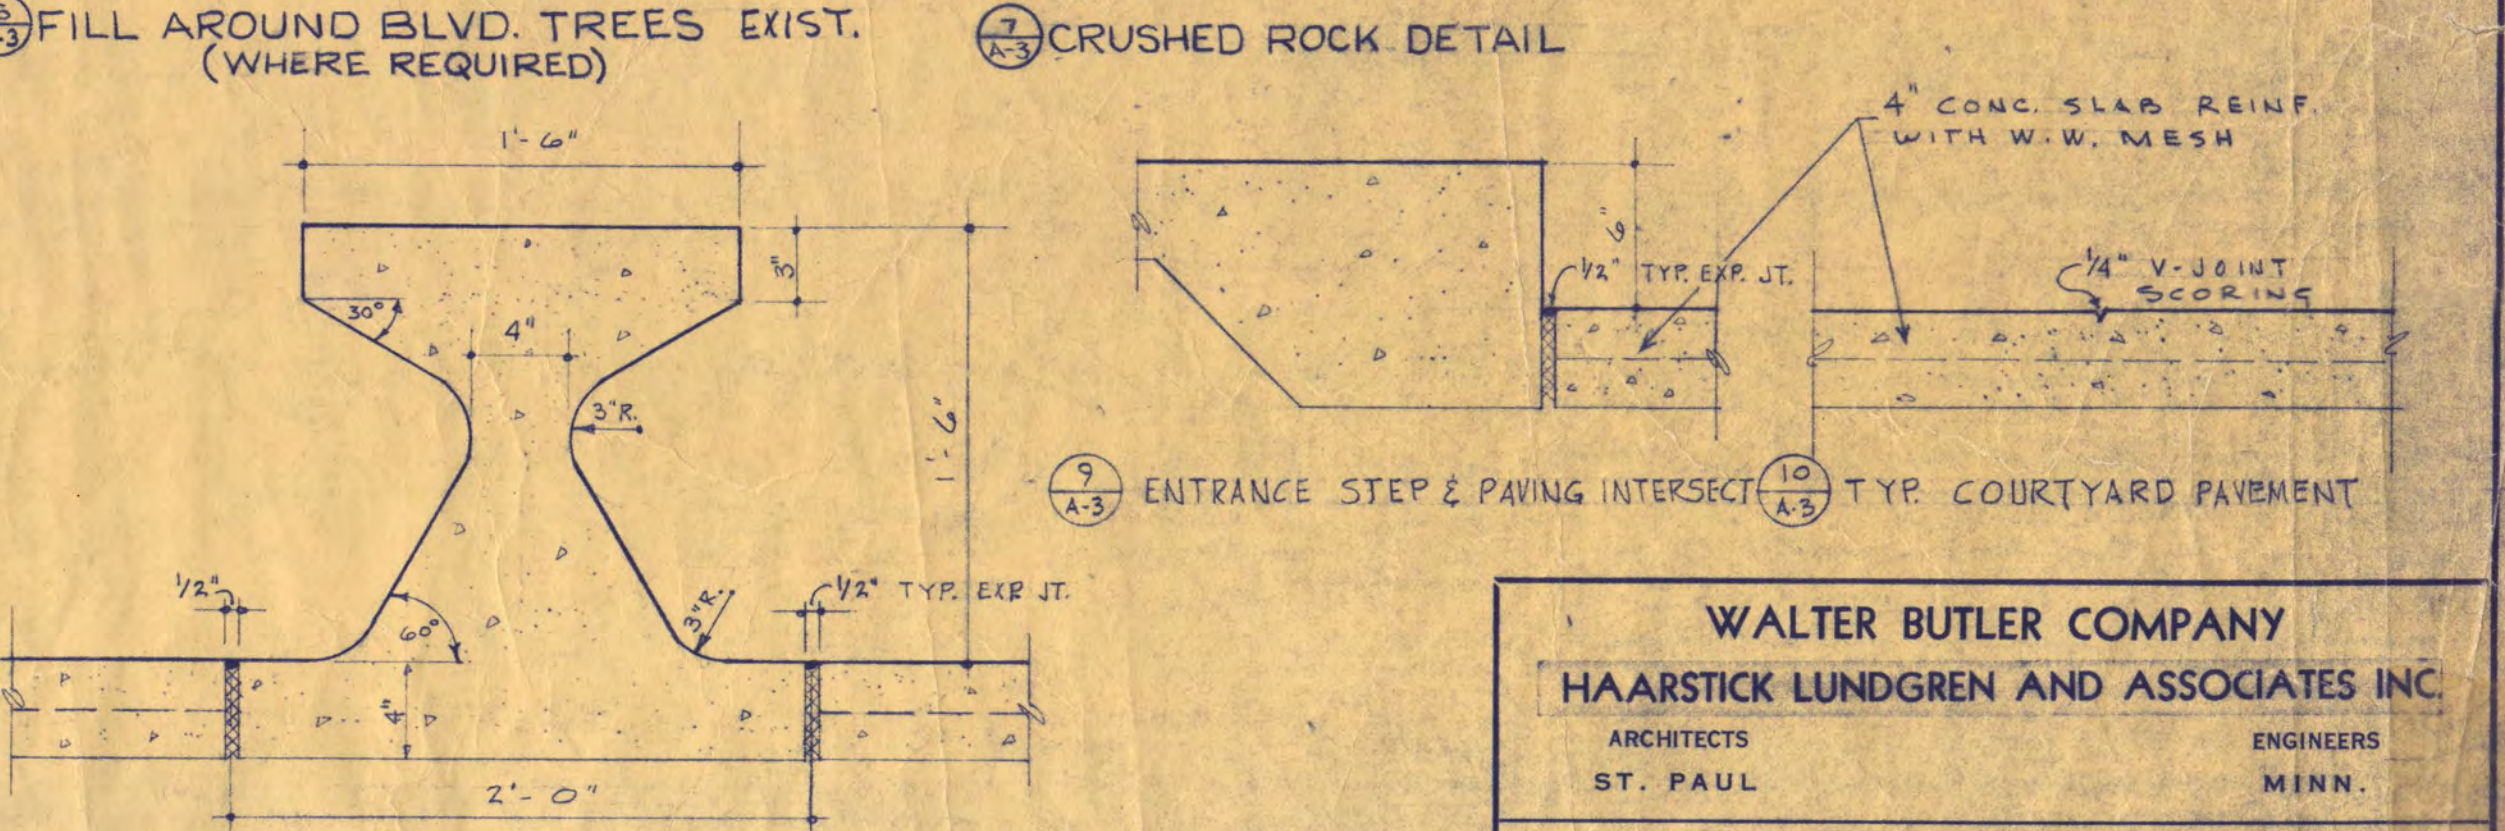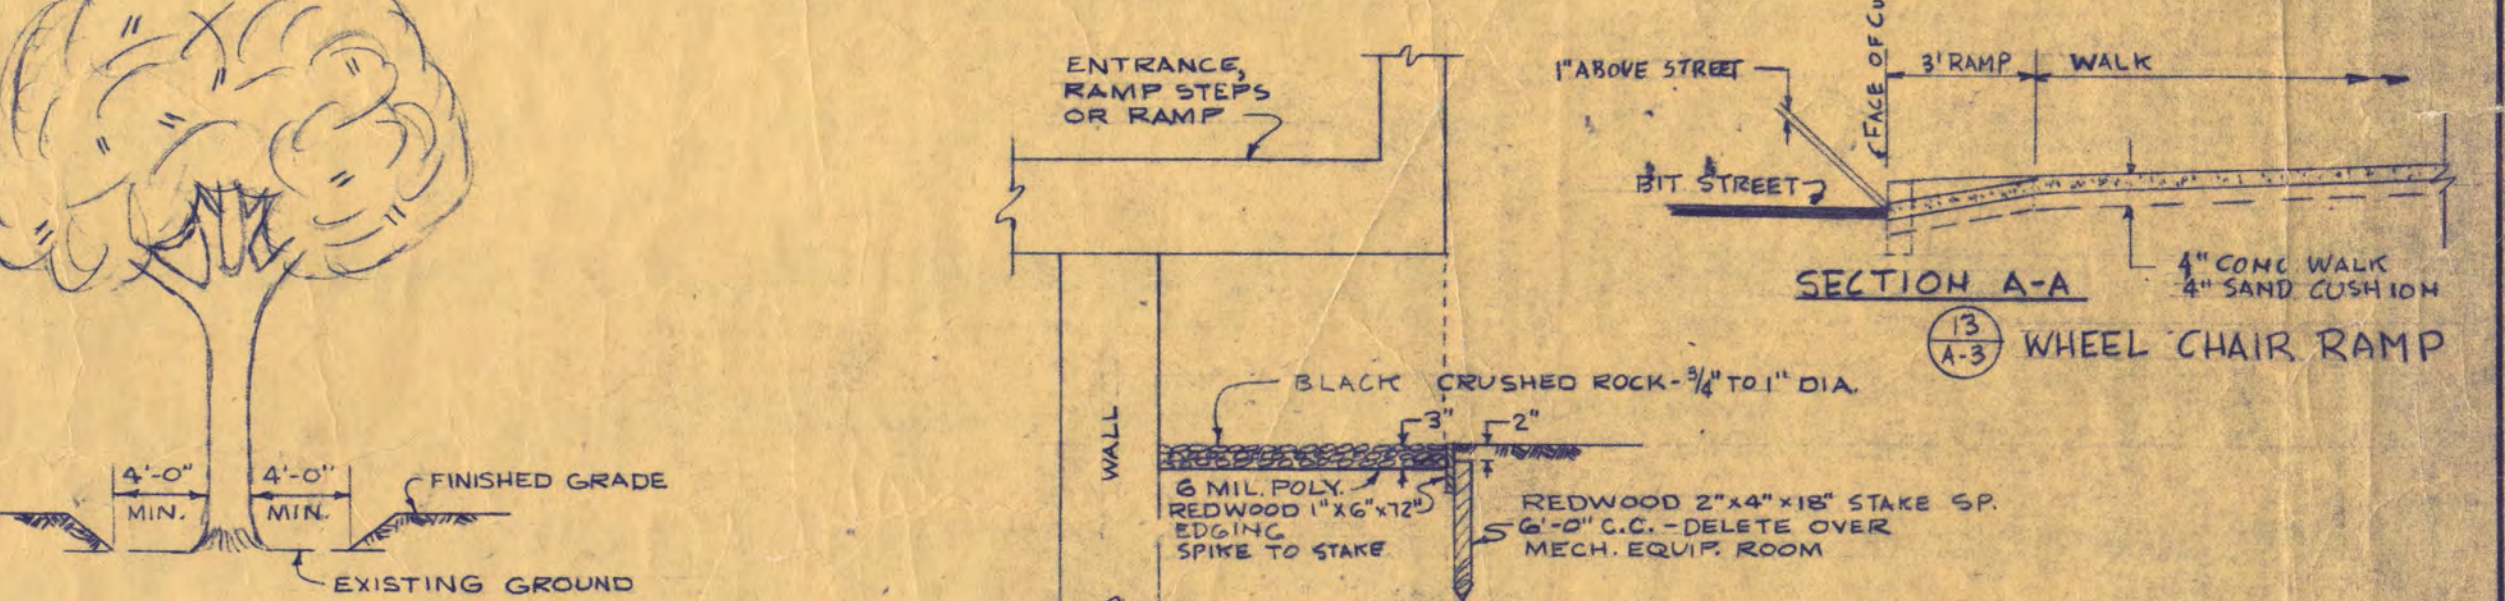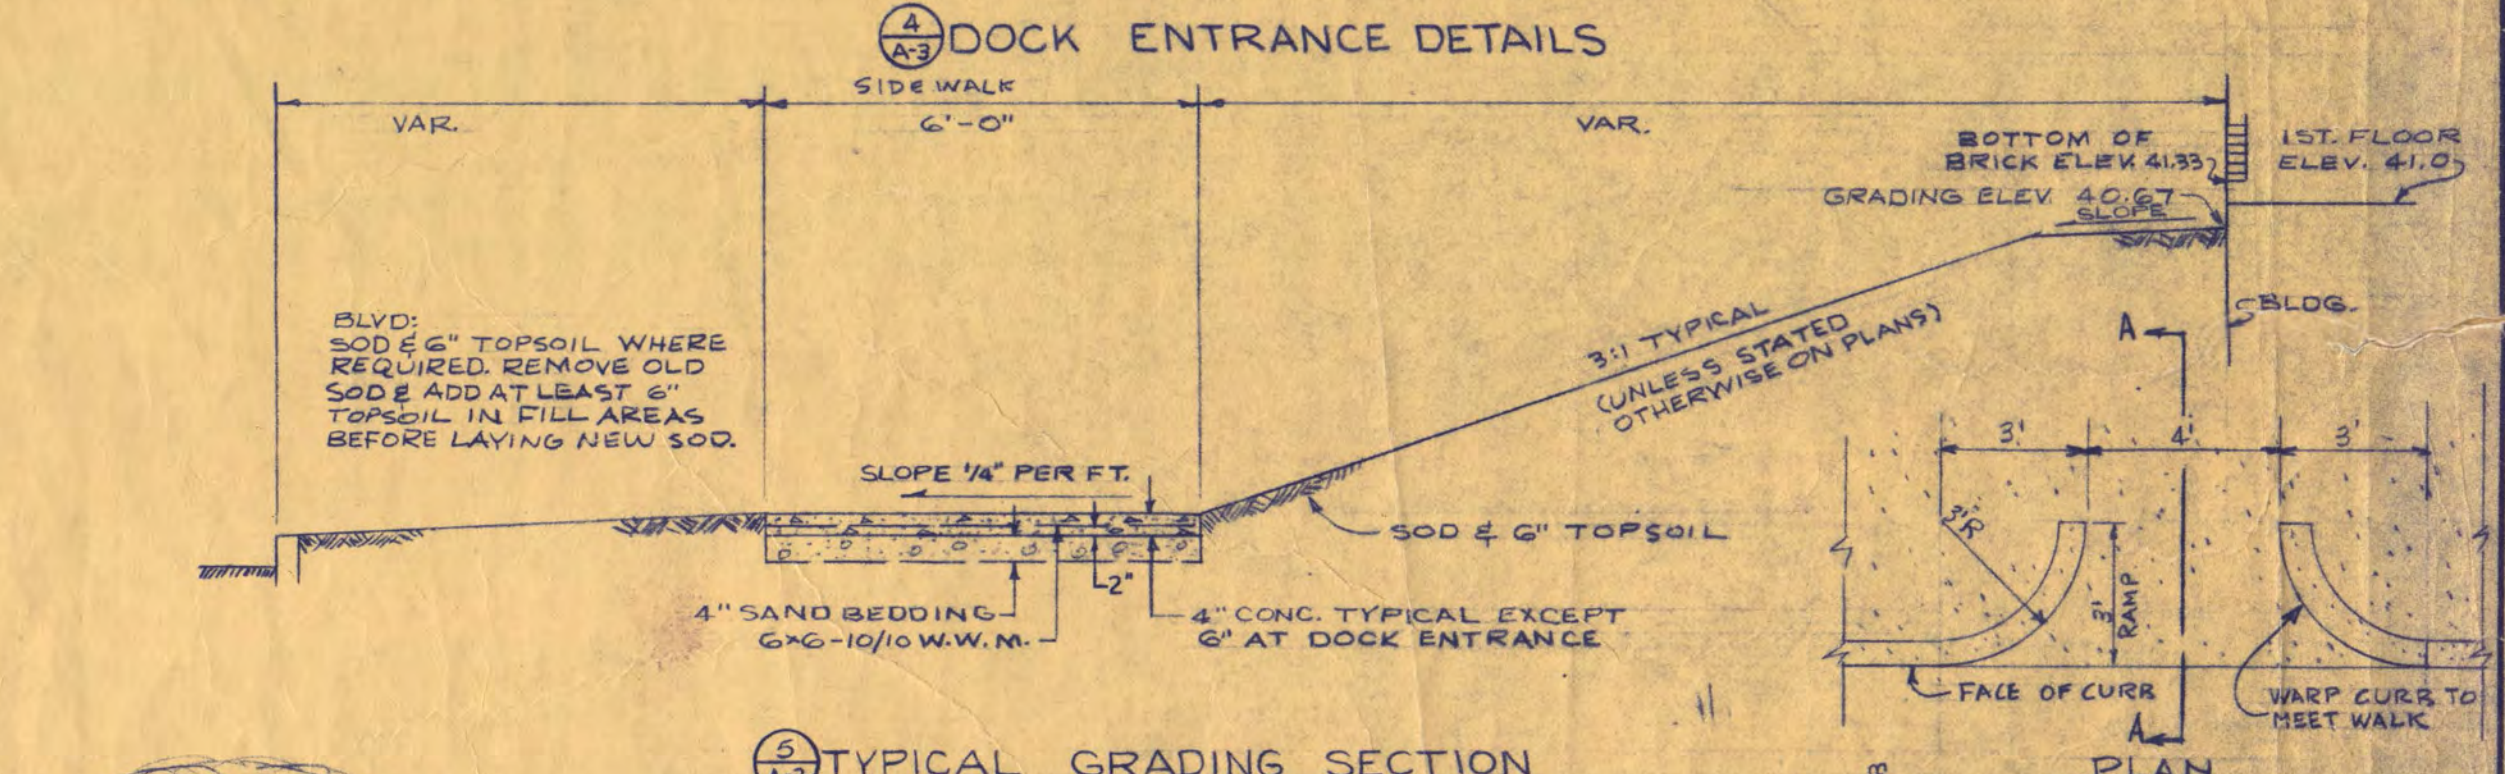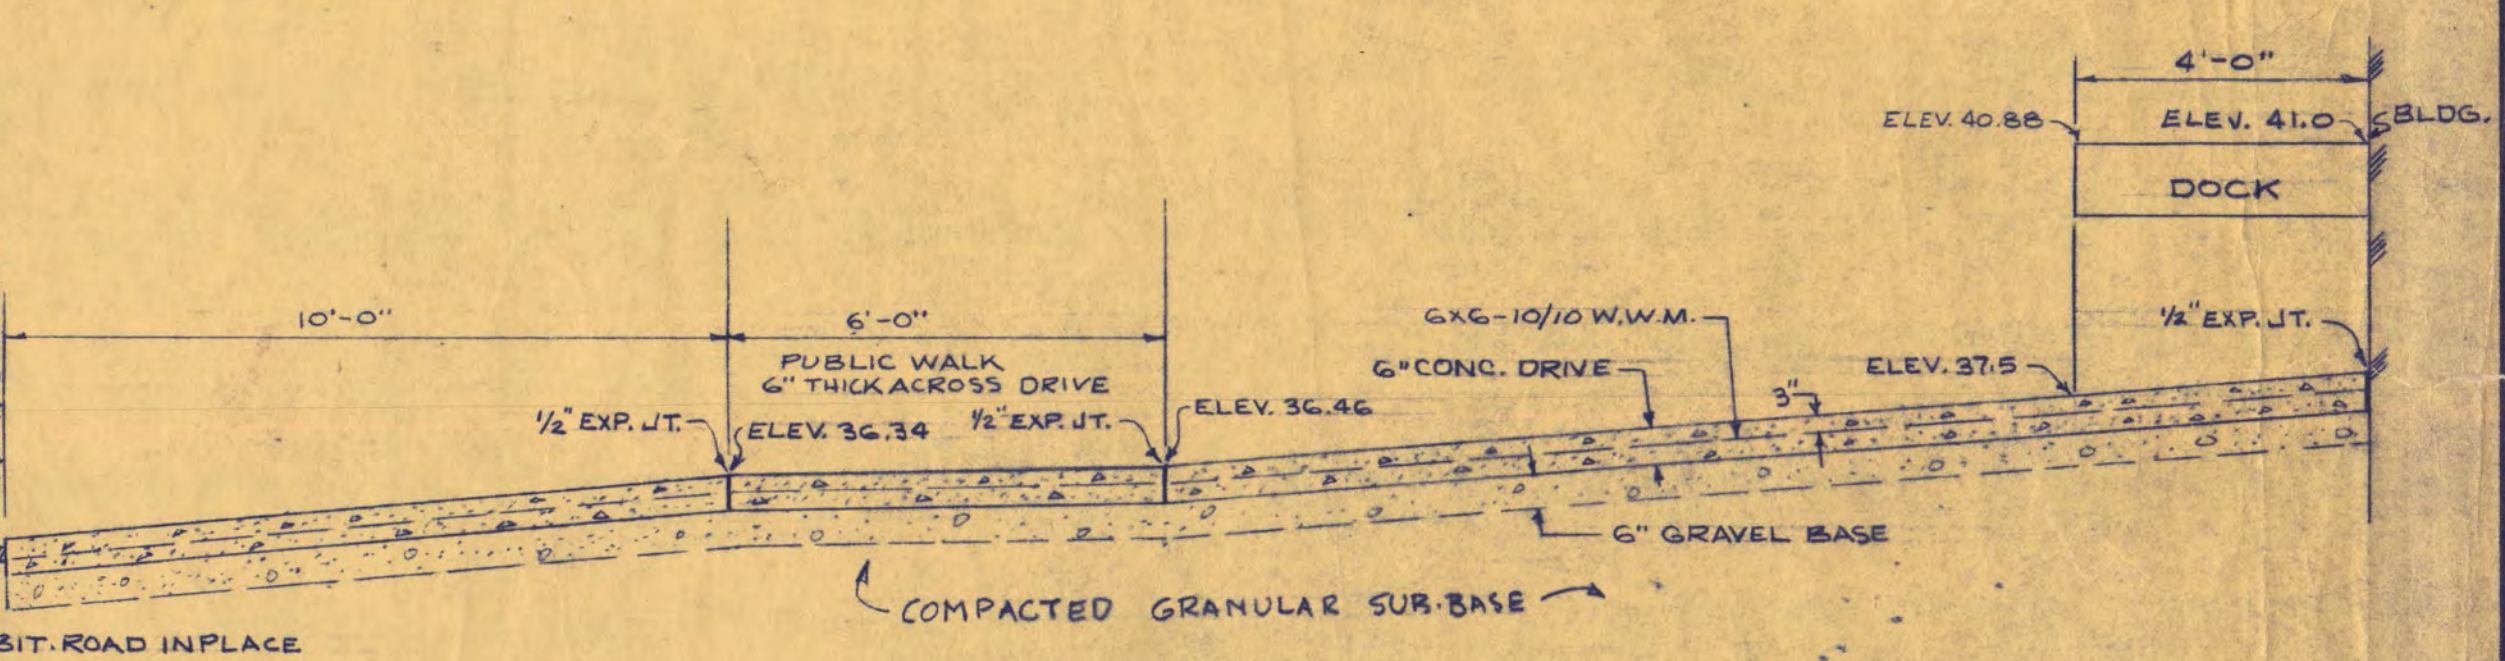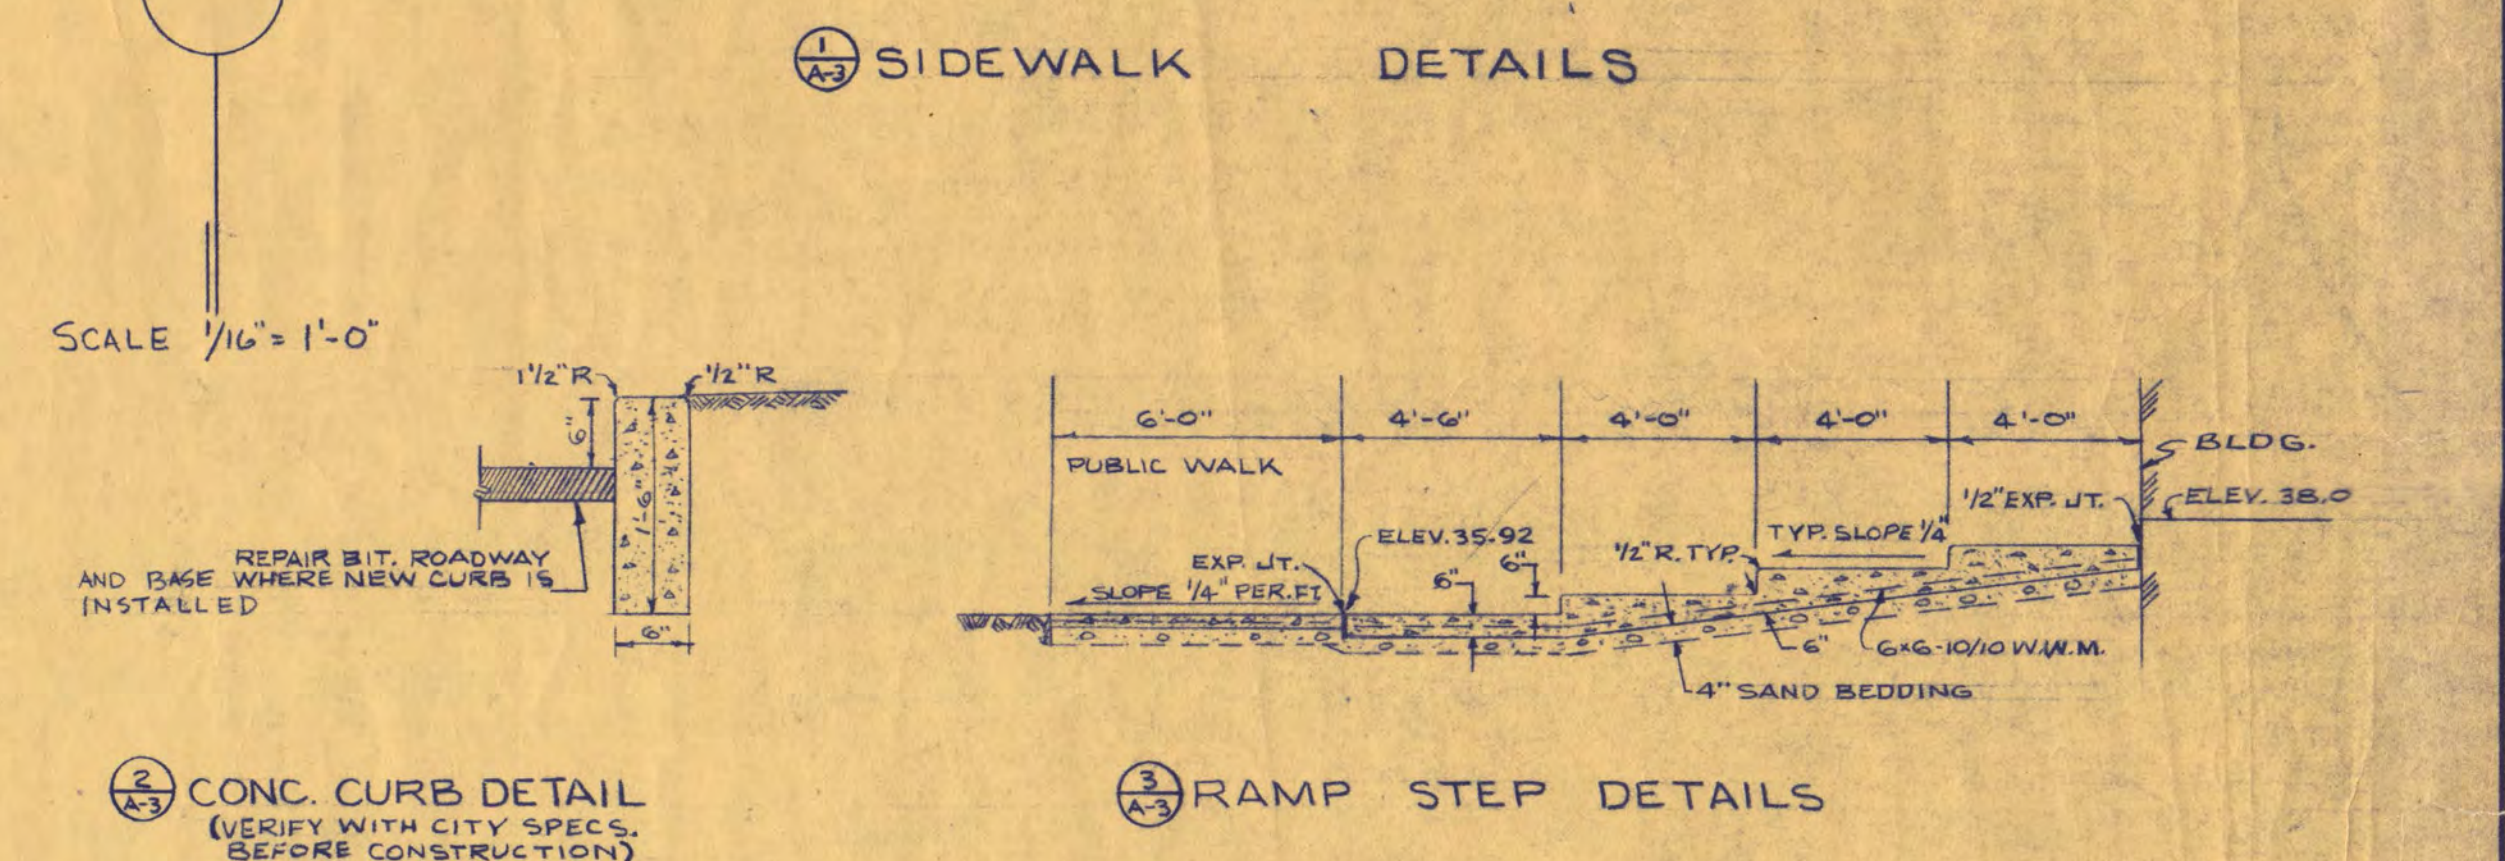

ROOF & PLOT PLAN 1/4" = 1'-0"
 NOTE: ALL ELEVATIONS SHALL BE IN 1000.0' RANGE WHERE SHOWN THUS +37.20

WALTER BUTLER COMPANY	
HAARSTICK LUNDGREN AND ASSOCIATES INC.	
ARCHITECTS ST. PAUL	ENGINEERS MINN.
FINE ARTS BUILDING	
ST. CLOUD STATE COLLEGE ST. CLOUD, MINNESOTA	
DEPARTMENT OF ADMINISTRATION - STATE OF MINNESOTA A. J. NELSON STATE ARCHITECT	
STATE PROJECT NO. 3750	APPROVED BY: PRESIDENT, ST. CLOUD STATE COLLEGE
CONTRACT NO. 6401	APPROVED BY: EXECUTIVE DIRECTOR, STATE COLLEGE BOARD
DATE 6-15-65	APPROVED BY: COMMISSIONER OF ADMINISTRATION (AN AUTHORIZED SIGNATORY)
DRAWN BY LE	I HEREBY CERTIFY THAT THIS DRAWING WAS PREPARED BY ME OR UNDER MY DIRECT SUPERVISION AND THAT I AM A REGISTERED ARCHITECT UNDER THE LAWS OF THE STATE OF MINN.
CHECKED BY G.L.	REG. NO.
SHEET NO. A-3	ARCHITECTURAL
REV. DATE 5-16-65	OF 17 SHEET
ROOF & PLOT PLAN	

3'-4" 3'-4" 6'-8" 4'-7" 7'-1" 2'-0"

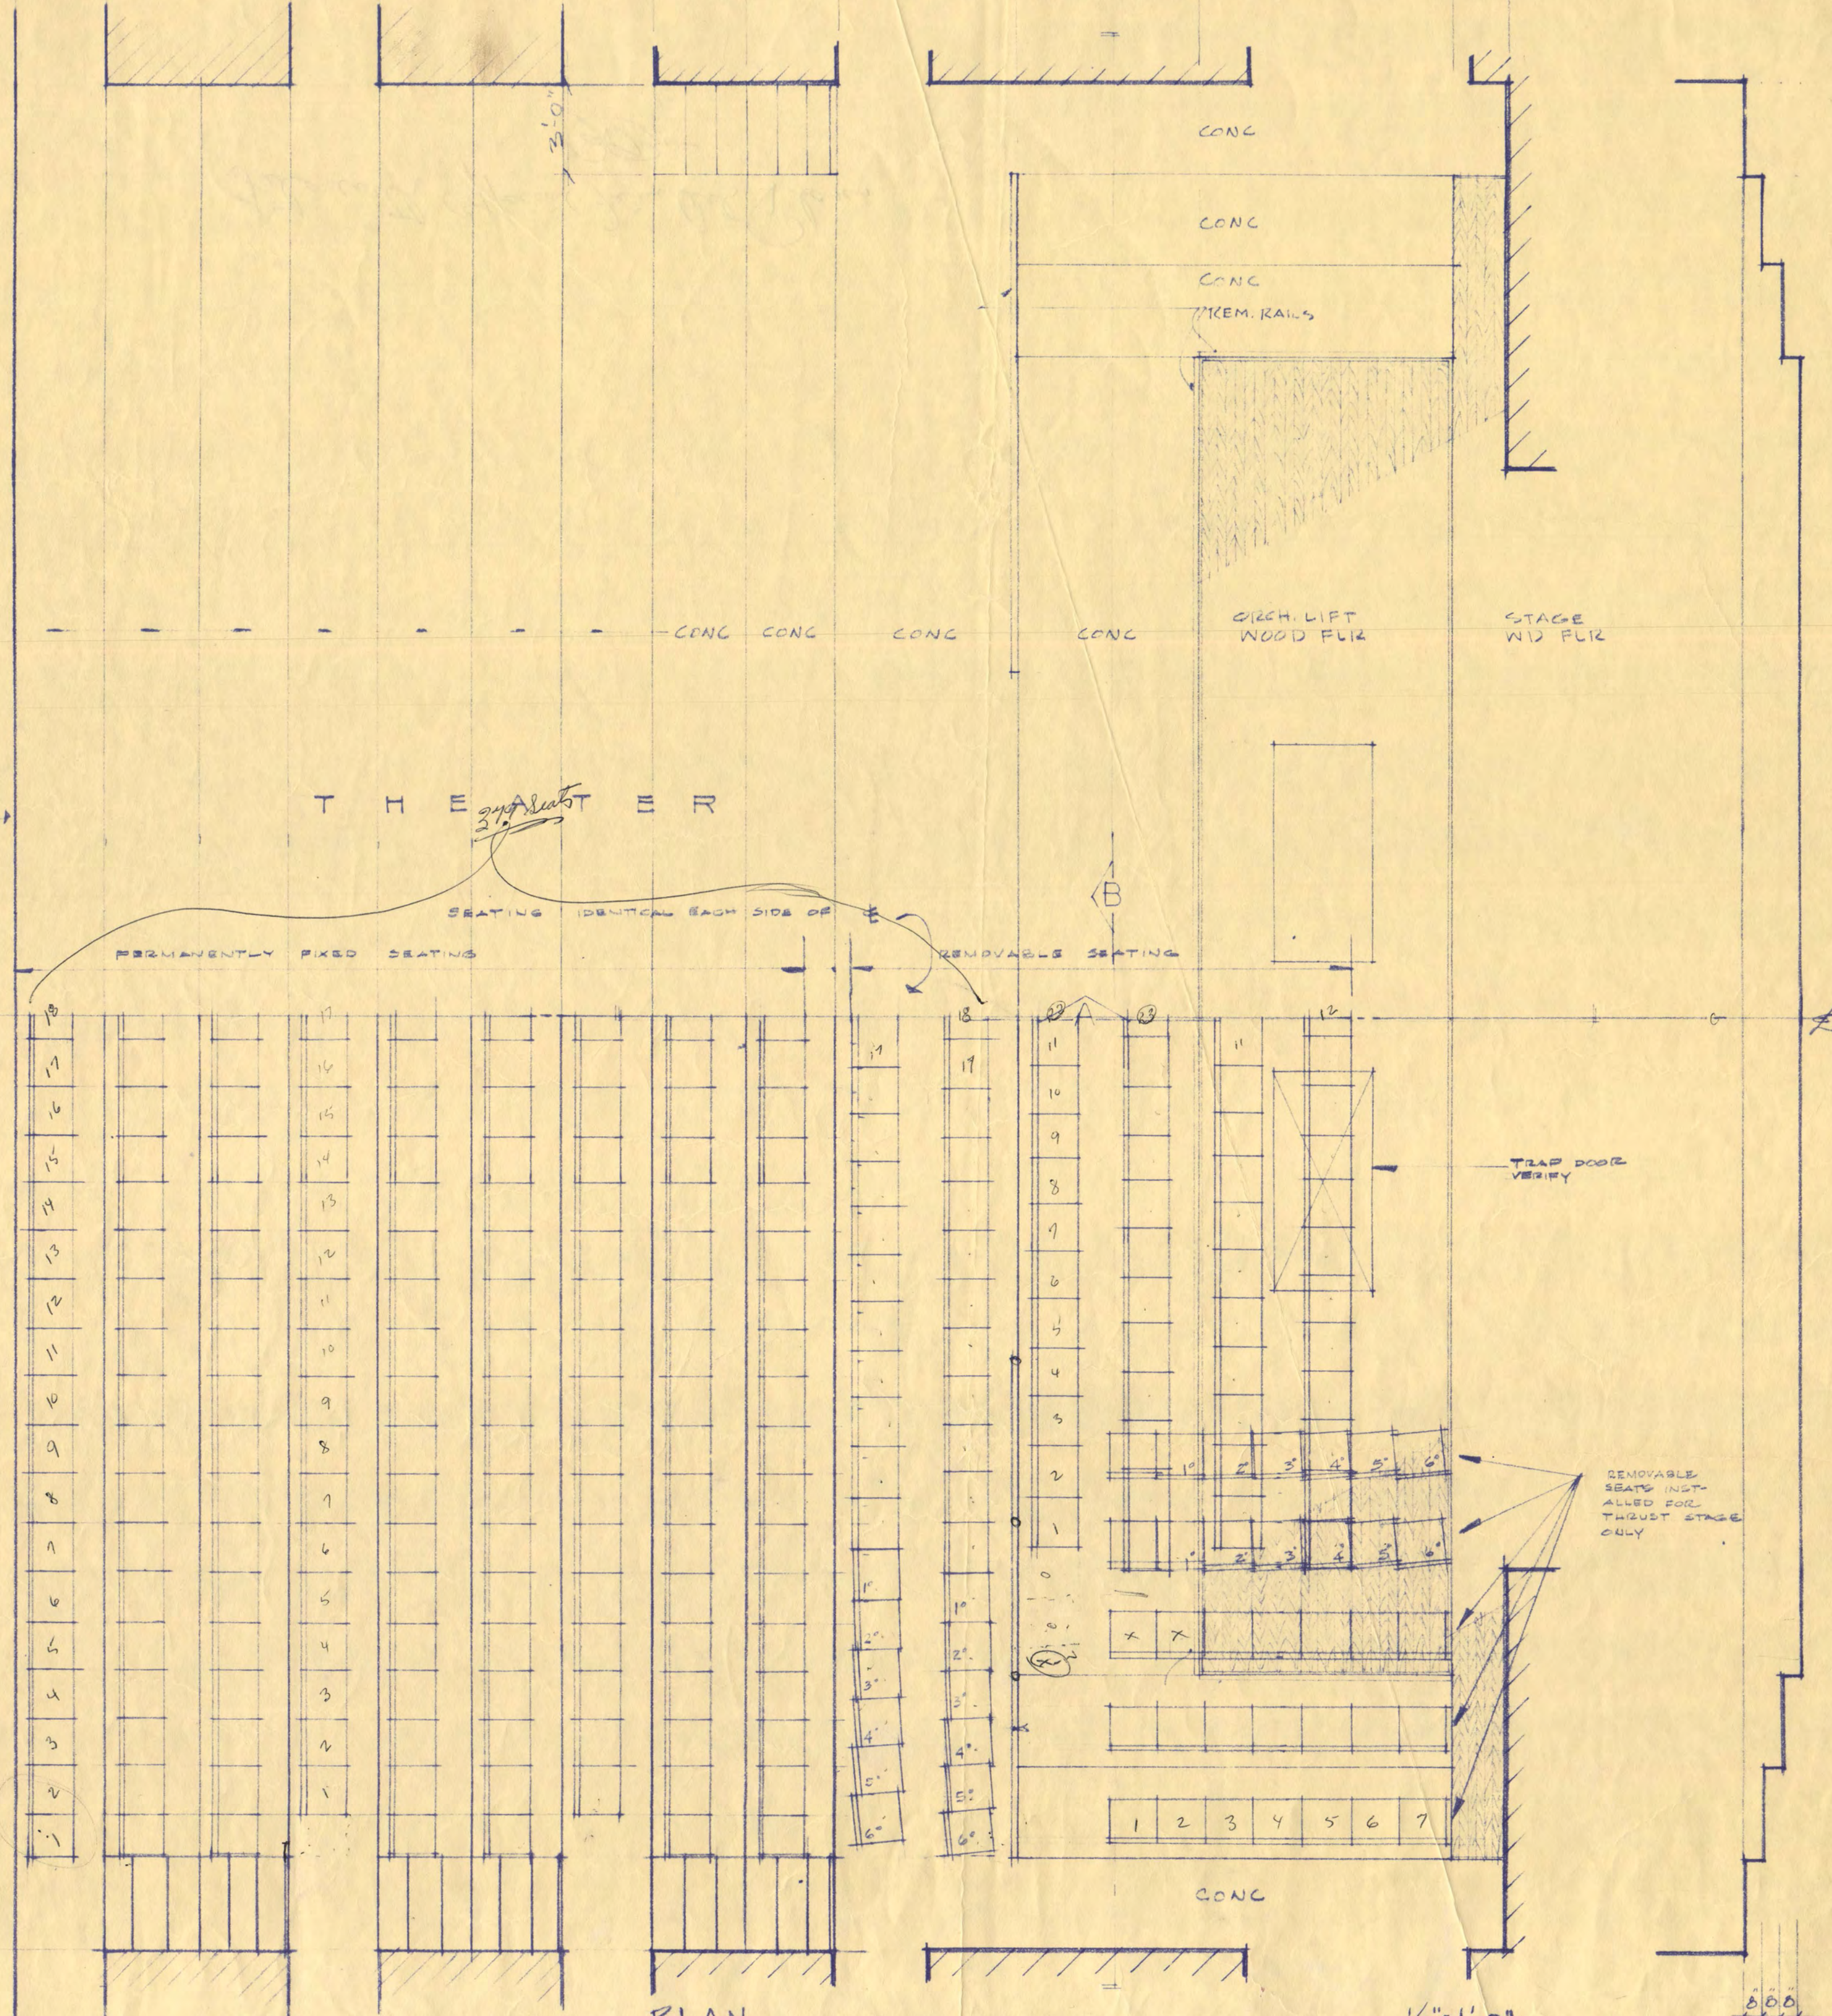

T H E A T E R

SEAT WALL OF MAIN HOUSE REFER TO ARCHITECTURAL WORKING DRAWINGS



SEATING IDENTICAL EACH SIDE OF

PERMANENTLY FIXED SEATING

REMOVABLE SEATING

NOTES

- SEATING ARRANGEMENT SYMMETRICAL ABOUT C OF THEATER
- THEATER SEAT MANUFACTURER
- DESIGNER FOR LOCATION OF SEATS FOR REMOVABLE SEATS; SEATING; CUSHIONING; SEAT ANGLE ETC.
- ALL CONDITIONS VERIFIED AT SITE
- REFER TO CODE SCHEDULE

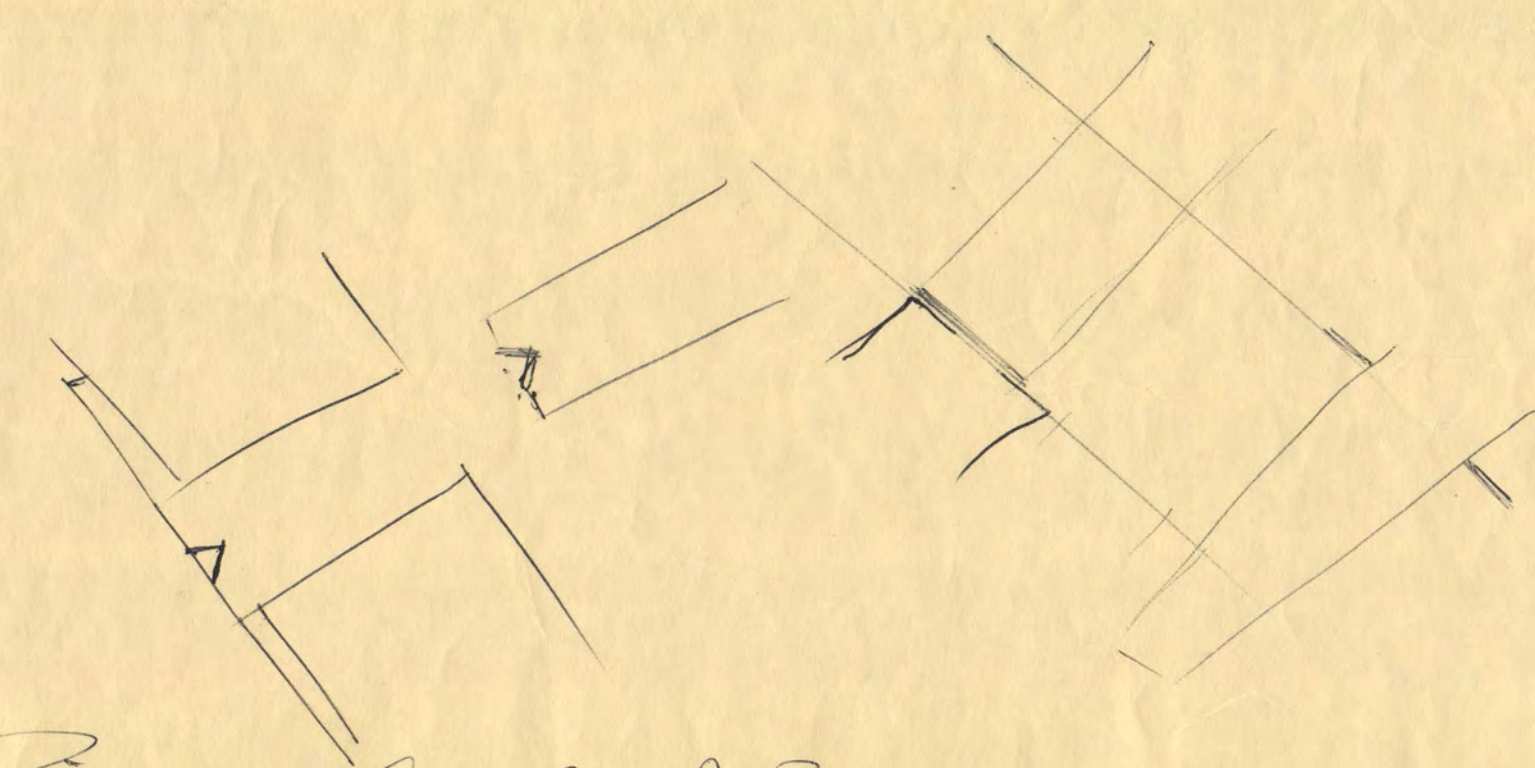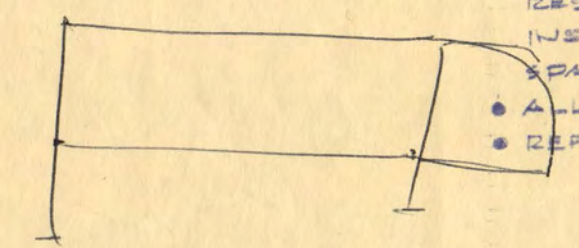

Reviewed by Art, Ruth & J. P. on plan 22, 1967 & OK as noted.

1. Watch installation of 5' x 6' seats so we have enough walking space in last row.

2. My comment was get in 2 rows seats.

3. Ok space x

4. Color groups @ seat

449 Seat for thrust
470 Seat for Per (Not incl side seats)

THEATER SEATING LAYOUT


FINE ARTS BUILDING - ST. CLOUD STATE COLLEGE 17-67 - 31

ELEV. A

ELEV. B

NOTES:

1. ALL PARTITIONS TO EXTEND TO FLOOR OR ROOF CONSTRUCTION ABOVE.
2. COORDINATE WITH MECHANICAL CONTRACTOR FOR ALL REQUIRED WALL OPENINGS.

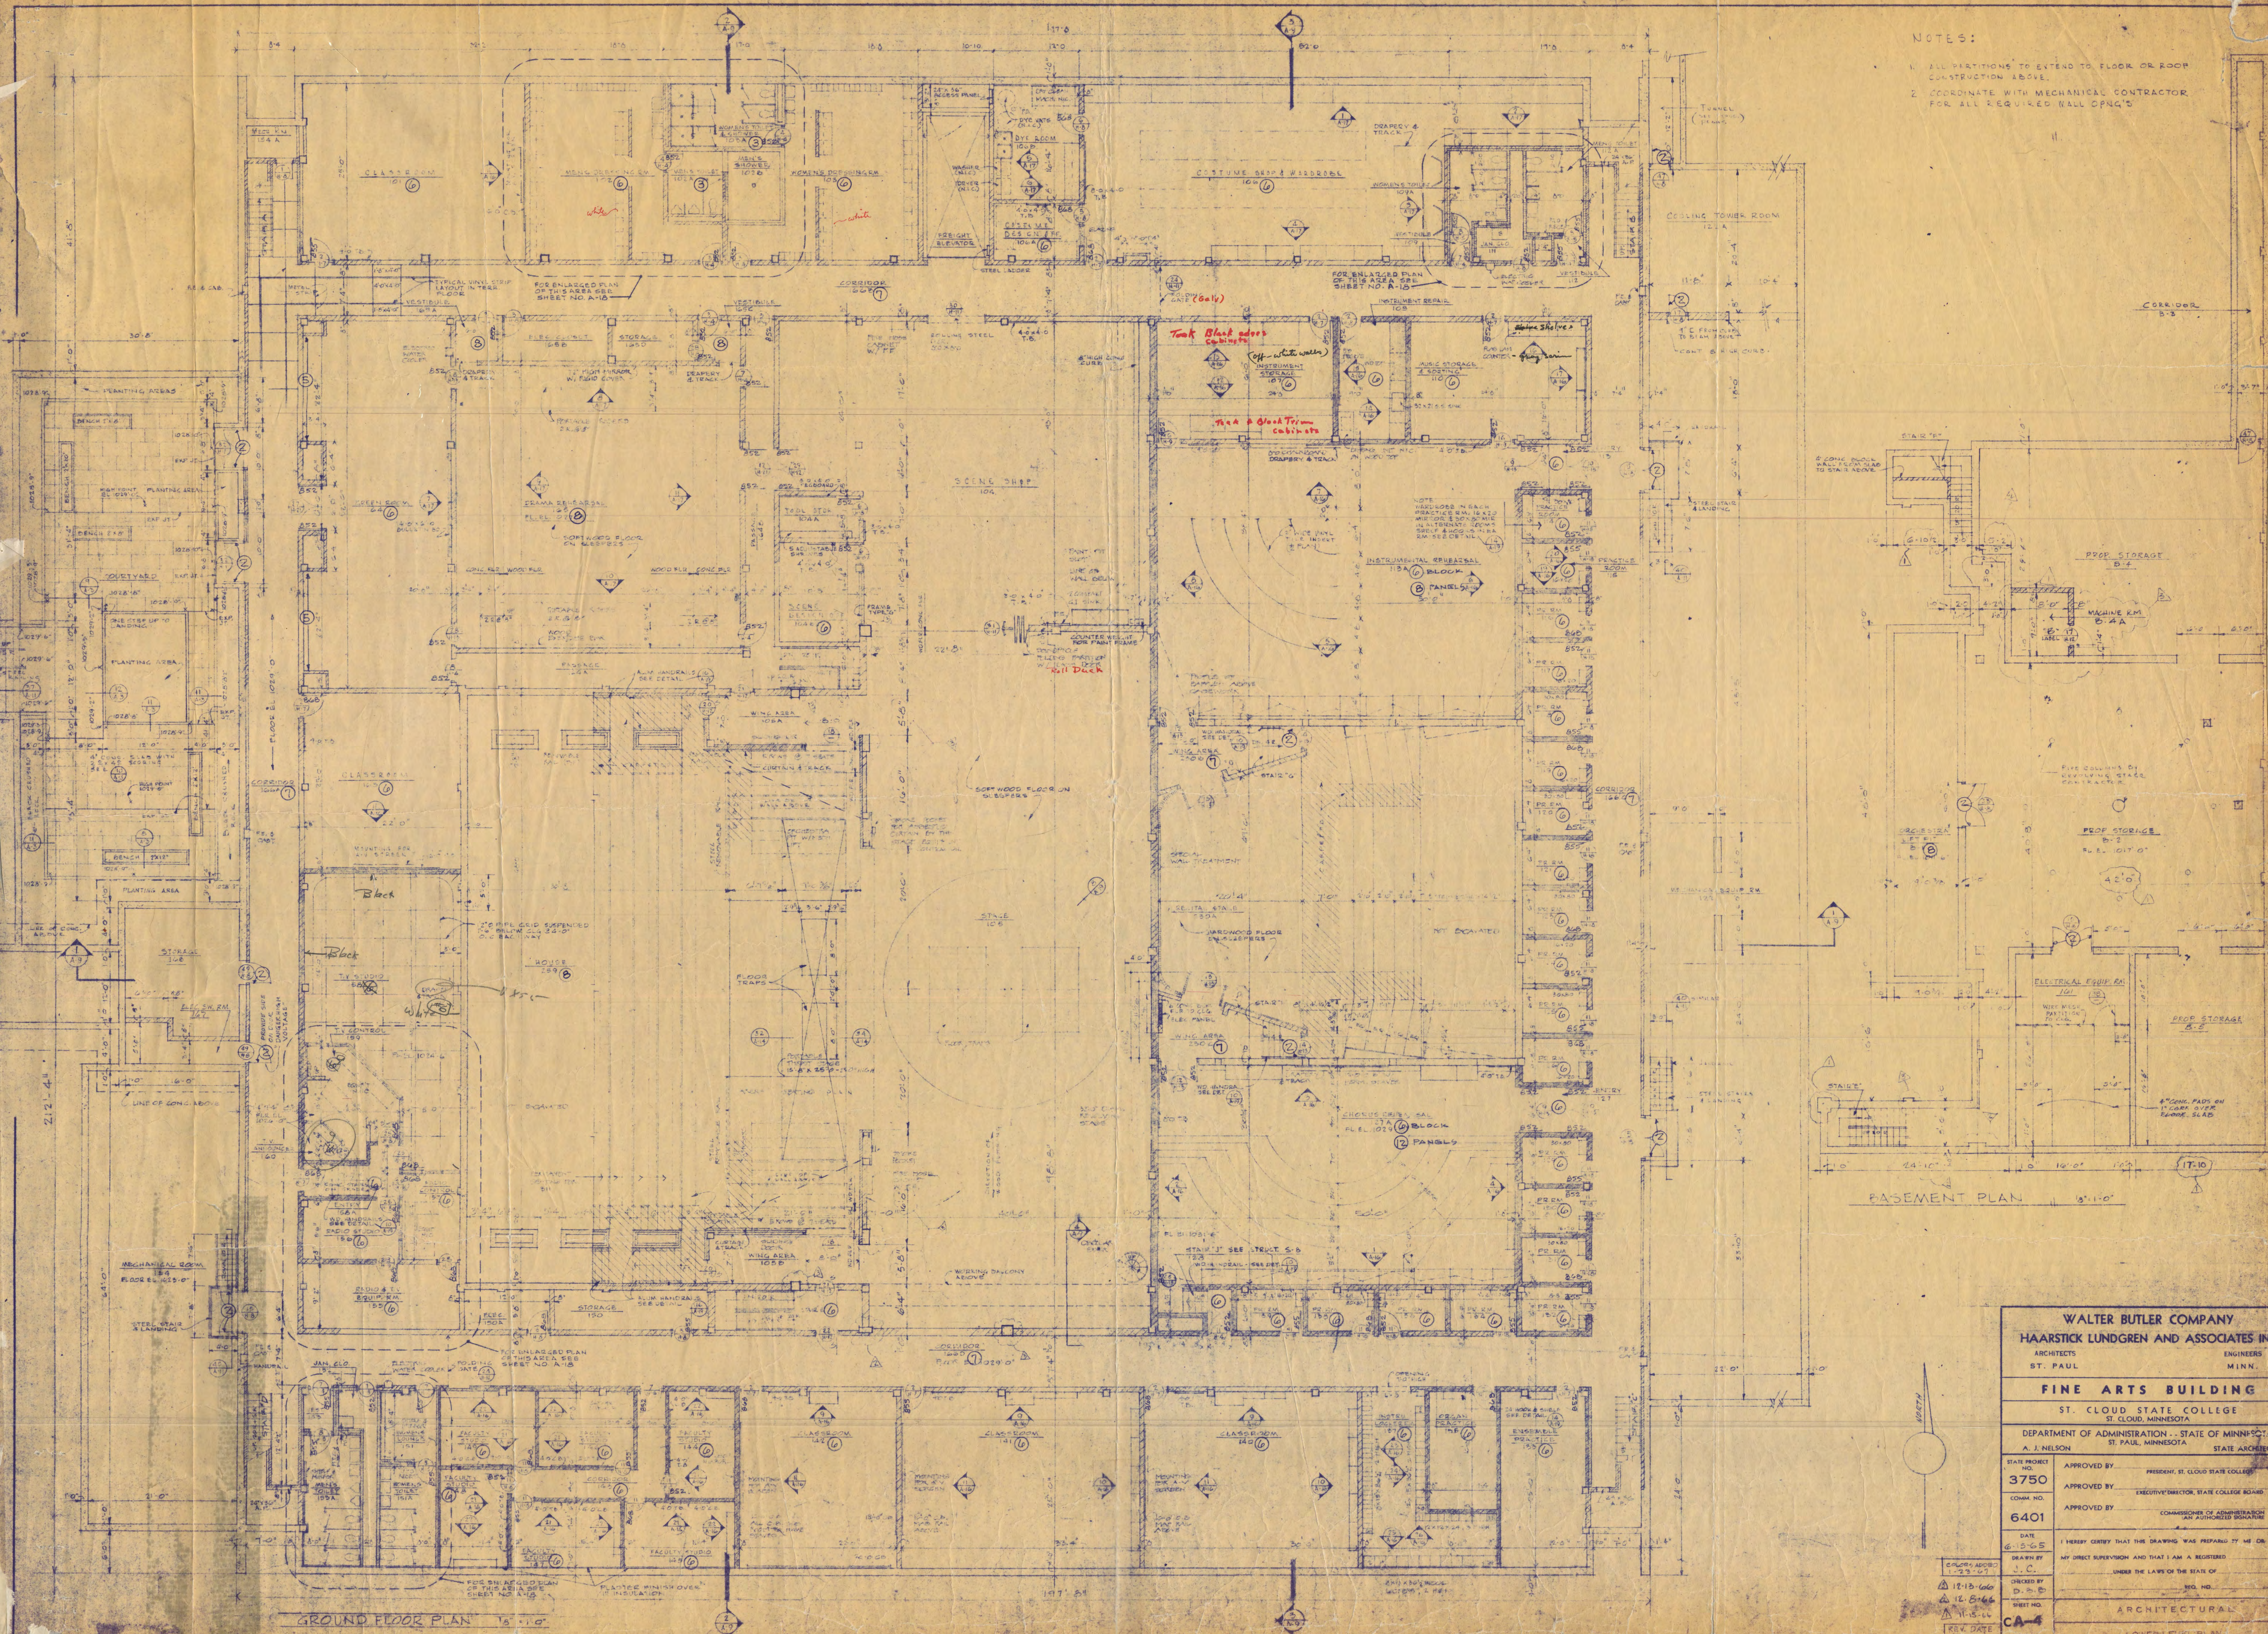




GROUND FLOOR PLAN 1/8" = 1'-0"

BASEMENT PLAN 1/8" = 1'-0"

WALTER BUTLER COMPANY
 HAARSTICK LUNDGREN AND ASSOCIATES INC.
 ARCHITECTS ST. PAUL ENGINEERS MINN.
FINE ARTS BUILDING
 ST. CLOUD STATE COLLEGE
 ST. CLOUD, MINNESOTA
 DEPARTMENT OF ADMINISTRATION - STATE OF MINNESOTA
 A. J. NELSON STATE ARCHITECT

STATE PROJECT NO. 3750	APPROVED BY PRESIDENT, ST. CLOUD STATE COLLEGE
COMM. NO. 6401	APPROVED BY EXECUTIVE DIRECTOR, STATE COLLEGE BOARD
DATE 6-23-55	APPROVED BY COMMISSIONER OF ADMINISTRATION AND AUTHORIZED SIGNATURE
DRAWN BY J.C.	MY DIRECT SUPERVISION AND THAT I AM A REGISTERED ARCHITECT UNDER THE LAWS OF THE STATE OF MINN.
CHECKED BY D.P.B.	REV. DATE 3-25-55
DATE 12-15-60	
DATE 12-8-66	
DATE 11-15-66	
DATE 3-25-55	

ARCHITECTURAL
 LOWER LEVEL PLAN

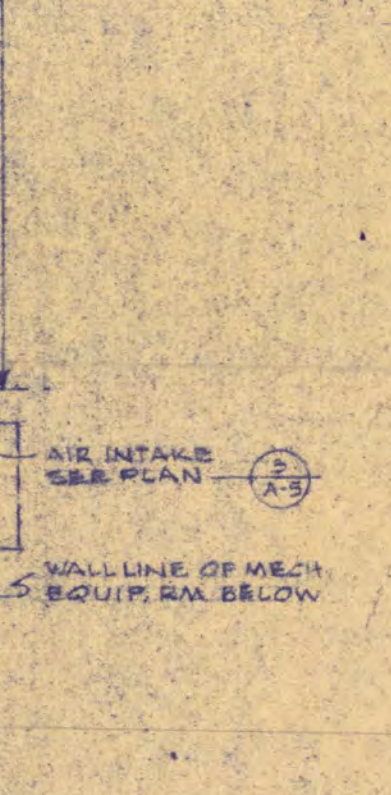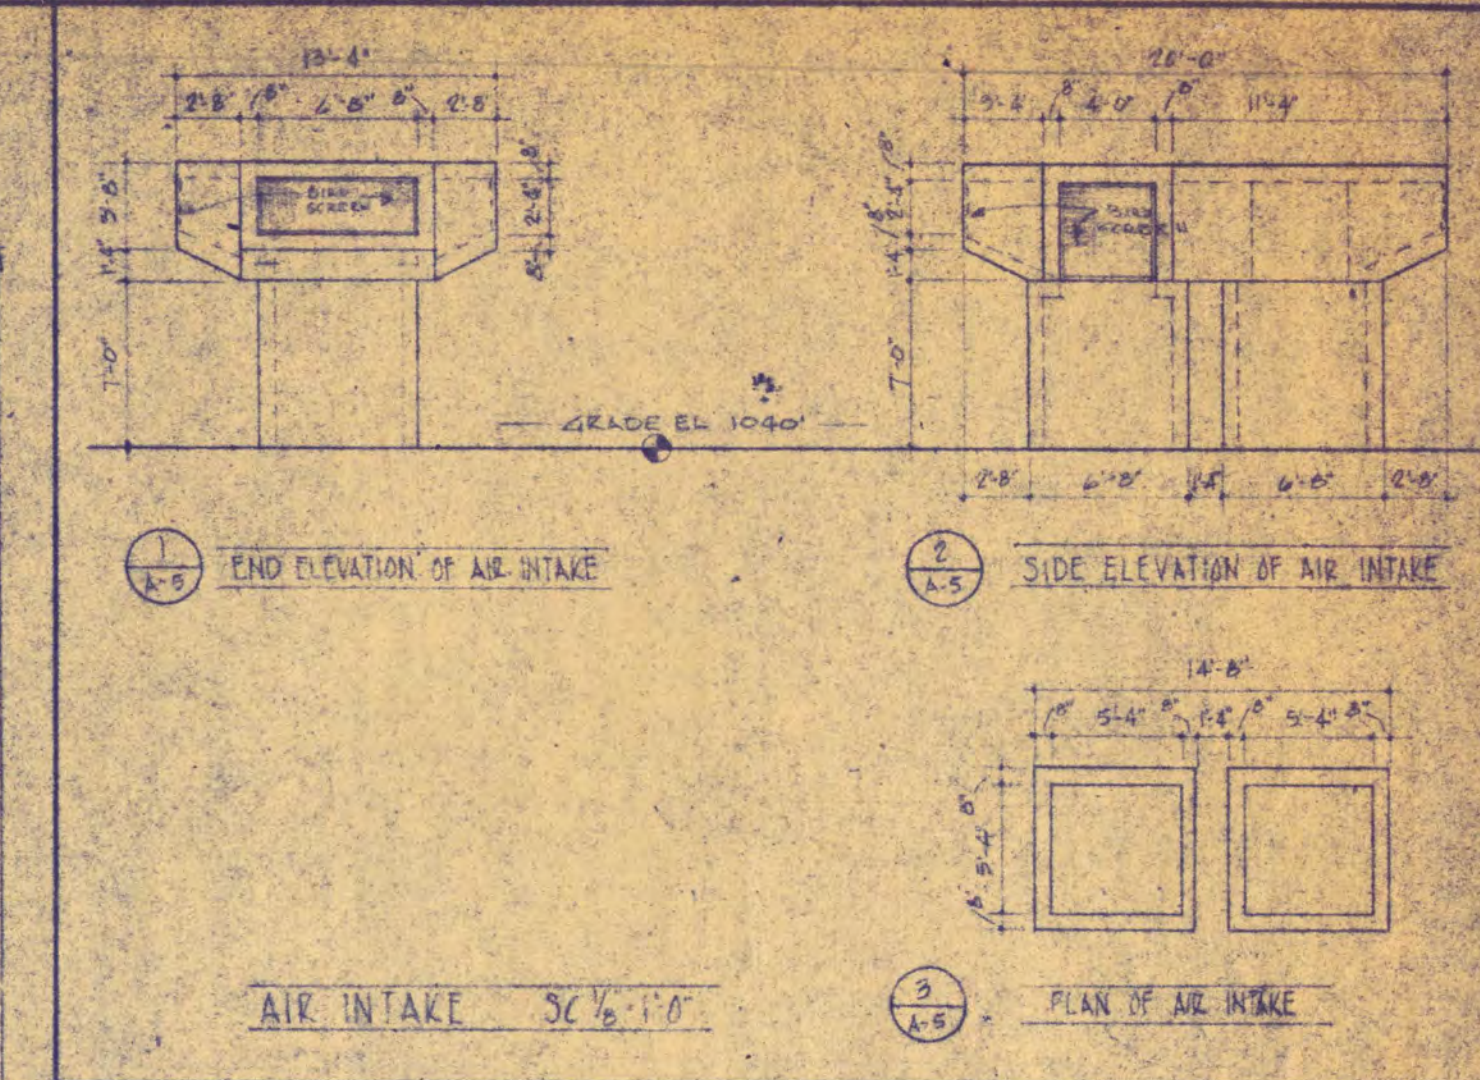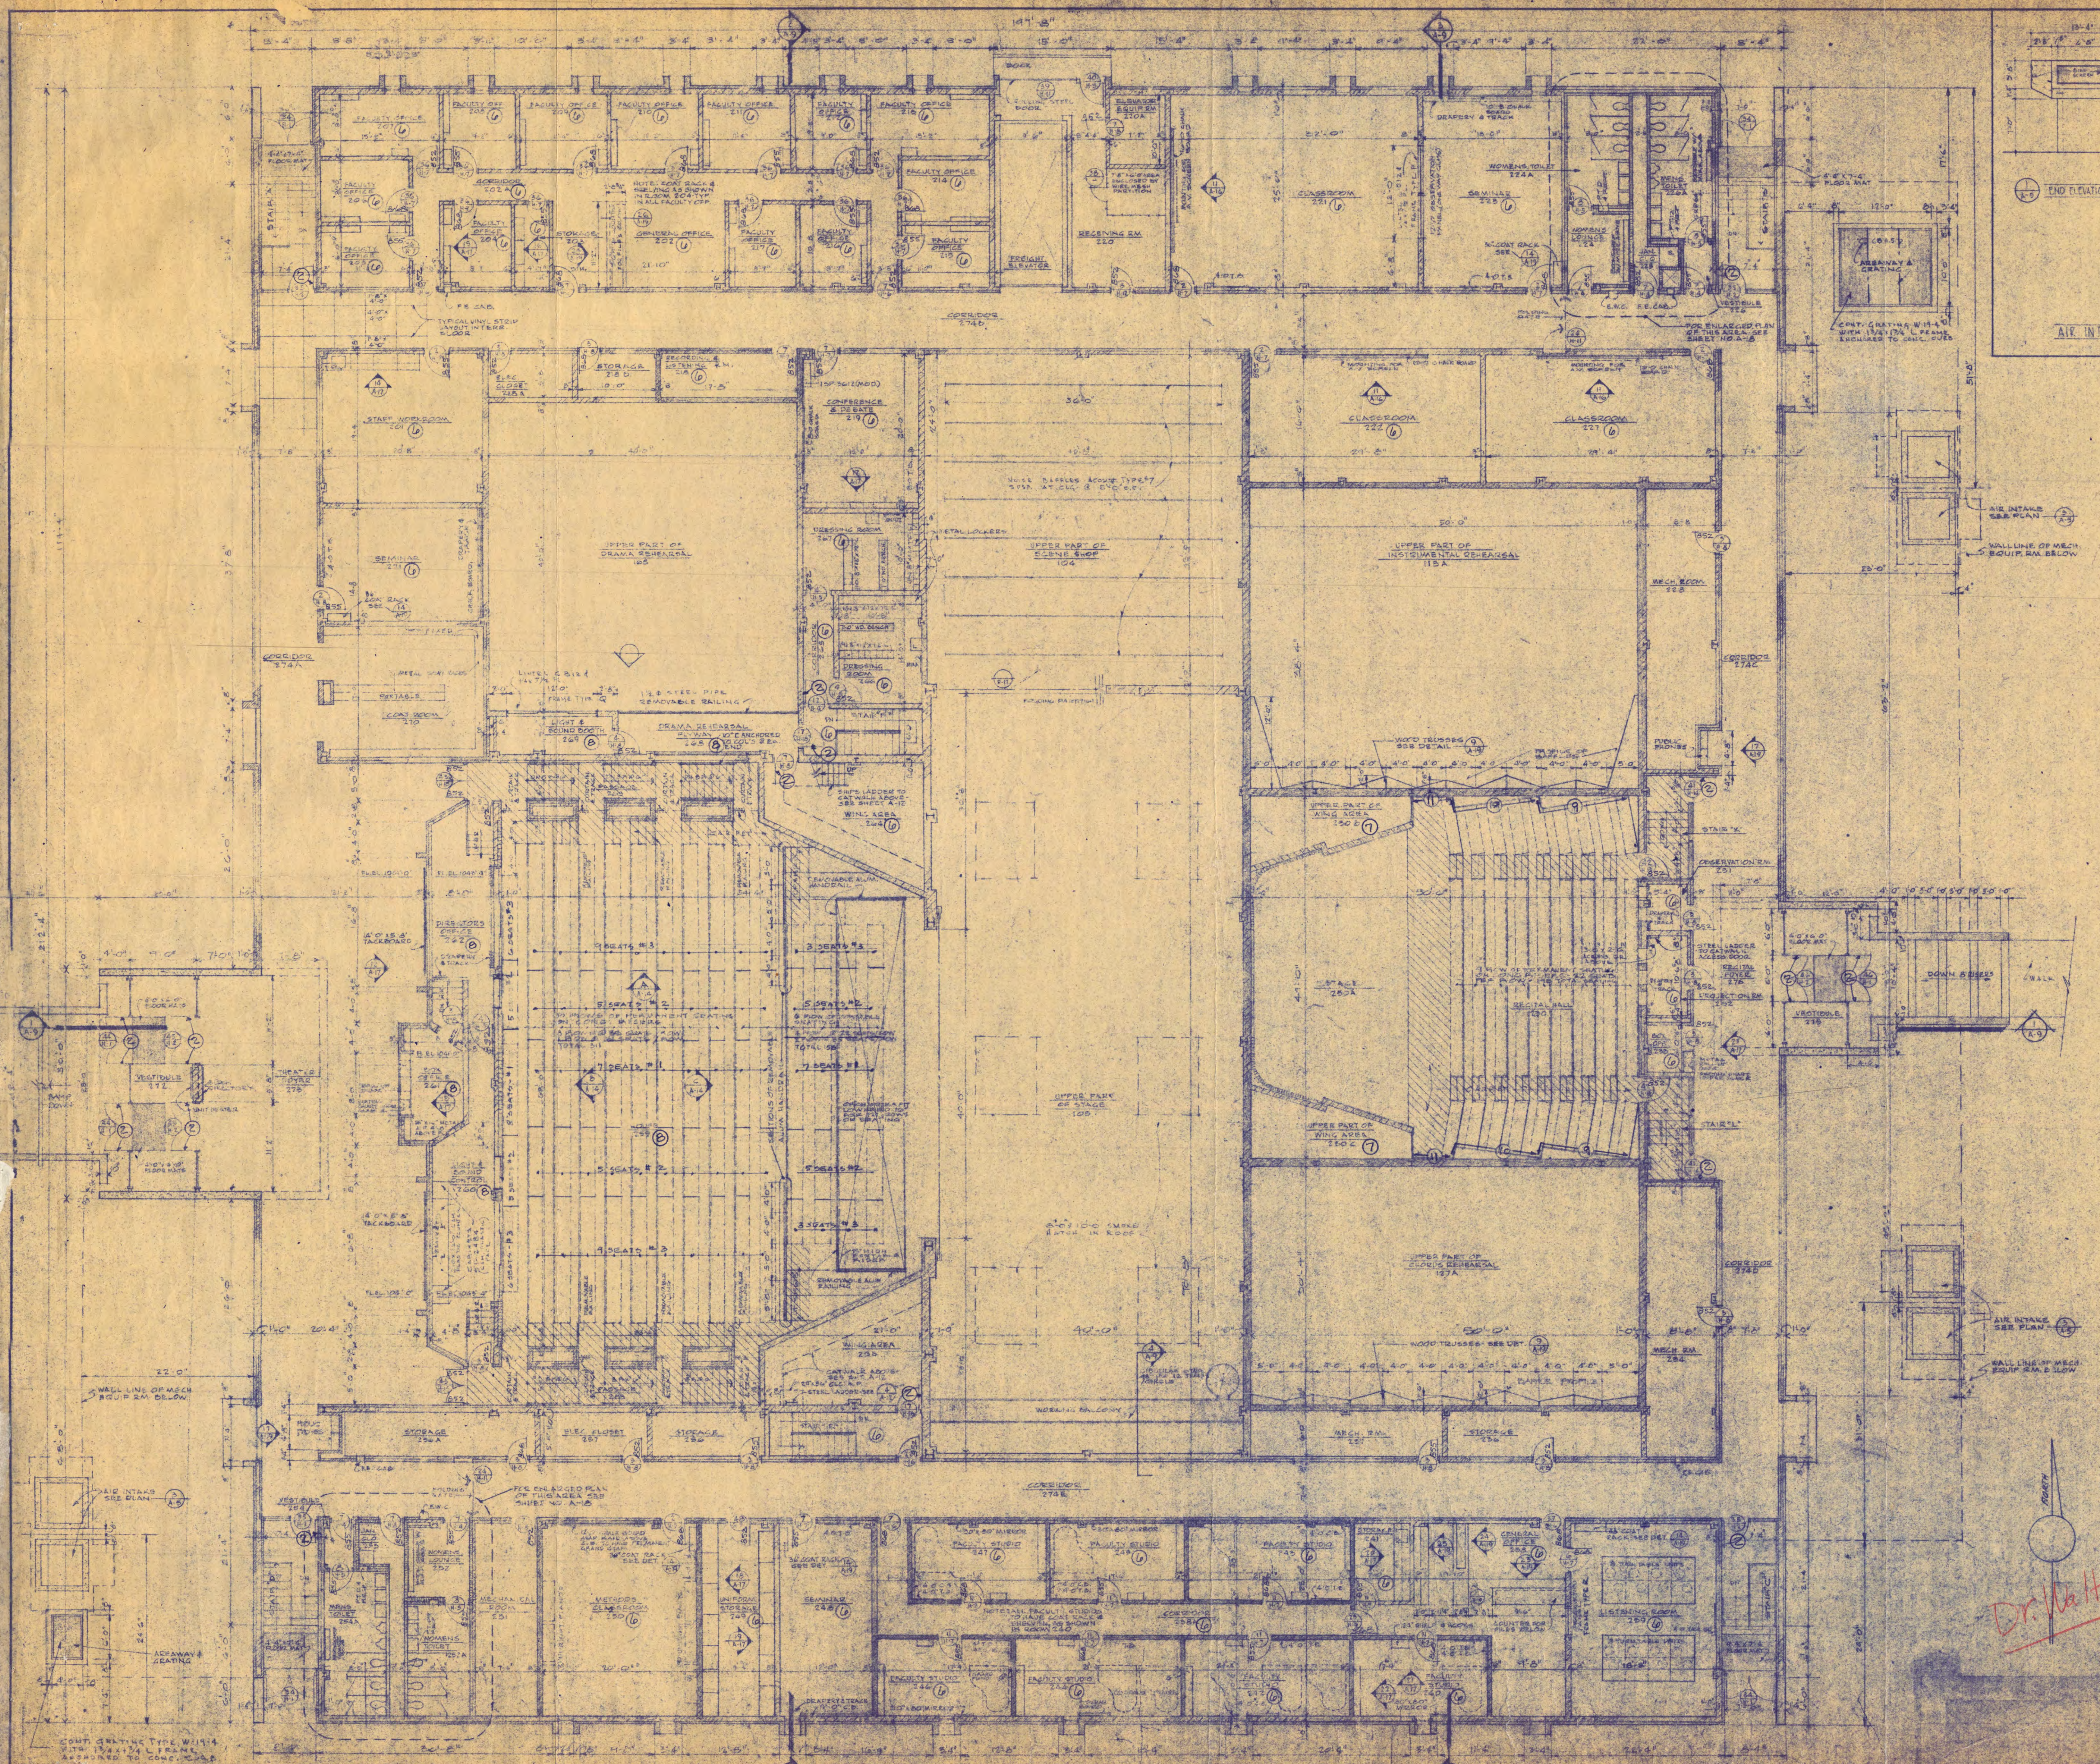

WALTER BUTLER COMPANY HAARSTICK LUNDGREN AND ASSOCIATES INC. ARCHITECTS ST. PAUL, MINN.	
FINE ARTS BUILDING ST. CLOUD STATE COLLEGE ST. CLOUD, MINNESOTA DEPARTMENT OF ADMINISTRATION - STATE OF MINNESOTA A. J. NELSON STATE ARCHITECT	
STATE PROJECT NO. 3750	APPROVED BY PRESIDENT, ST. CLOUD STATE COLLEGE
COMM. NO. 6401	APPROVED BY EXECUTIVE DIRECTOR, STATE COLLEGE BOARD
DATE 6-15-35	APPROVED BY COMMISSIONER OF ADMINISTRATION STATE OF MINNESOTA
DRAWN BY J.P.F.	I HEREBY CERTIFY THAT THIS DRAWING WAS PREPARED BY ME OR BY ONE OF MY ASSISTANTS UNDER MY SUPERVISION AND THAT I AM A REGISTERED ARCHITECT UNDER THE LAWS OF THE STATE OF MINNESOTA.
CHECKED BY A.P.	ARCHITECTURAL
SHEET NO. CA-15	

Dr. Walton

COUNT GRATING TYPE WITH 1/4" x 1/4" x 1/4" L. FRAME ATTACHED TO CONCRETE

FIRST FLOOR PLAN 1/8" = 1'-0"

