
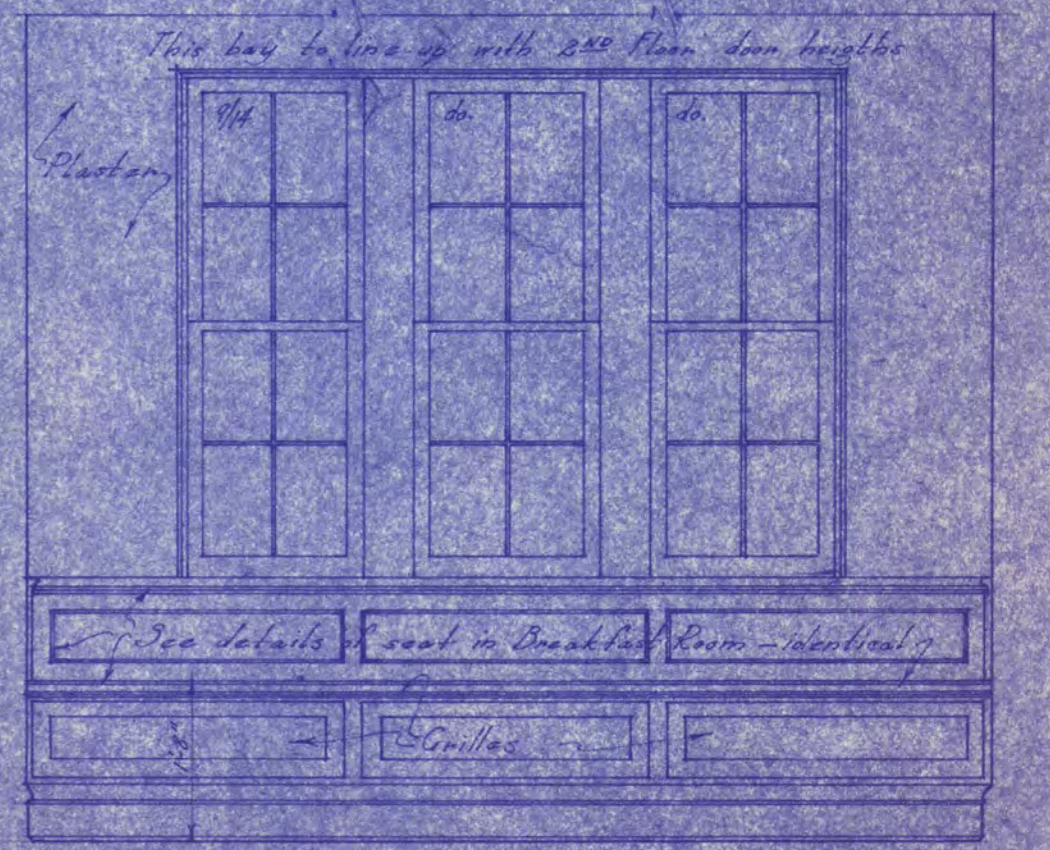
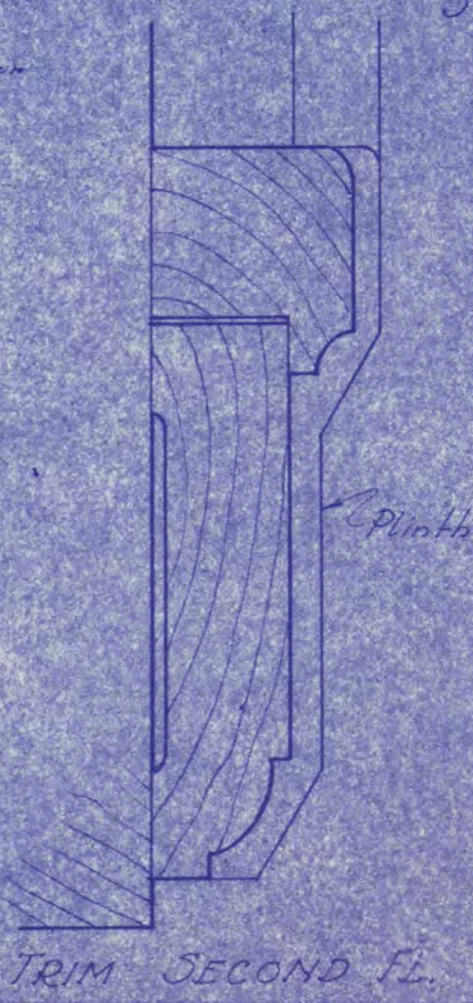
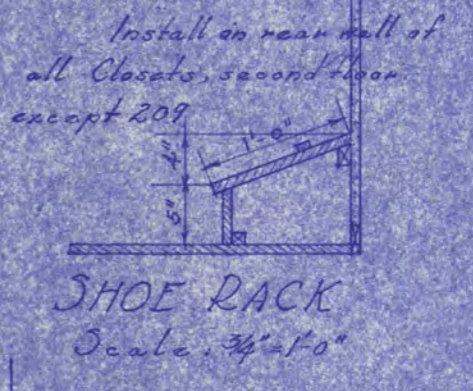


DOOR SCHEDULE Second Floor

No.	Type	Size	Description
6	J	2'-4 1/2" x 6'-8 1/4"	1 Panel
1	K	2'-4 1/2" x 6'-0 1/4"	" "
3	L	2'-4 1/2" x 6'-8 1/4"	" "
1	M	2'-4 1/2" x 6'-8 1/4"	Gl. 4 Lts.
5	N	2'-2 1/2" x 6'-8 1/4"	1 Panel
2	O	1'-8 1/2" x 1'-8 1/4"	1 Panel Access plug door


DETAIL OF DORMER-BEDROOM Scale: 1/2"=1'-0"

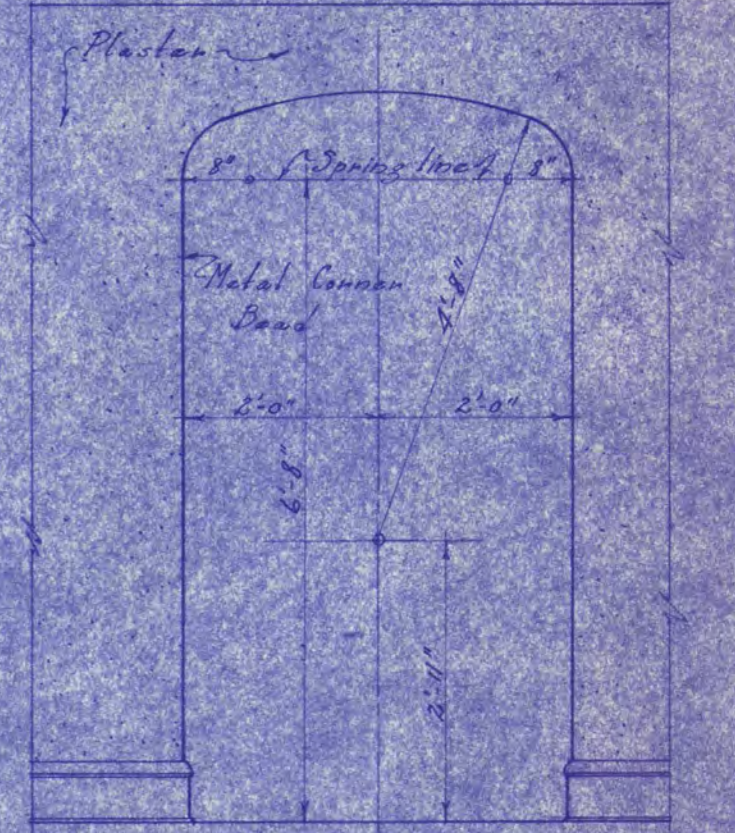

SECOND FLOOR PLAN Scale: 1/8"=1'-0"

RESIDENCE  
FOR  
DR. C. B. LEWIS  
ST. CLOUD MINN.

LOUIS C. PINAULT ARCHITECT  
ST. CLOUD MINN.  
DRAWING NO. 136 B-7  
DATE OCT. 7, 1925

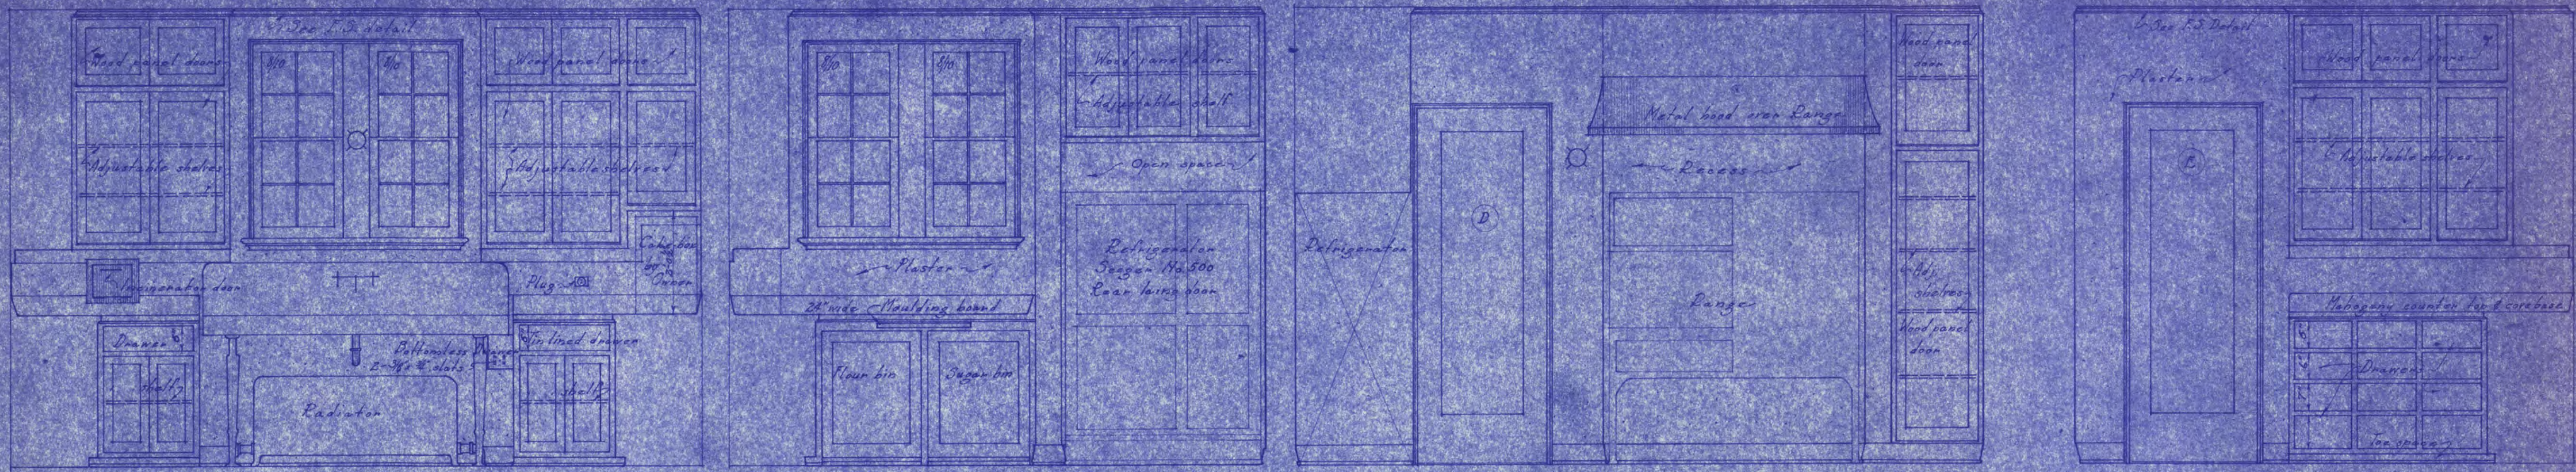


NORTH WALL

EAST WALL

SOUTH WALL

WEST WALL

KITCHEN CUPBOARD DETAILS Additional Cupboard Details on sheet B-2

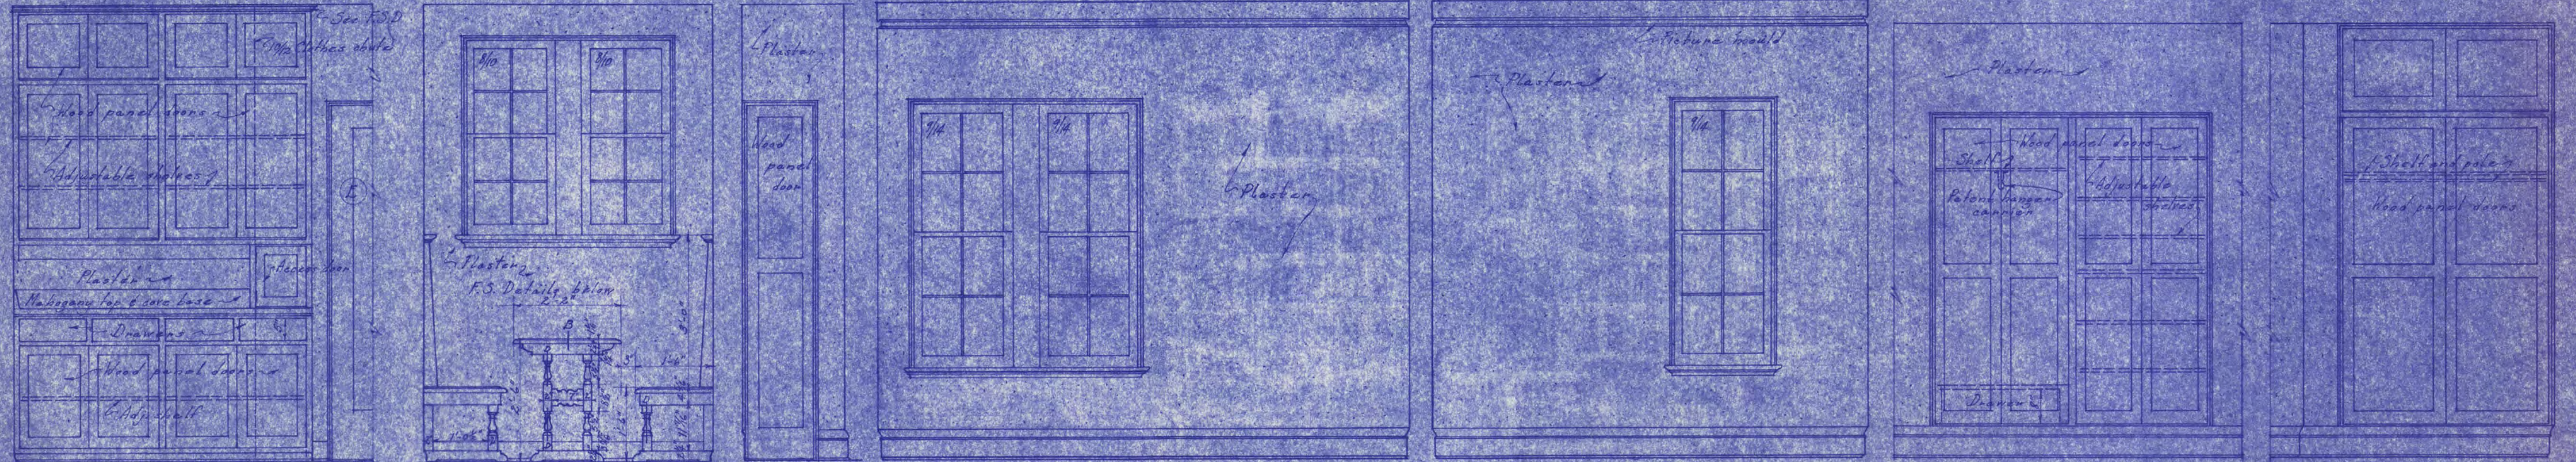

WEST WALL

NORTH WALL

CLOSET IN REAR VESTIBULE 105


EAST WALL

SOUTH WALL

WARDROBE & LINEN CLOSET IN UPPER HALL 201

WARDROBE IN ROOM 203

BREAKFAST ROOM DETAILS

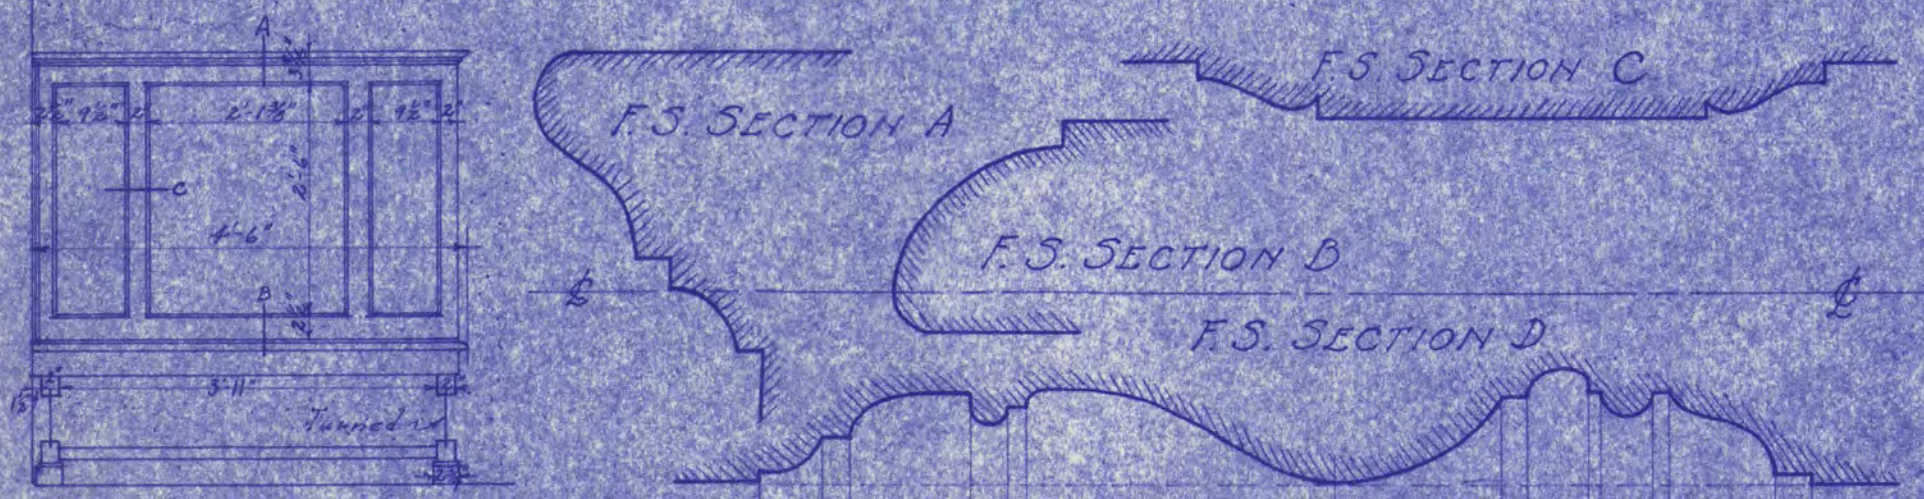

FRONT ELEVATION OF SEAT

F.S. SECTION A


F.S. SECTION C

F.S. SECTION B

F.S. SECTION D

F.S.D. PICTURE MOULD

F.S.D. STOOL & APRON

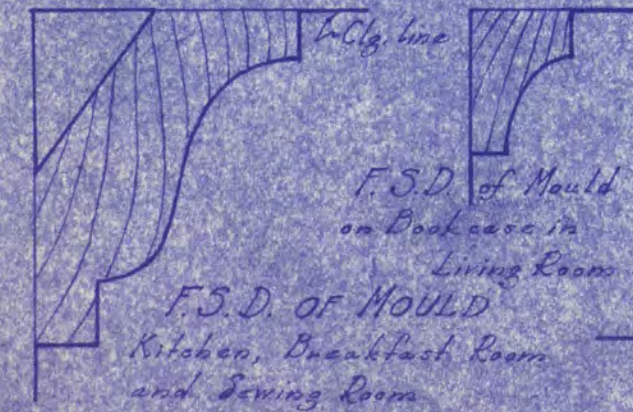

F.S.D. of Mould on Bookcase in Living Room etc.

F.S.D. of Mould in Kitchen, Breakfast Room and Dining Room

F.S.D. OF BASE



F.S.D. GLAZED DOORS BOOKCASES IN DEN



WARDROBES - ROOM 205






SECTION LINEN CLOSET 209

ELEVATION LINEN CLOSET 209

NOTE: DETAILS ON THIS SHEET ARE 1/4 INCH SCALE UNLESS OTHERWISE NOTED

RESIDENCE FOR DR. C. B. LEWIS ST. CLOUD MINN.


LOUIS C. PINAULT ARCHITECT ST. CLOUD MINN. DRAWING NO. 138 B-8 DATE OCT. 7, 1925

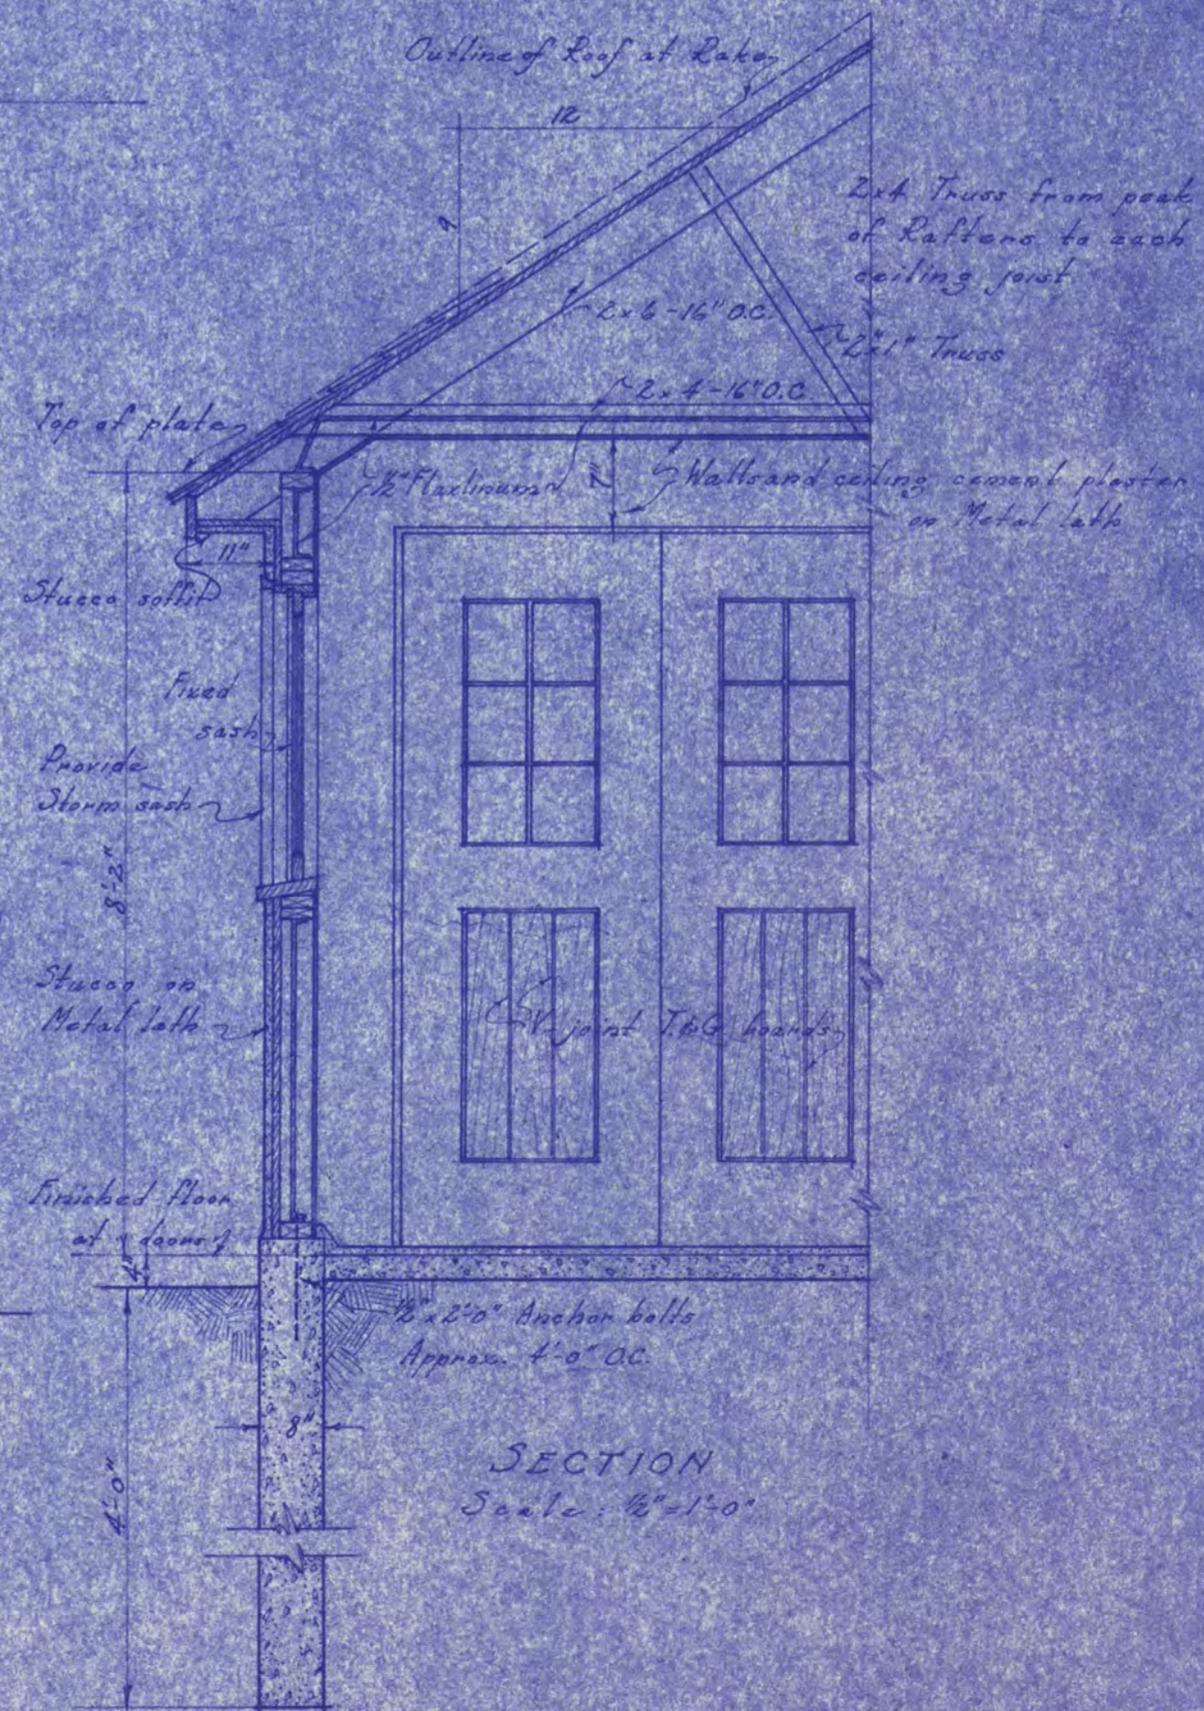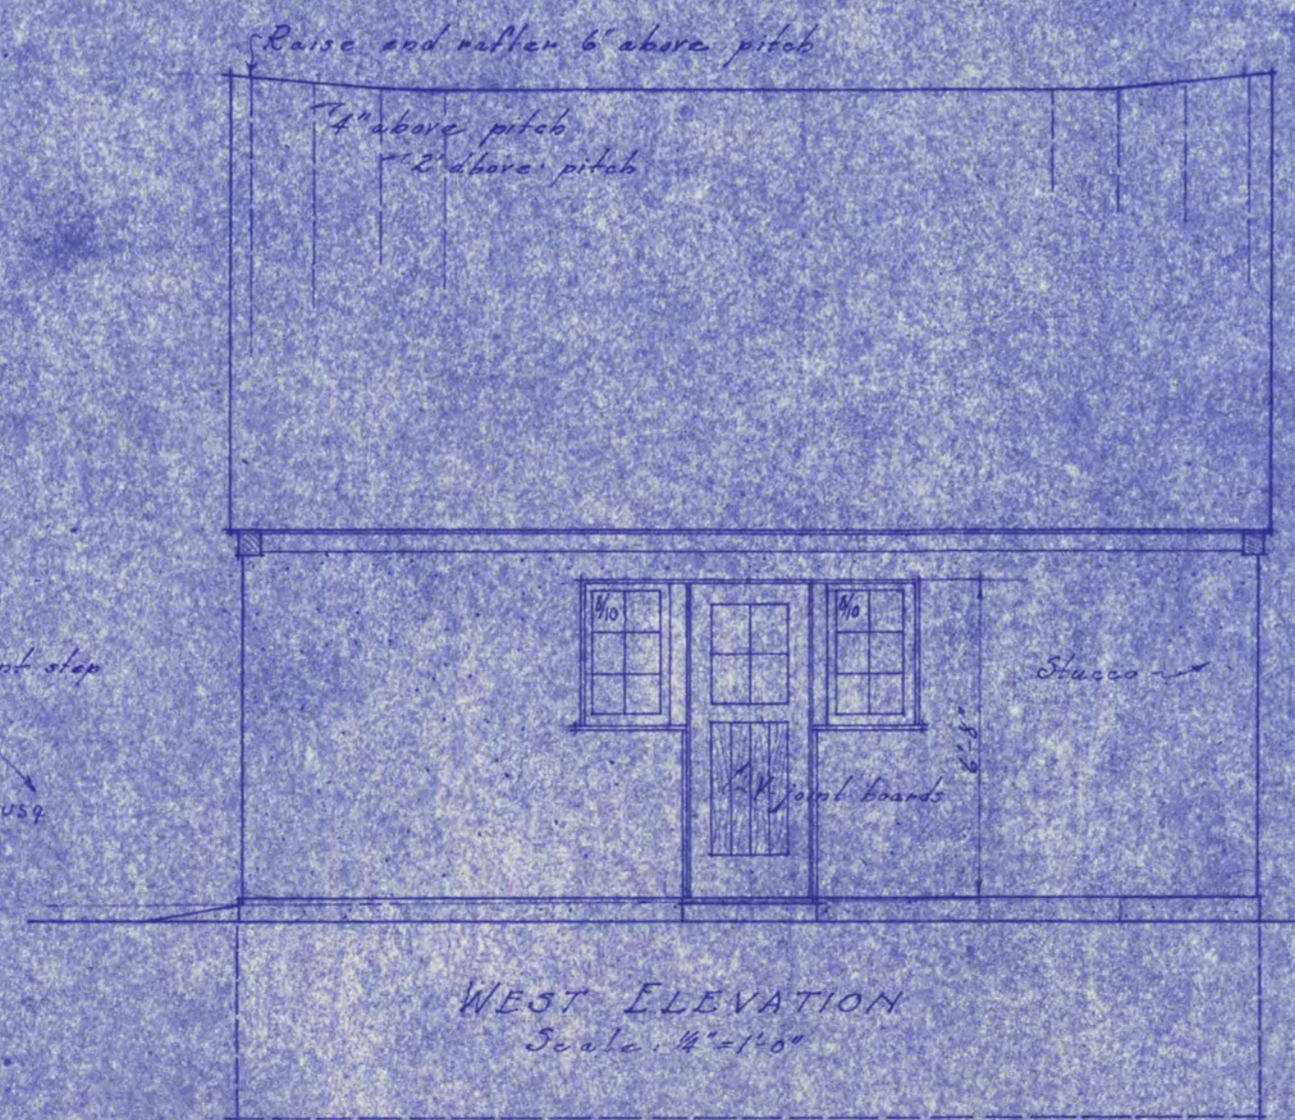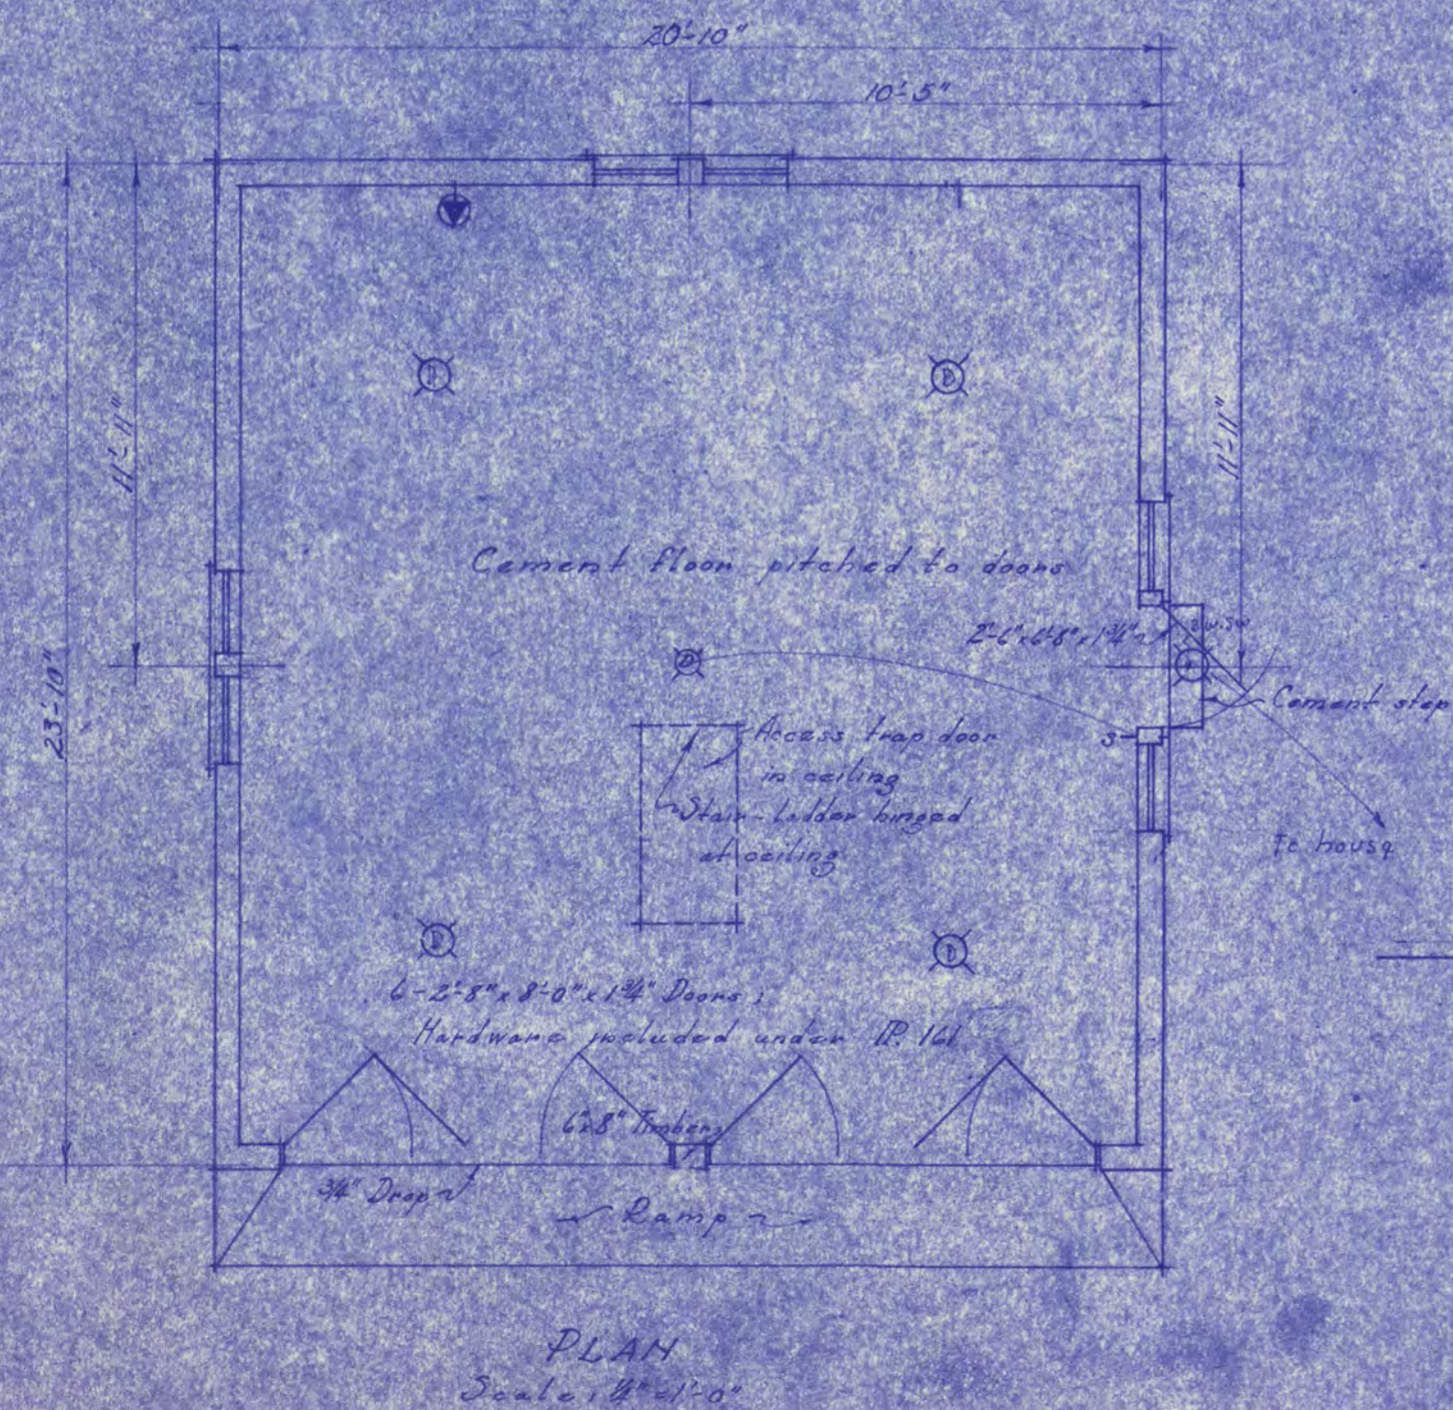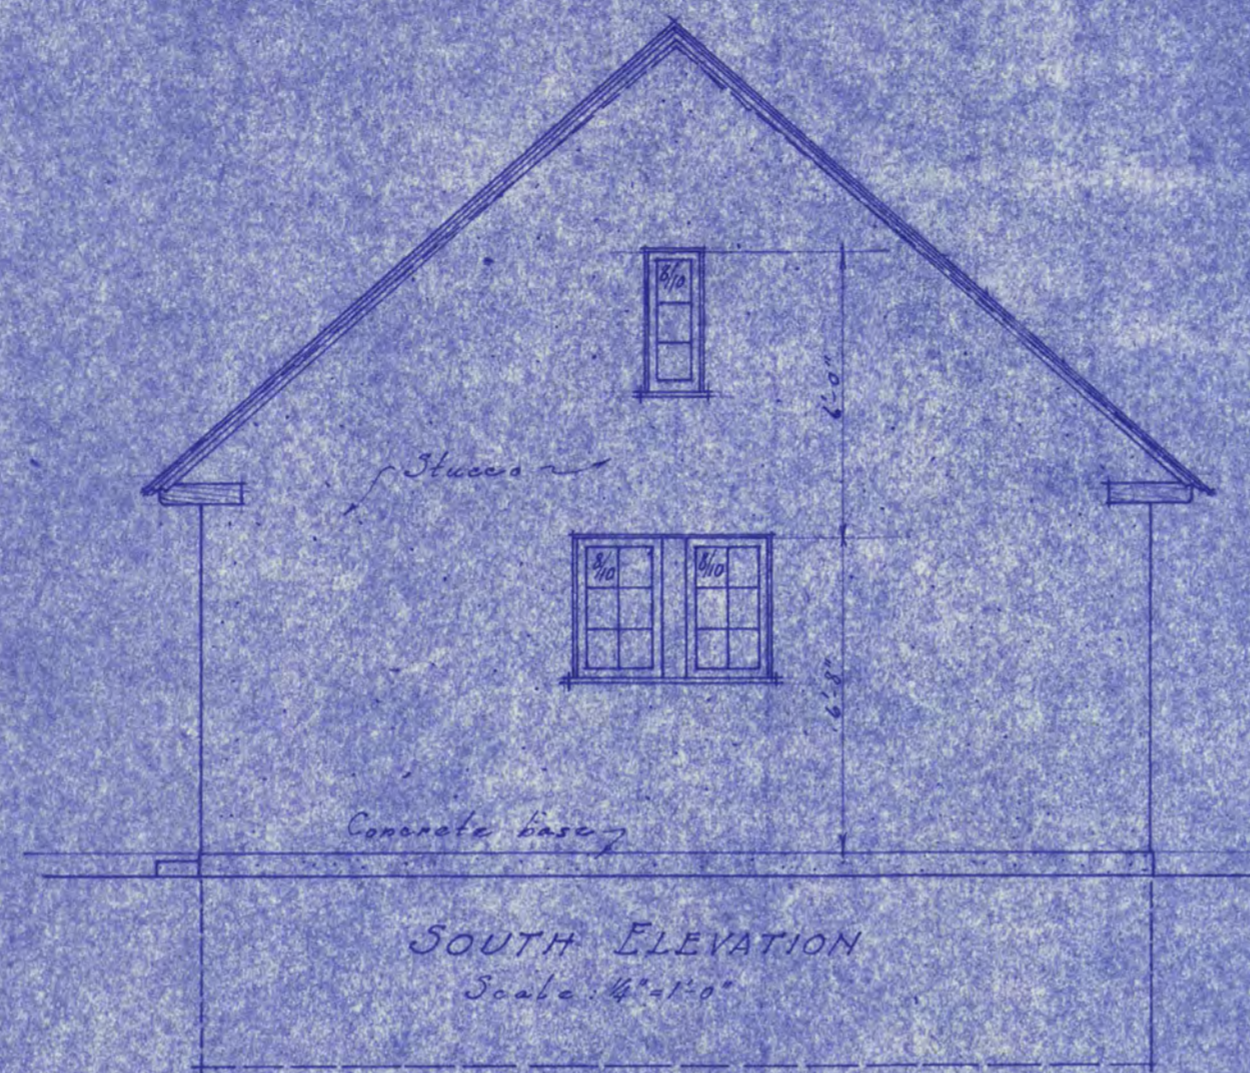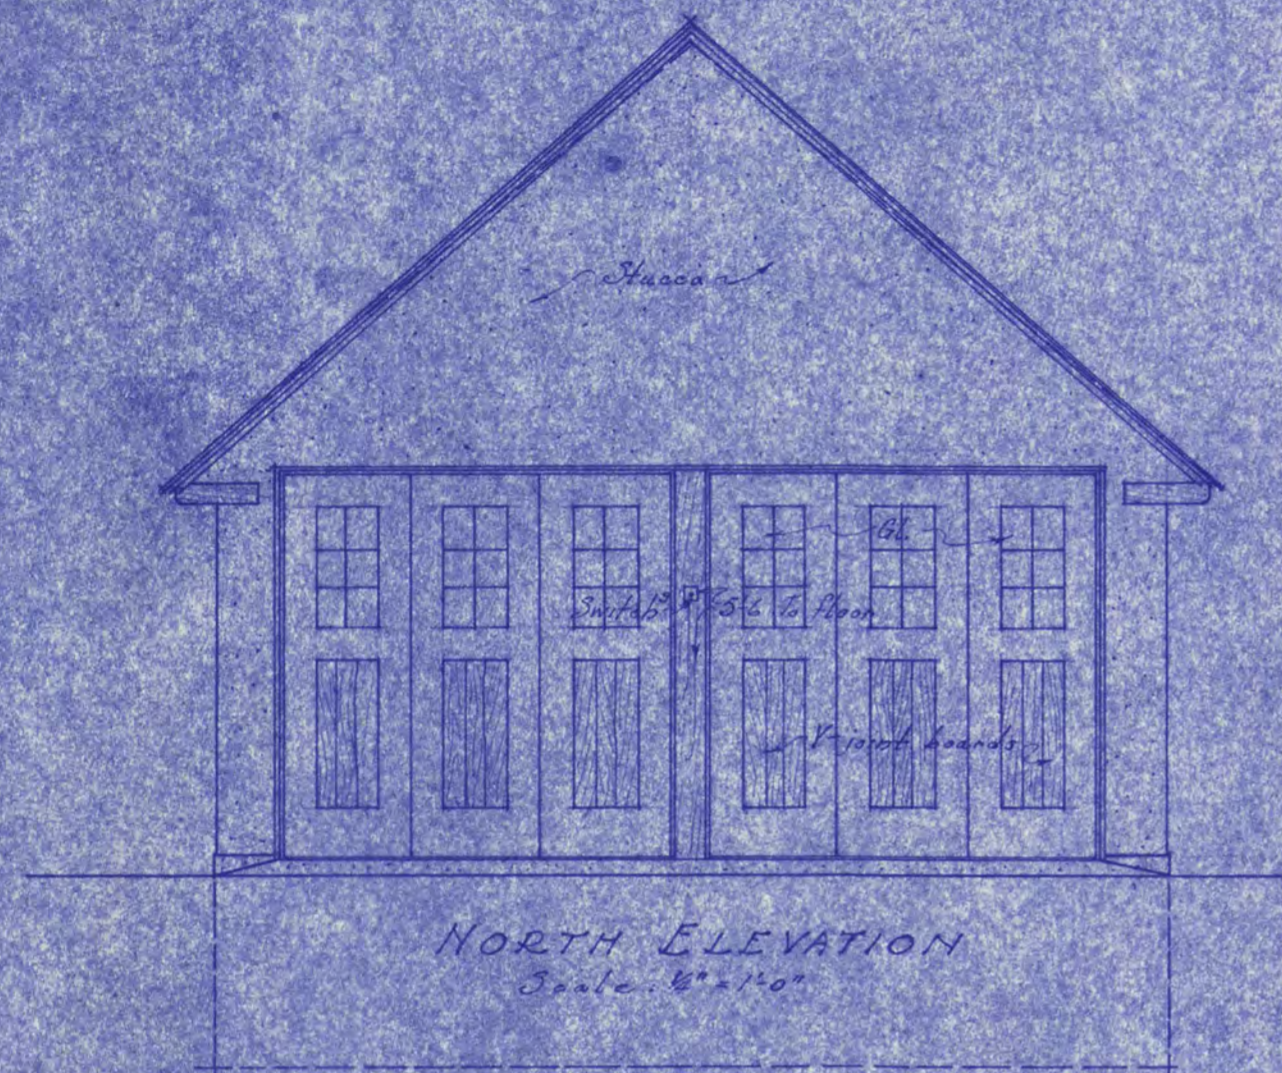

GARAGE DETAILS

RESIDENCE  
FOR  
DR. C. B. LEWIS  
ST. CLOUD MINN.


LOUIS C. PINAULT ARCHITECT  
ST. CLOUD MINN.  
DRAWING NO. 138 B-9  
DATE OCT. 7, 1925

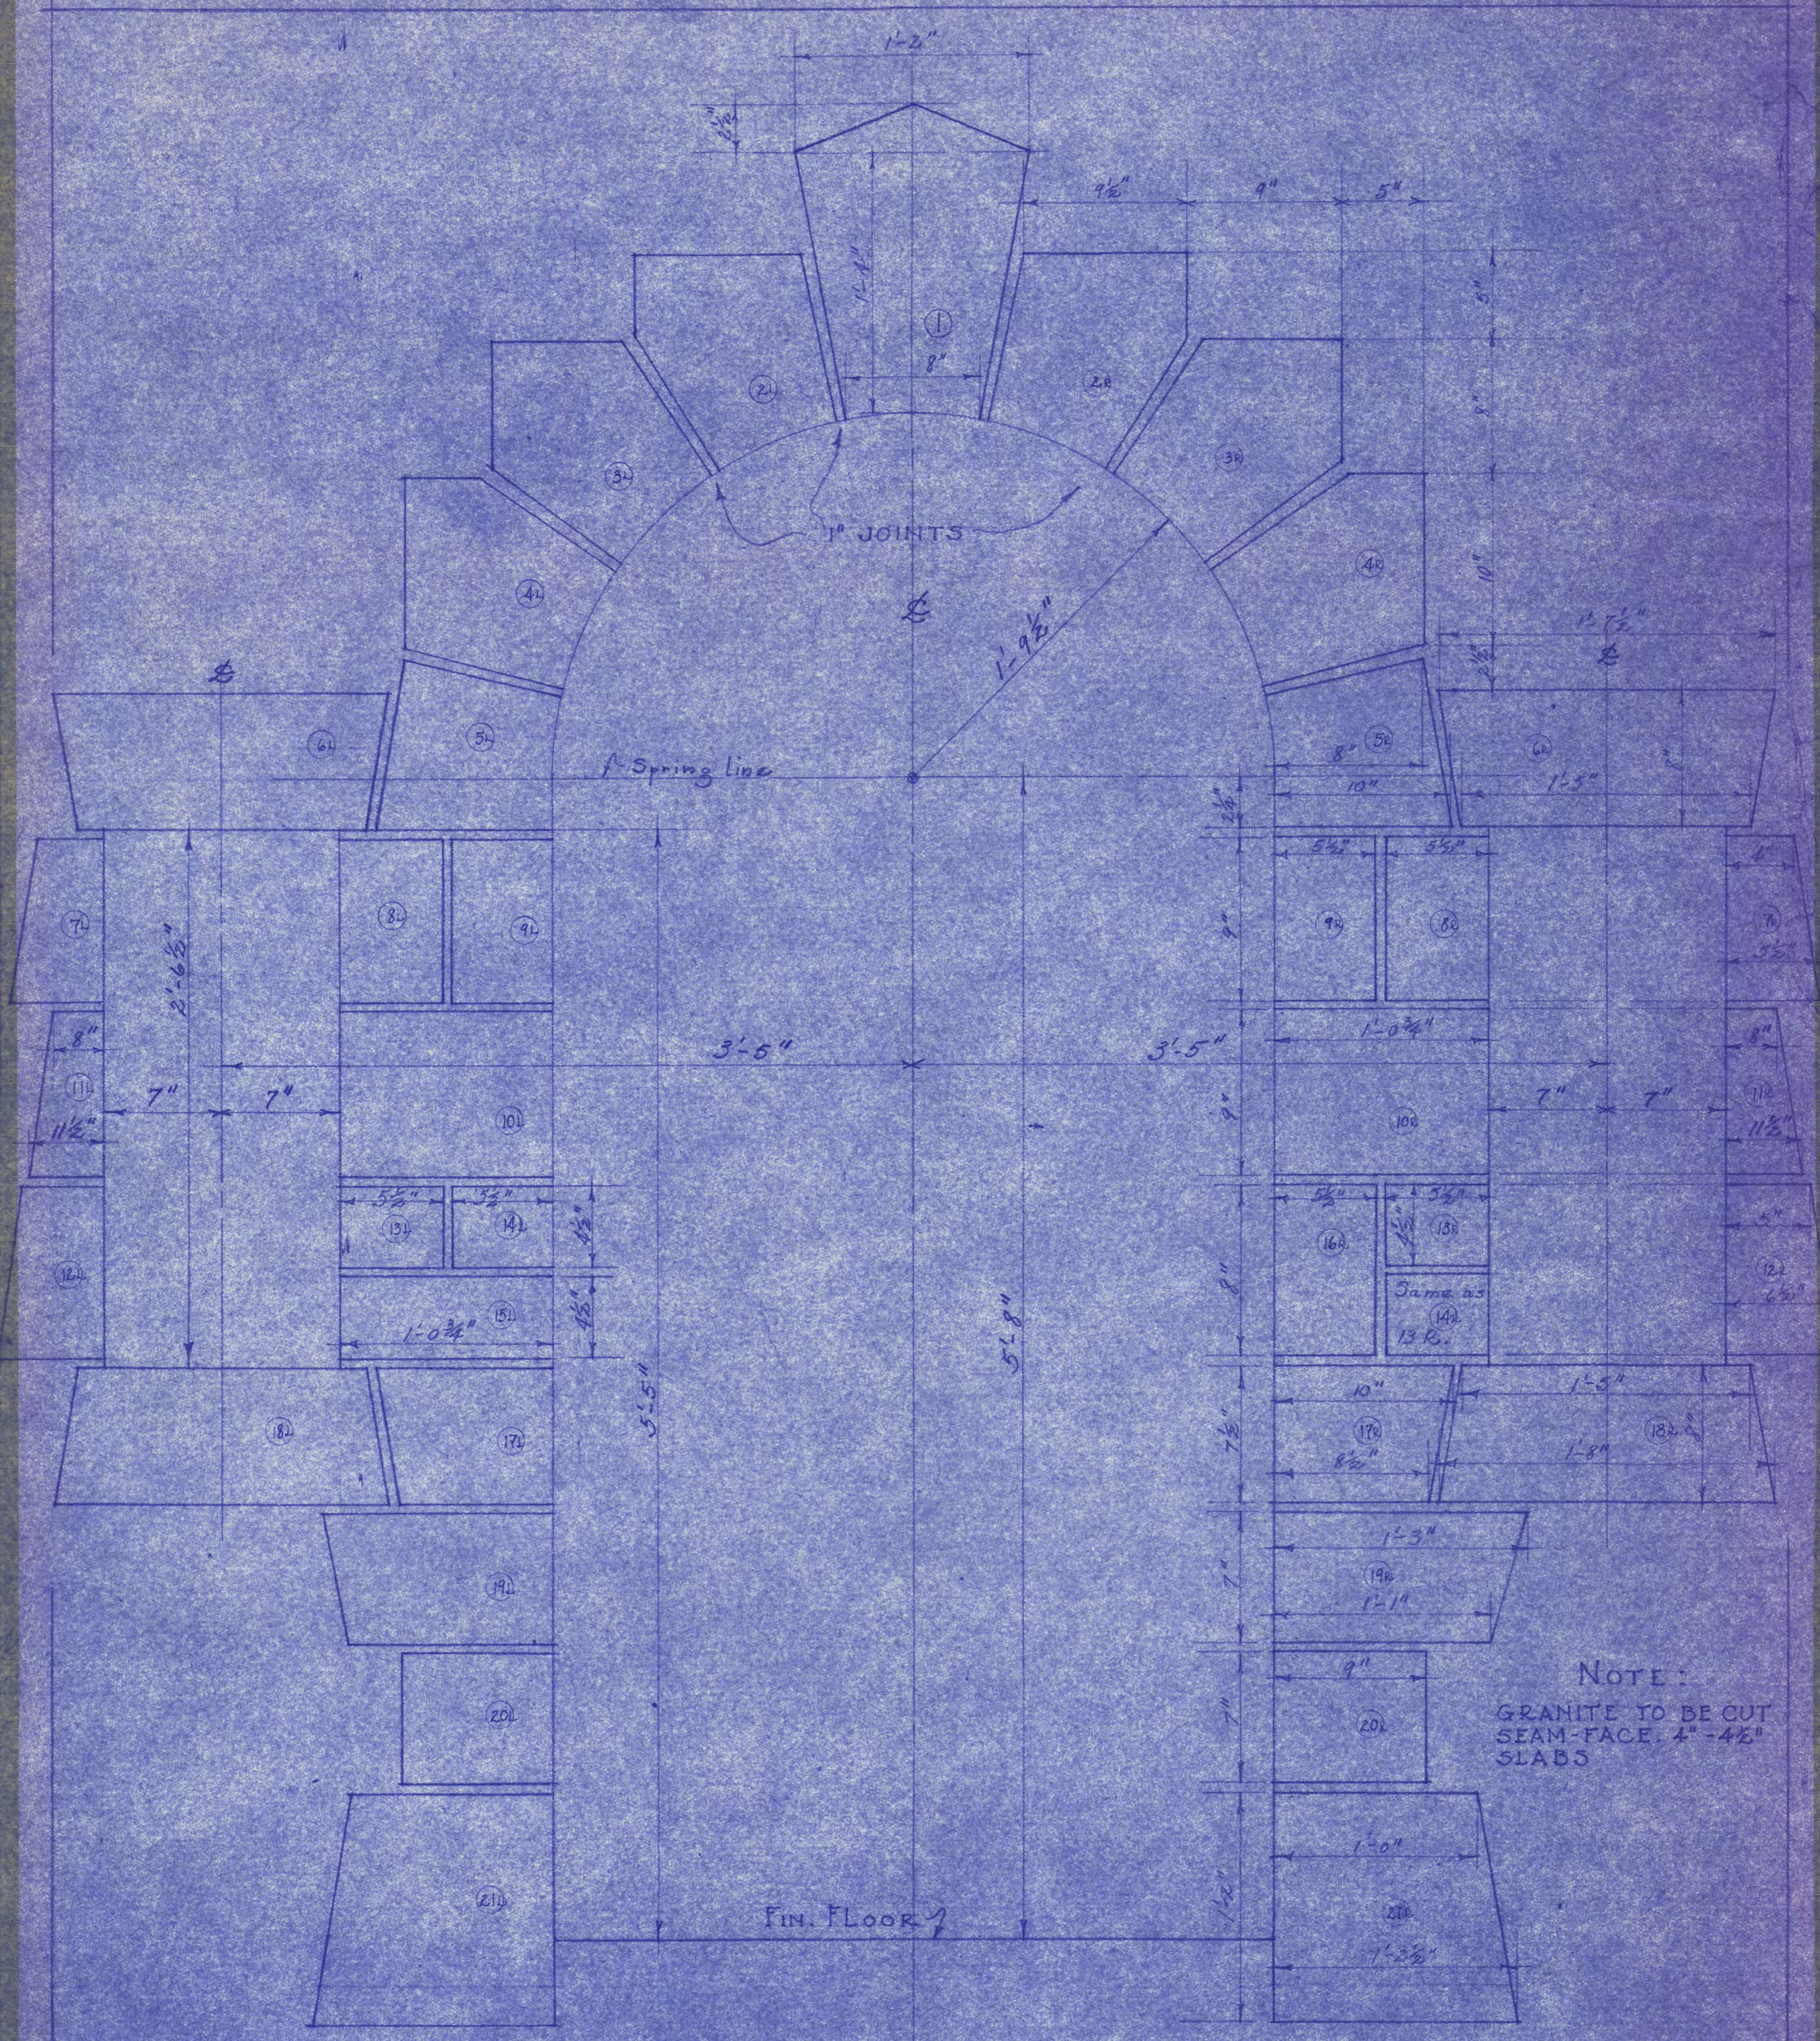


NOTE:  
 GRANITE TO BE CUT  
 SEAM-FACE 4"-4 1/2"  
 SLABS

GRANITE DIAGRAM  
 SCALE - 2" = 1'-0"  
 ENTRANCE  
 OF  
 RESIDENCE  
 FOR  
 DR. C. B. LEWIS

LOUIS C. PINAULT ARCHITECT  
 ST. CLOUD MINN.  
 DRAWING NO. 138 B-II

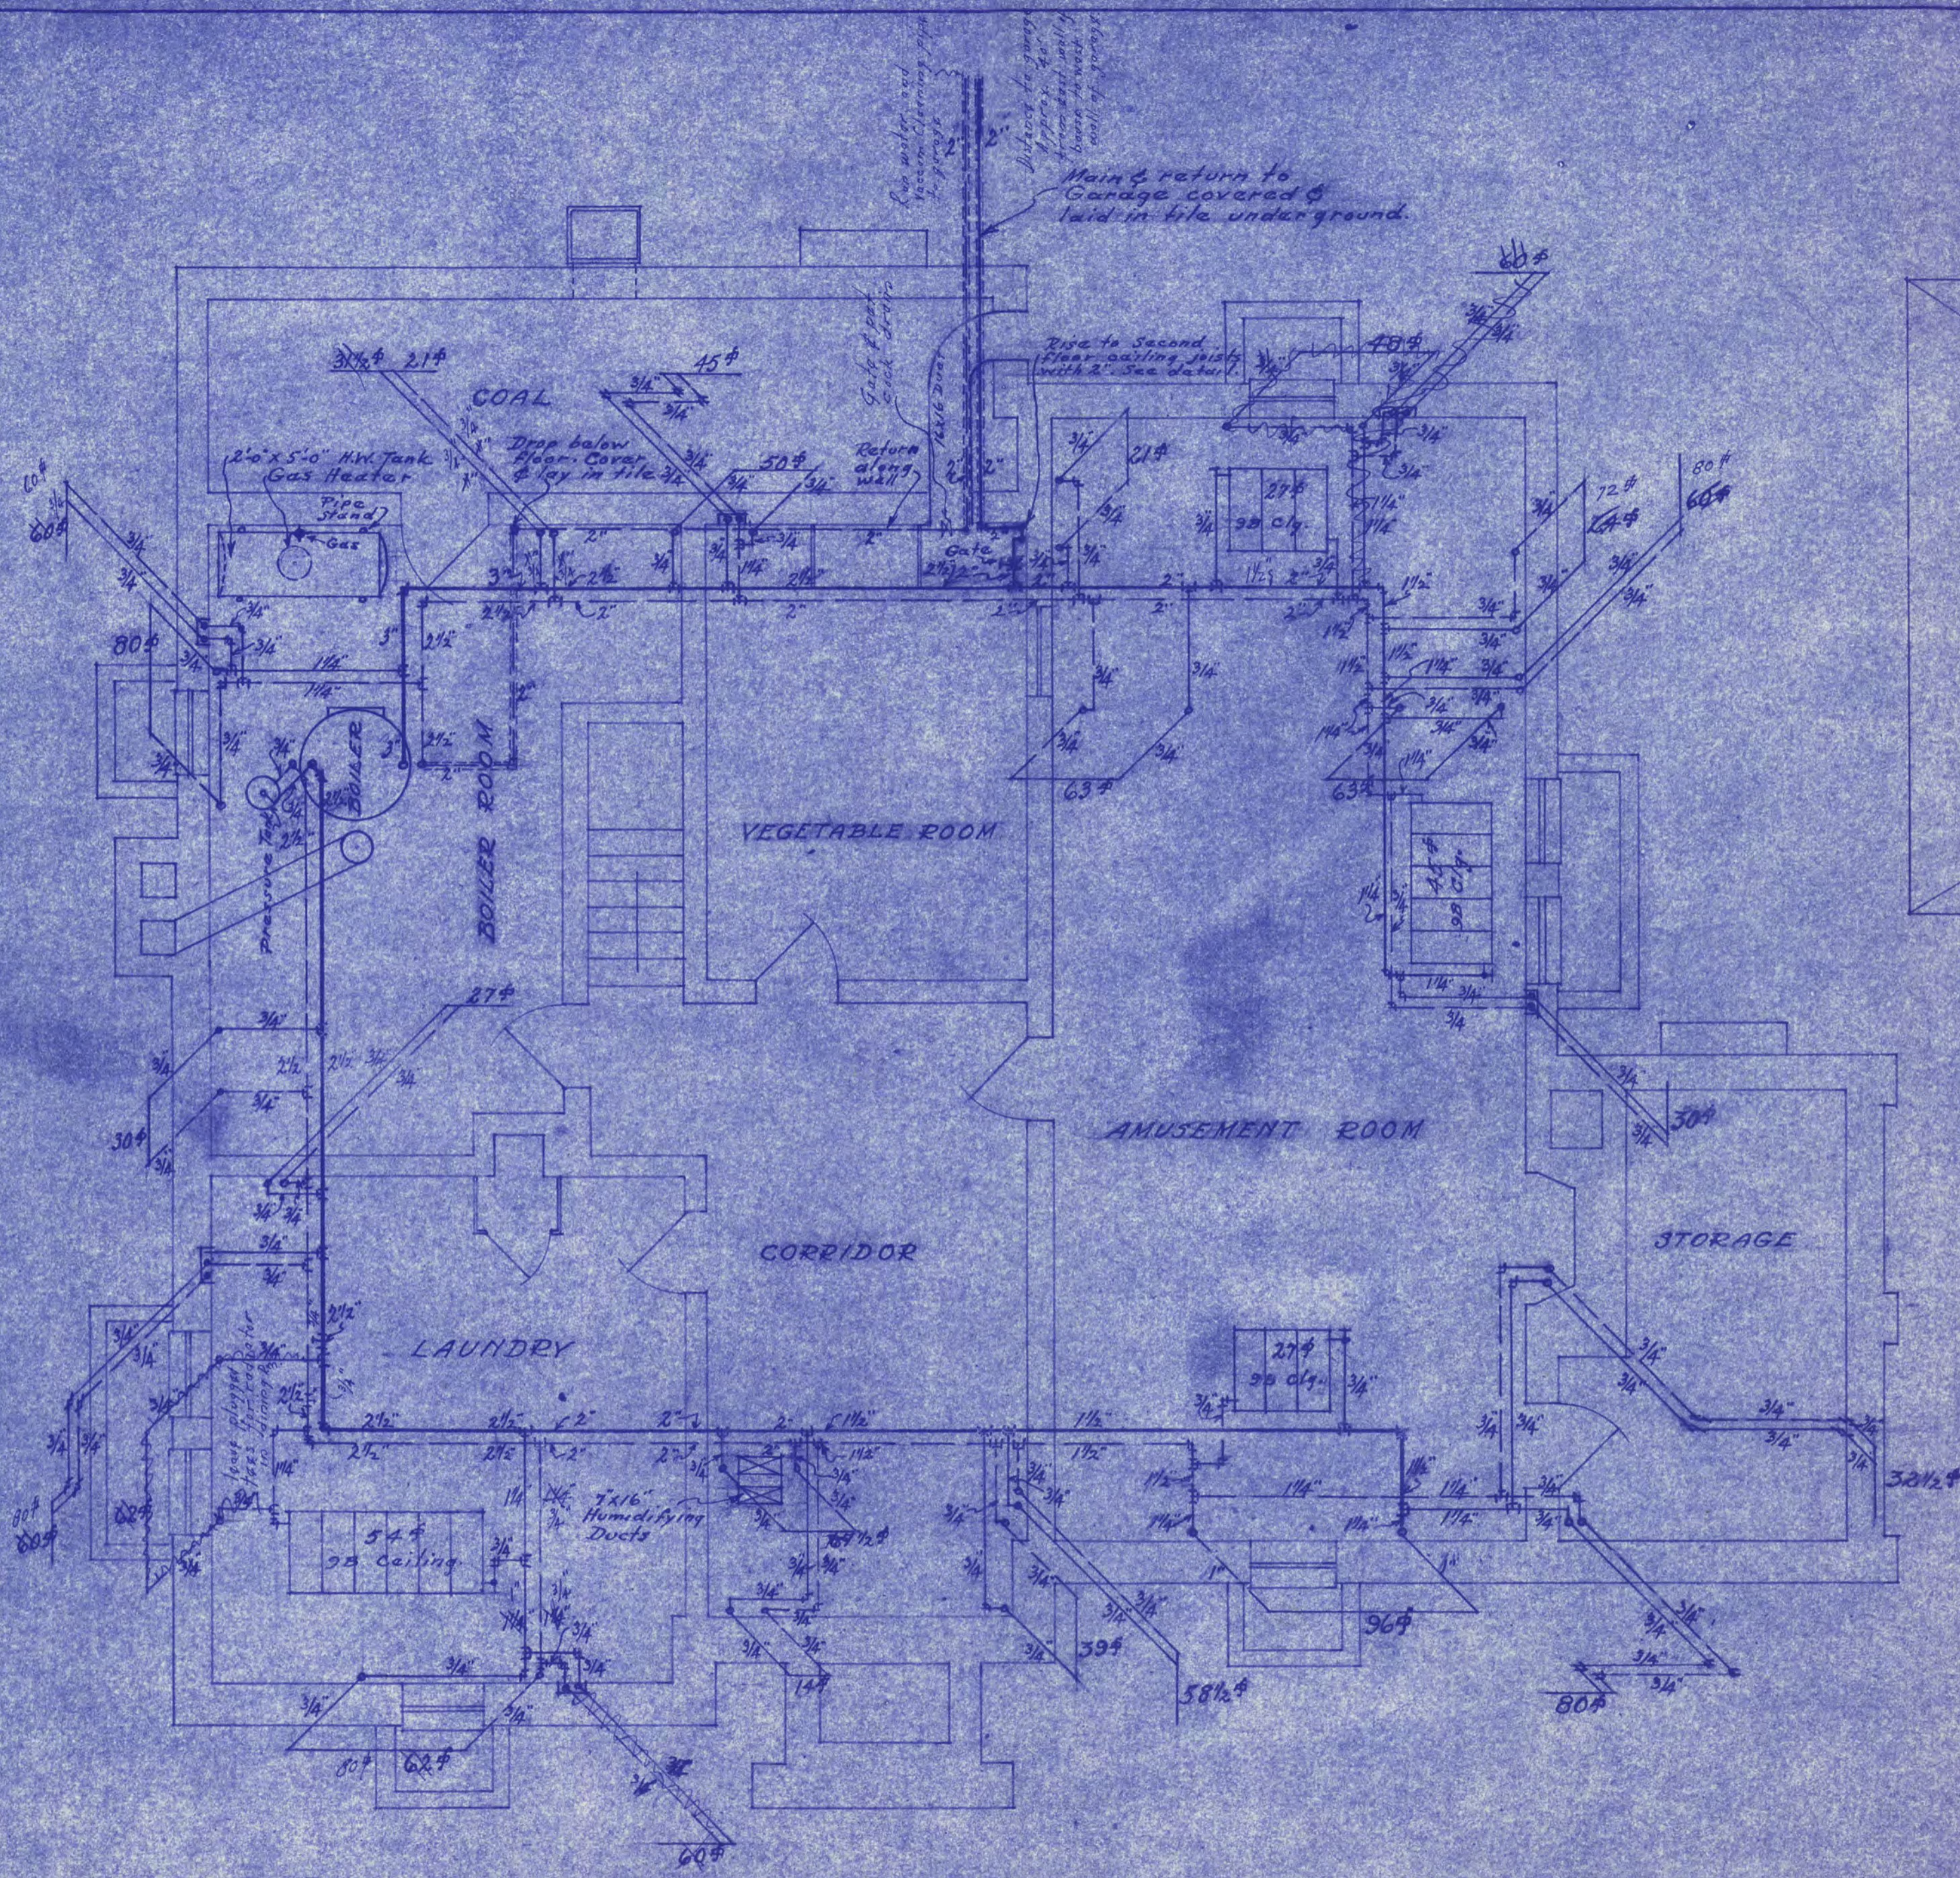


**BASEMENT PIPING PLAN**  
Scale 1/4" = 1'-0"

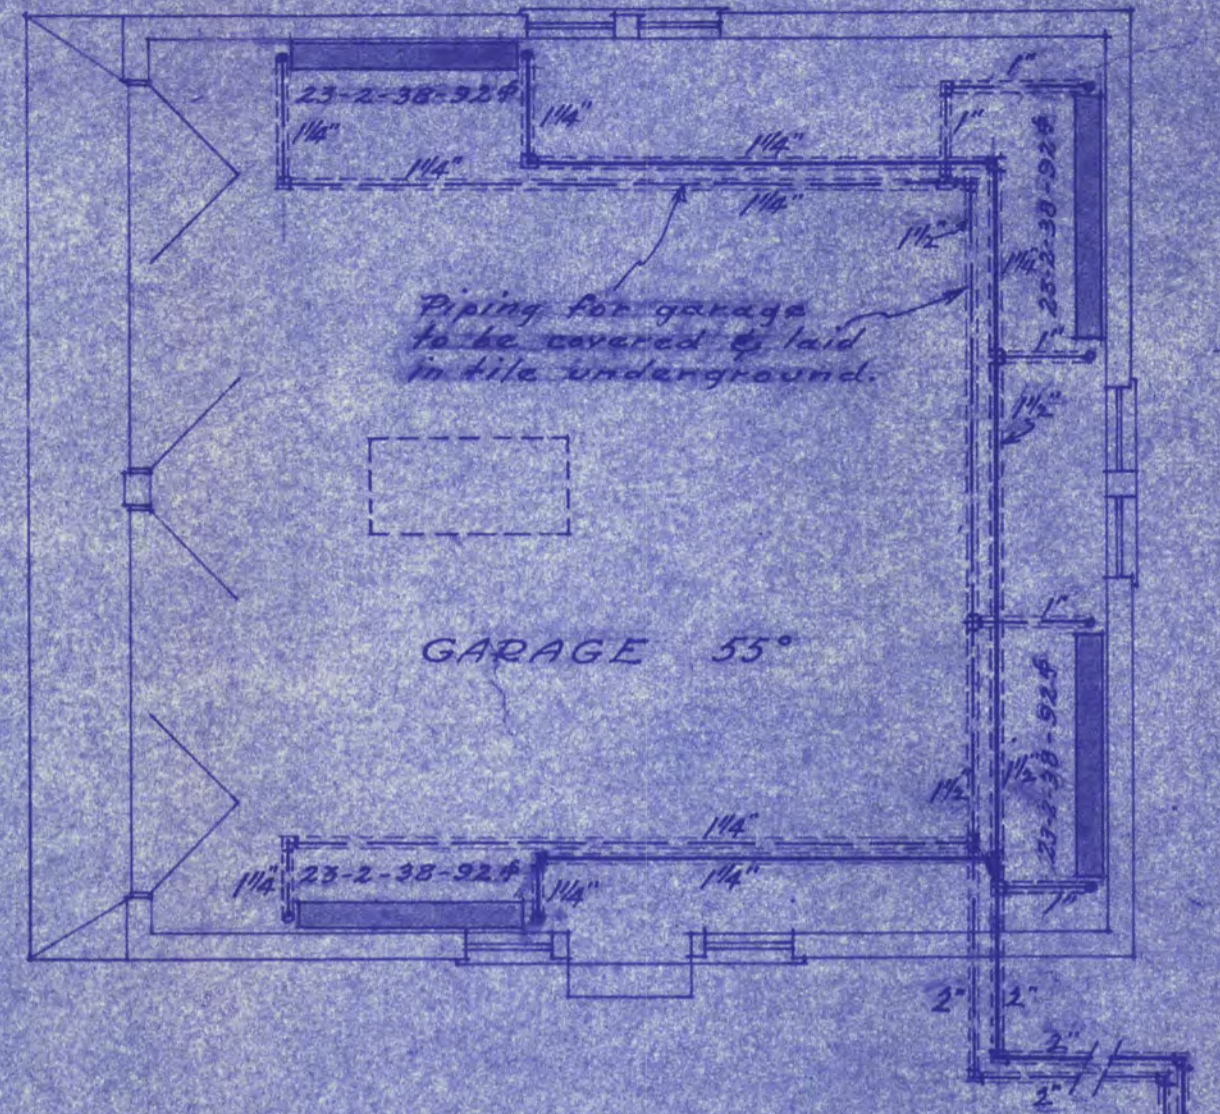


**GARAGE PLAN**  
Scale 1/4" = 1'-0"

From house plant


**HOT WATER HEATING SYSTEM**  
FOR DR. C.B. LEWIS RES.  
ST. CLOUD, MINN.  
MR. L.C. PINAULT - ARCHT.  
G.M. ORR & CO - ENGINEERS.  
ST. CLOUD, MINN. 2-6-26

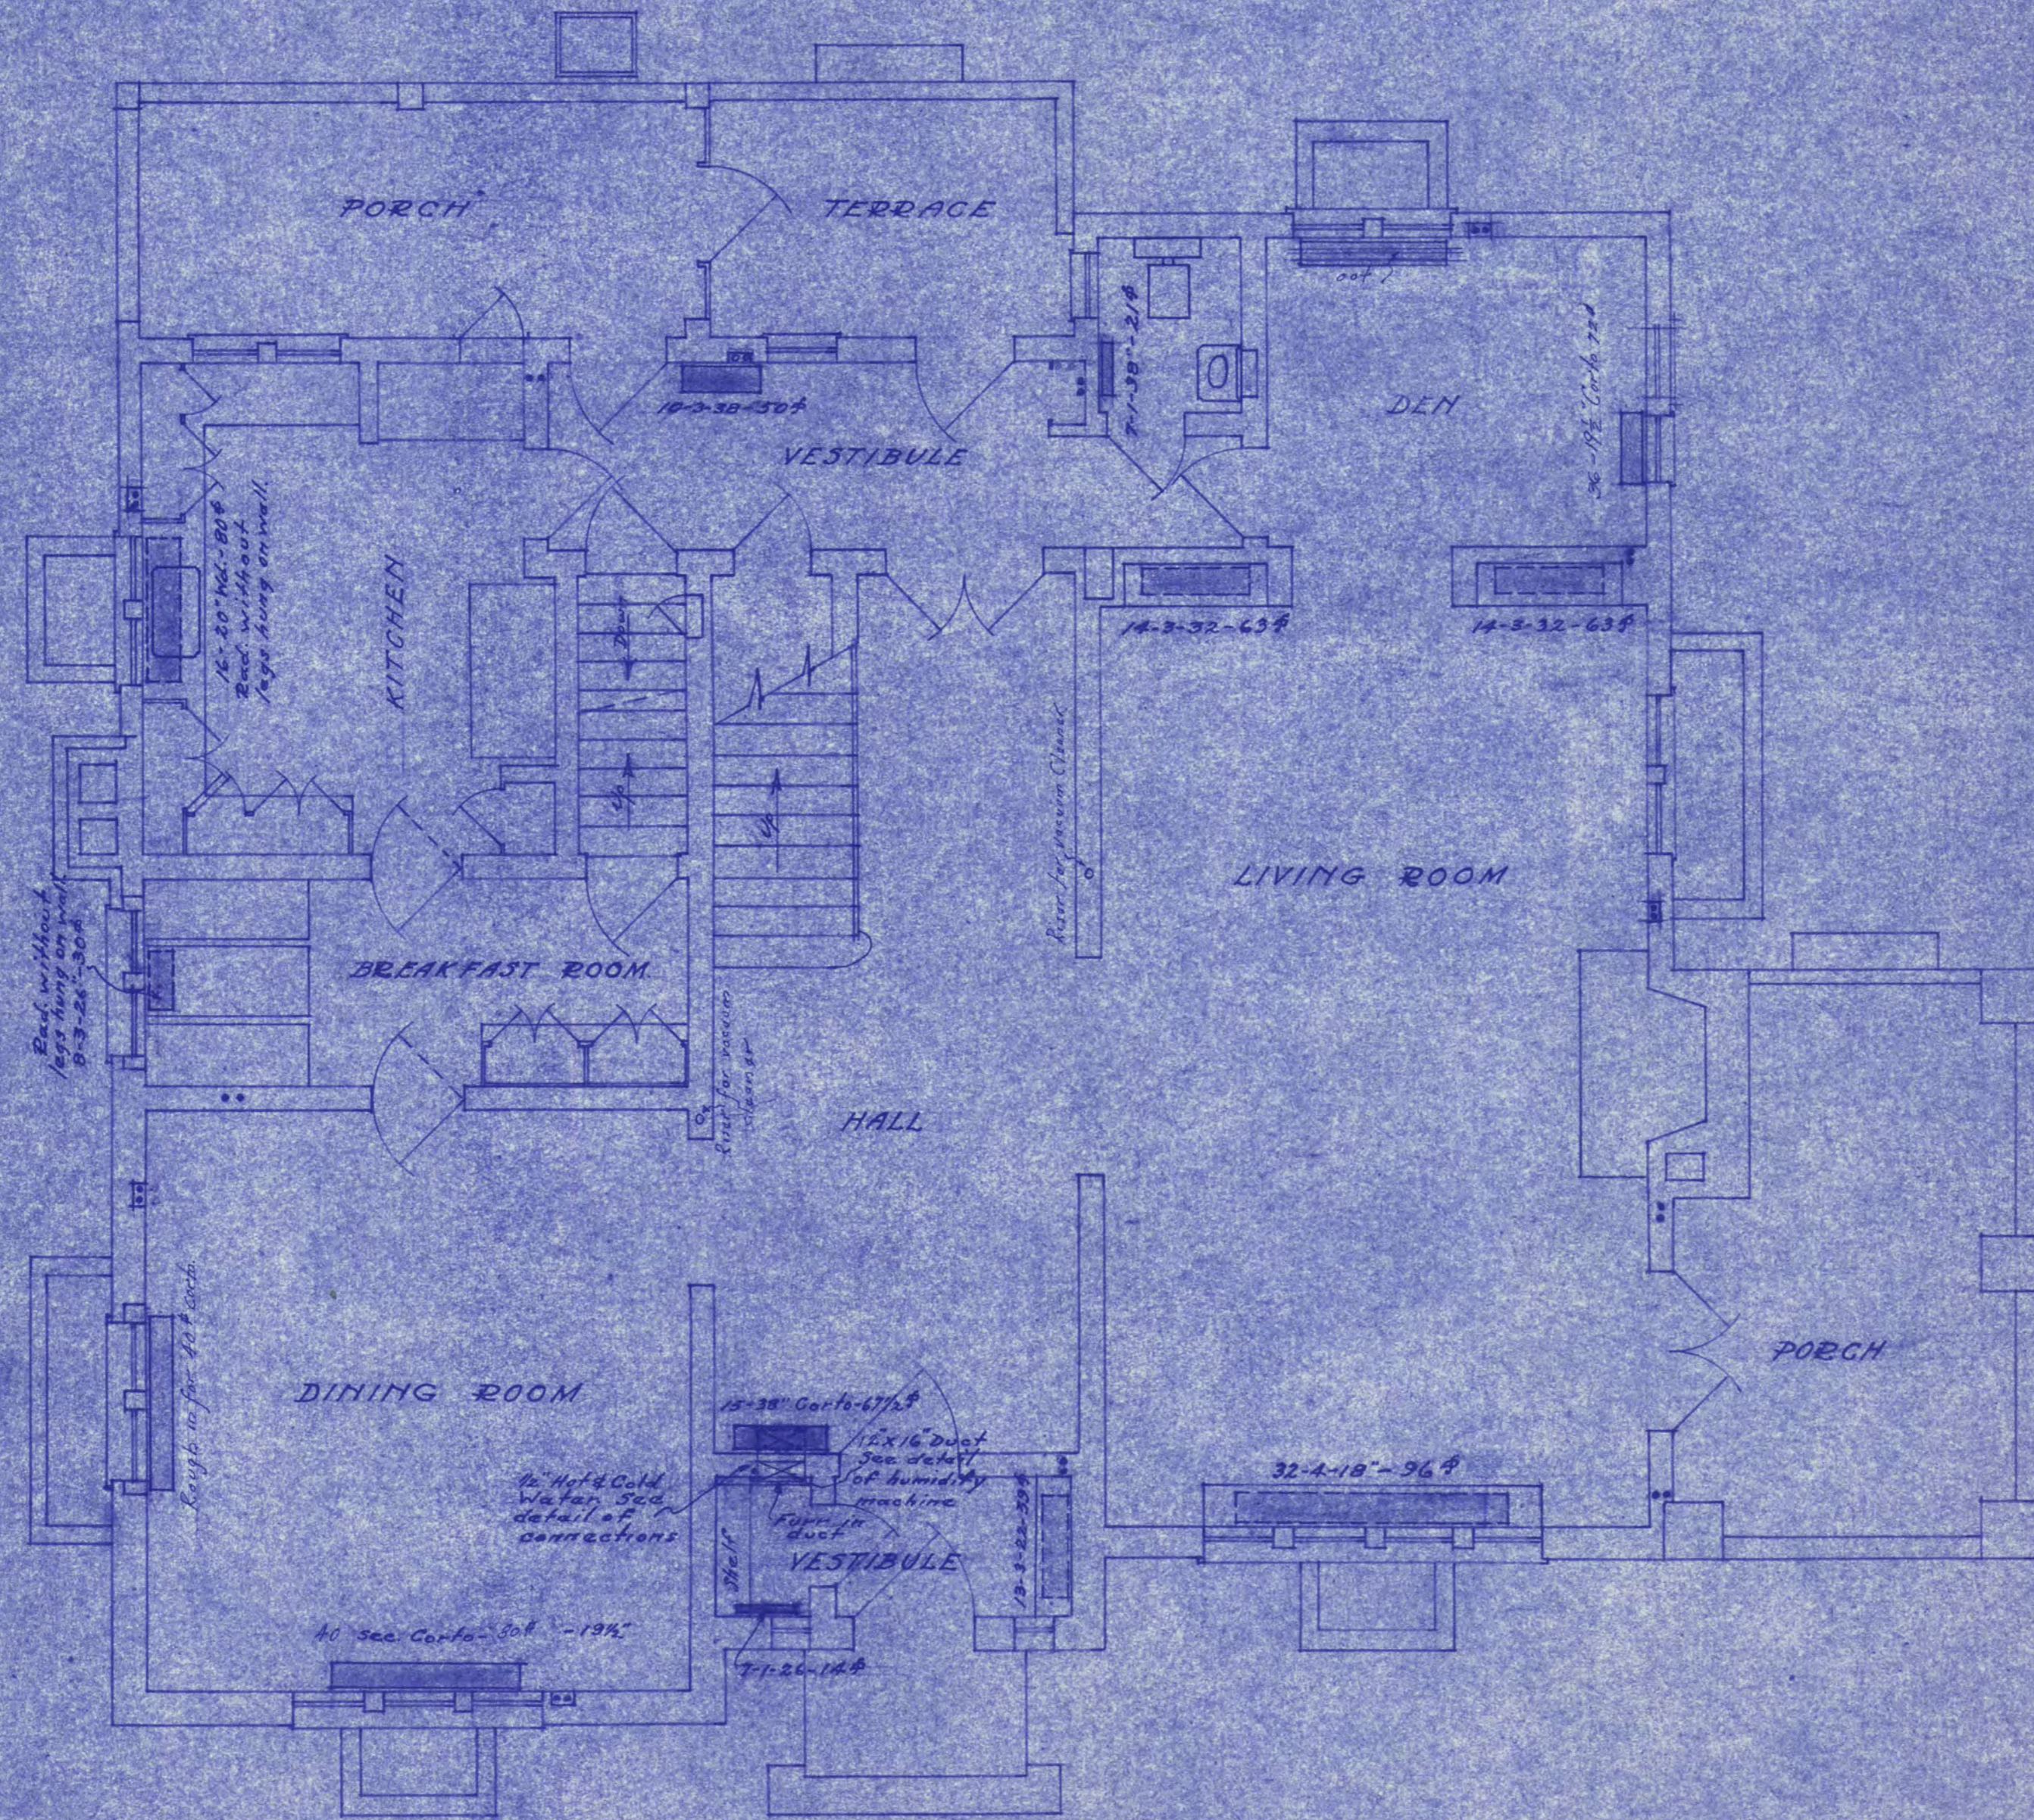


FIRST FLOOR PLAN  
Scale 1/4" = 1'-0"

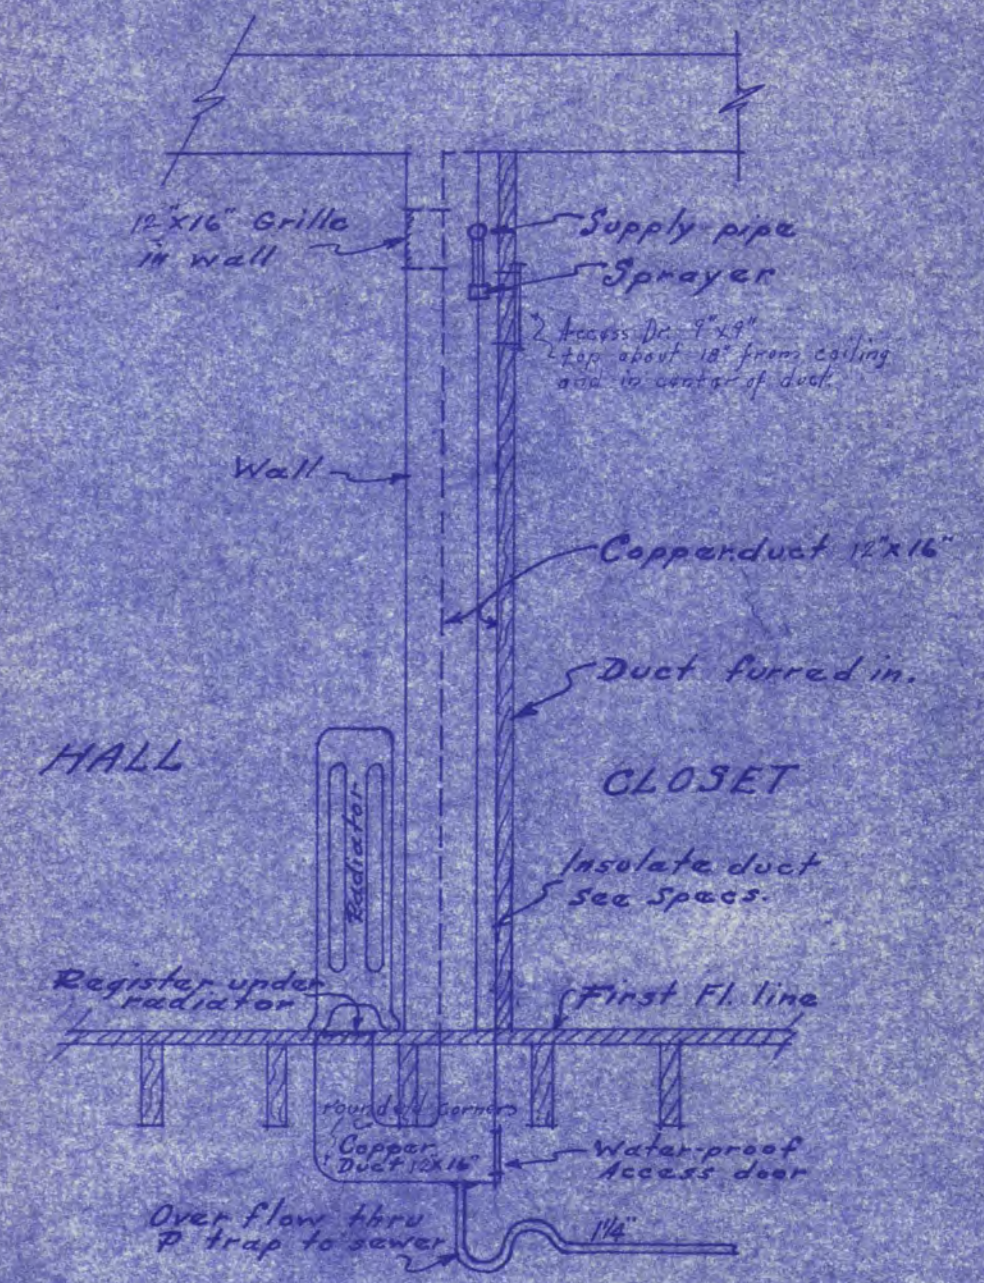


DETAIL OF HUMIDIFYING SYSTEM ON FIRST FL.  
Scale 1/2" = 1'-0"

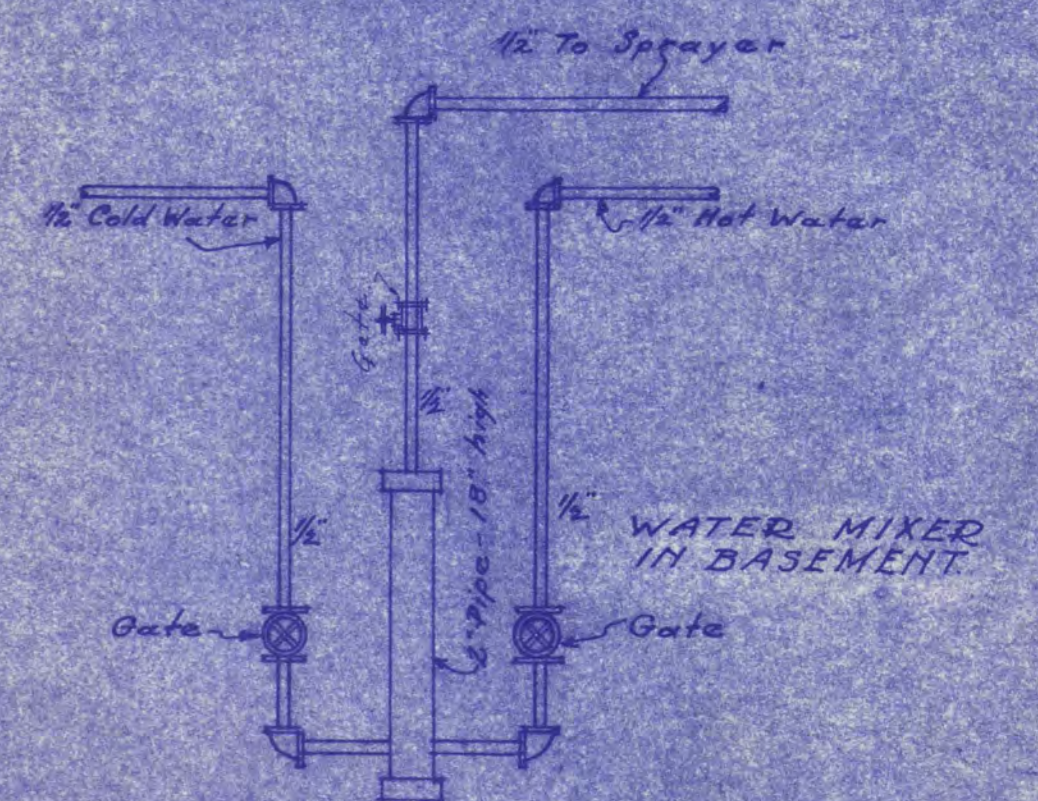


DETAIL OF WATER MIXER FOR HUMIDITY SPRAY  
No Scale

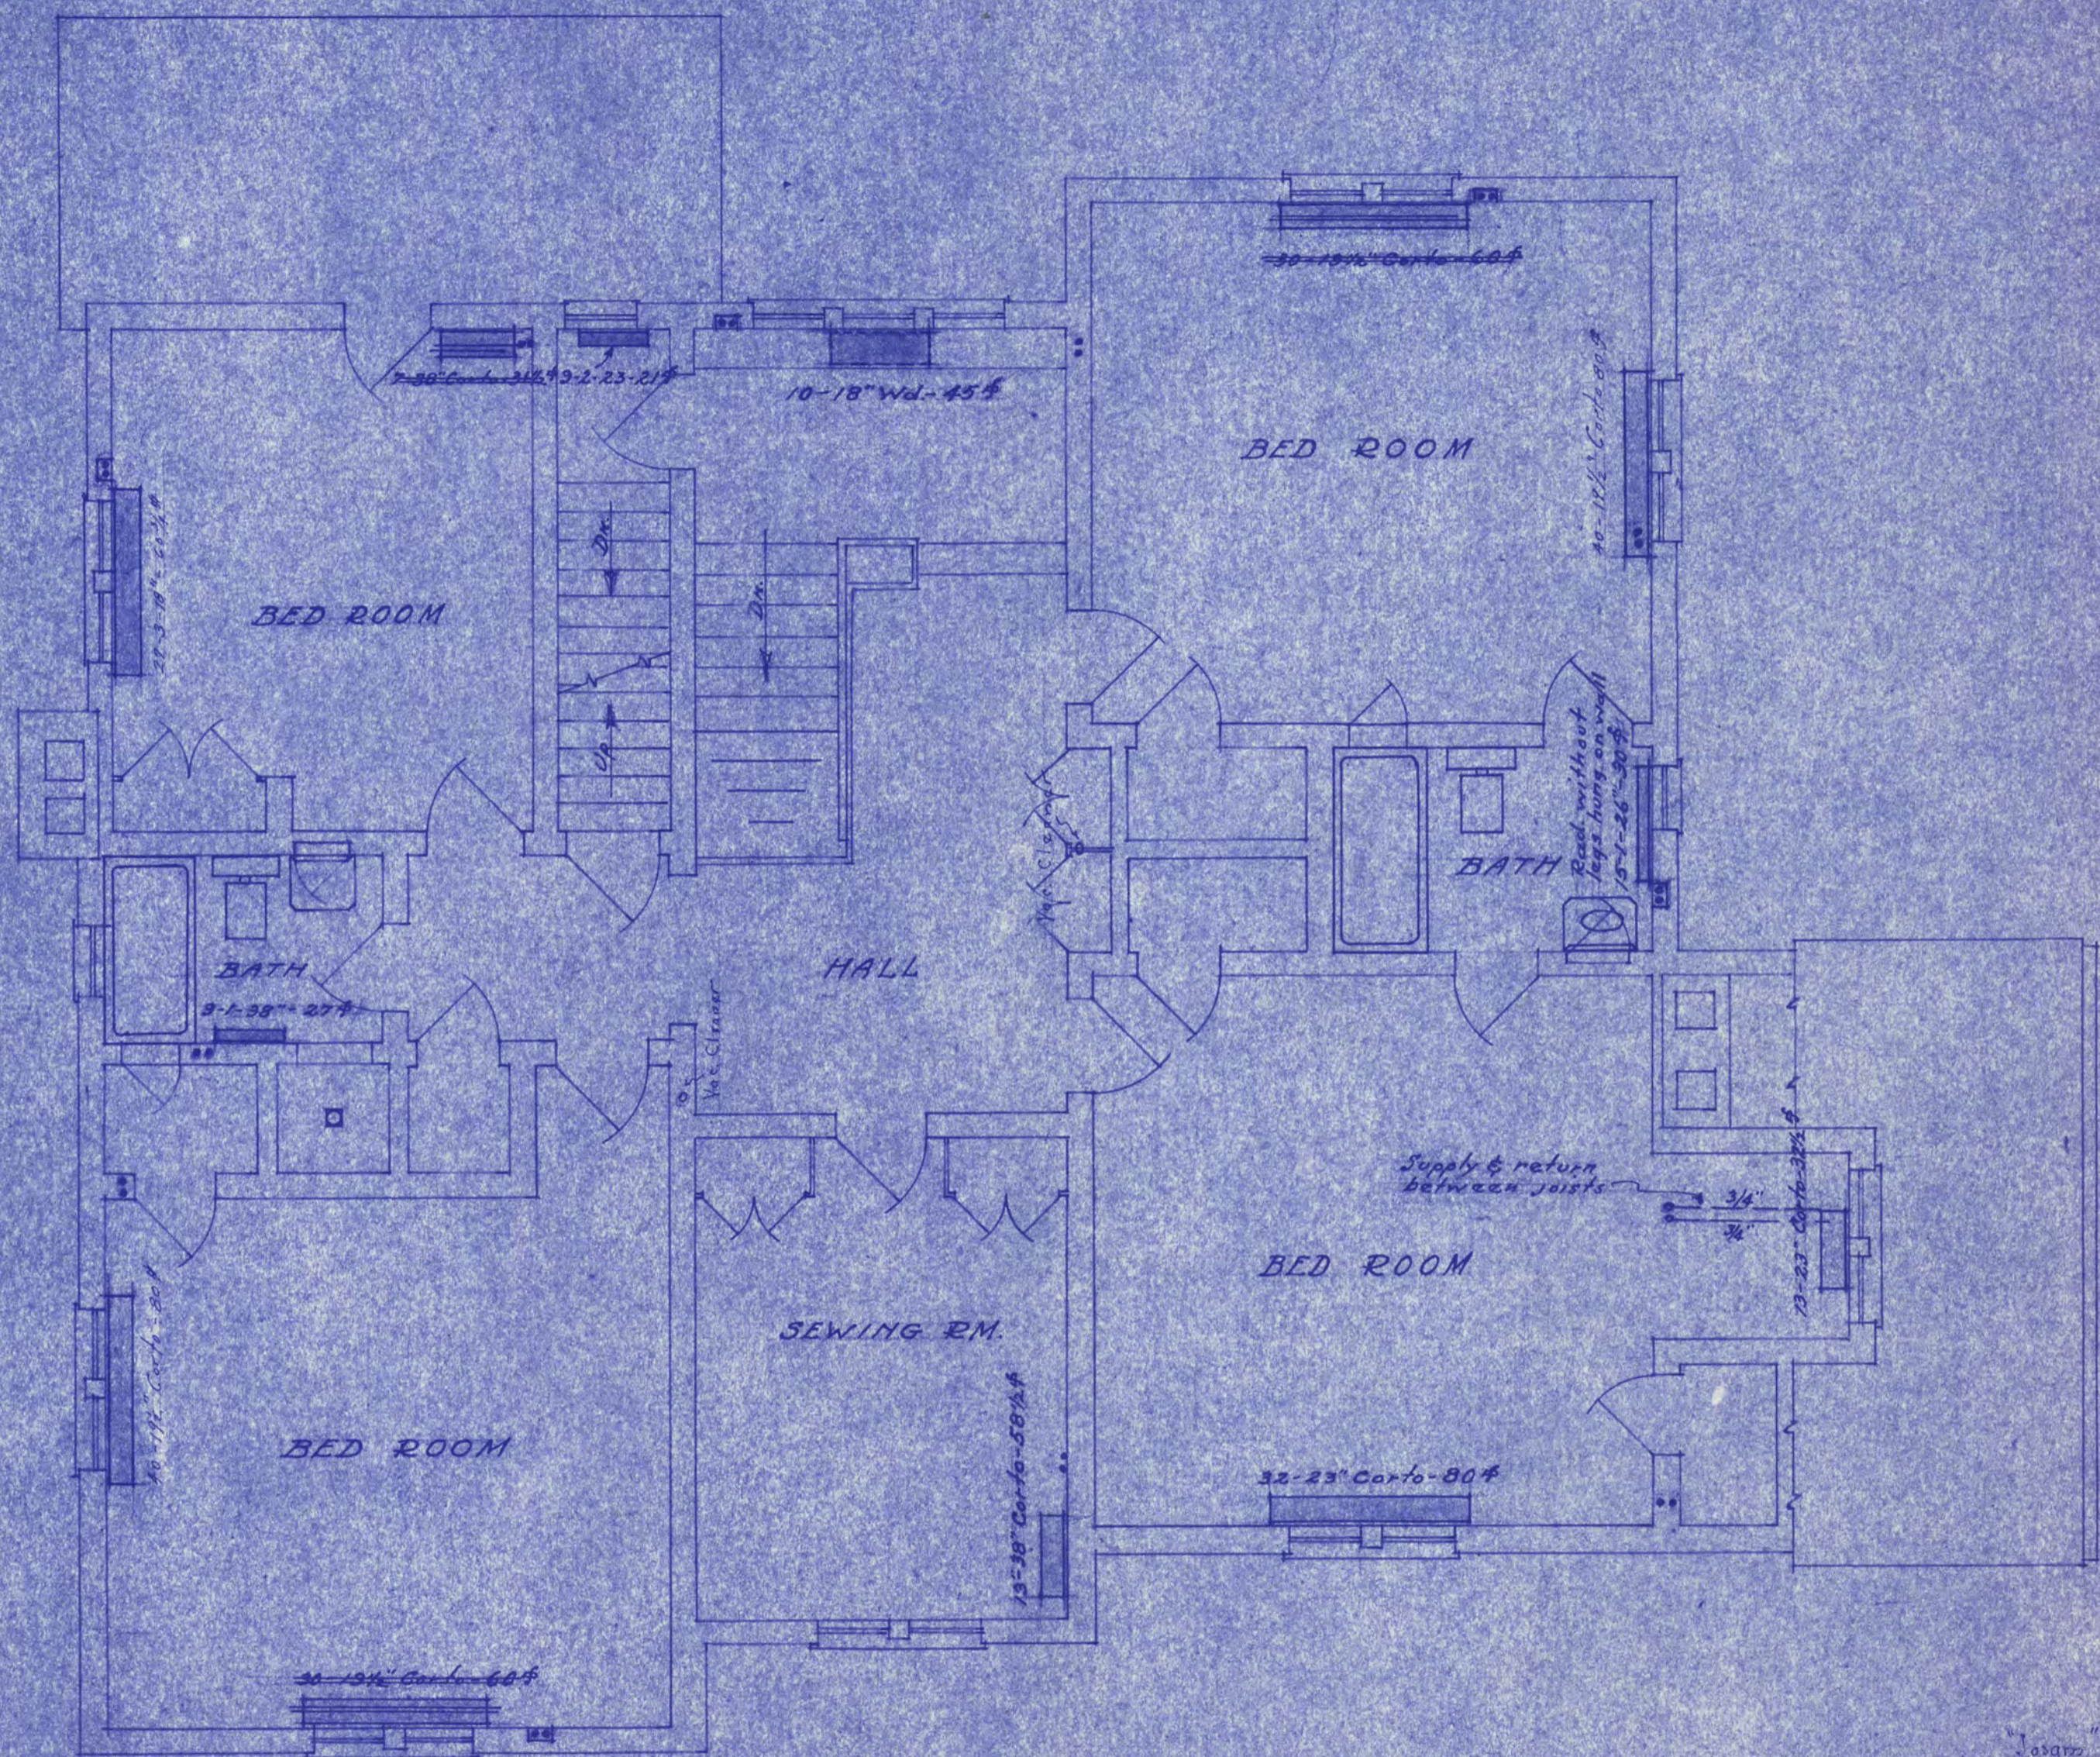

SECOND FLOOR PLAN  
Scale 1/4" = 1'-0"

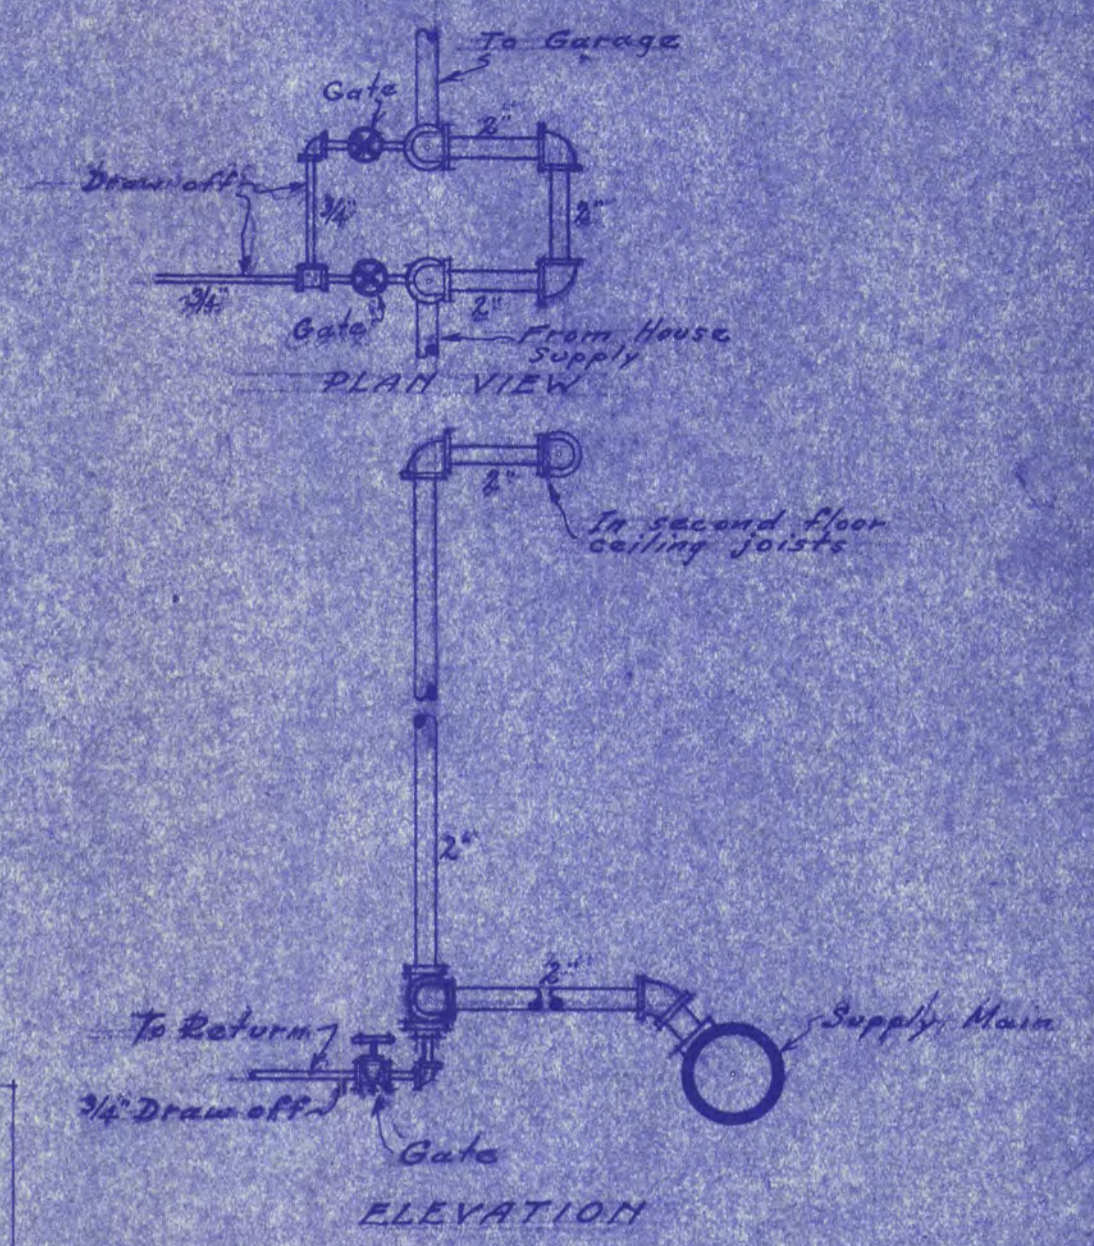


DETAIL OF RISERS FOR GARAGE MAIN SUPPLY  
No. Scale

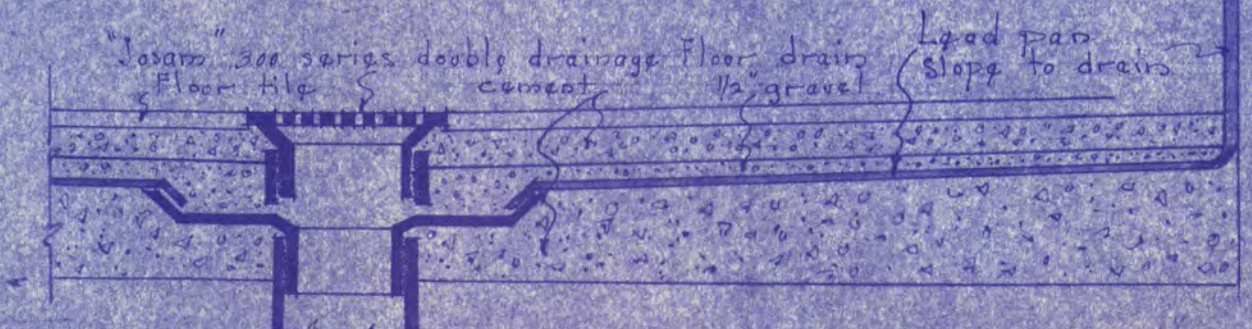

DETAIL SHOWING DRAIN & LEAD PAN FOR SHOWER STALL  
Lead pan & drain to be installed by plumbing contractor

Dr. G. B. Lewis Residence  
Drawing No. 130-B-14  
Louis C. Pirault Architect

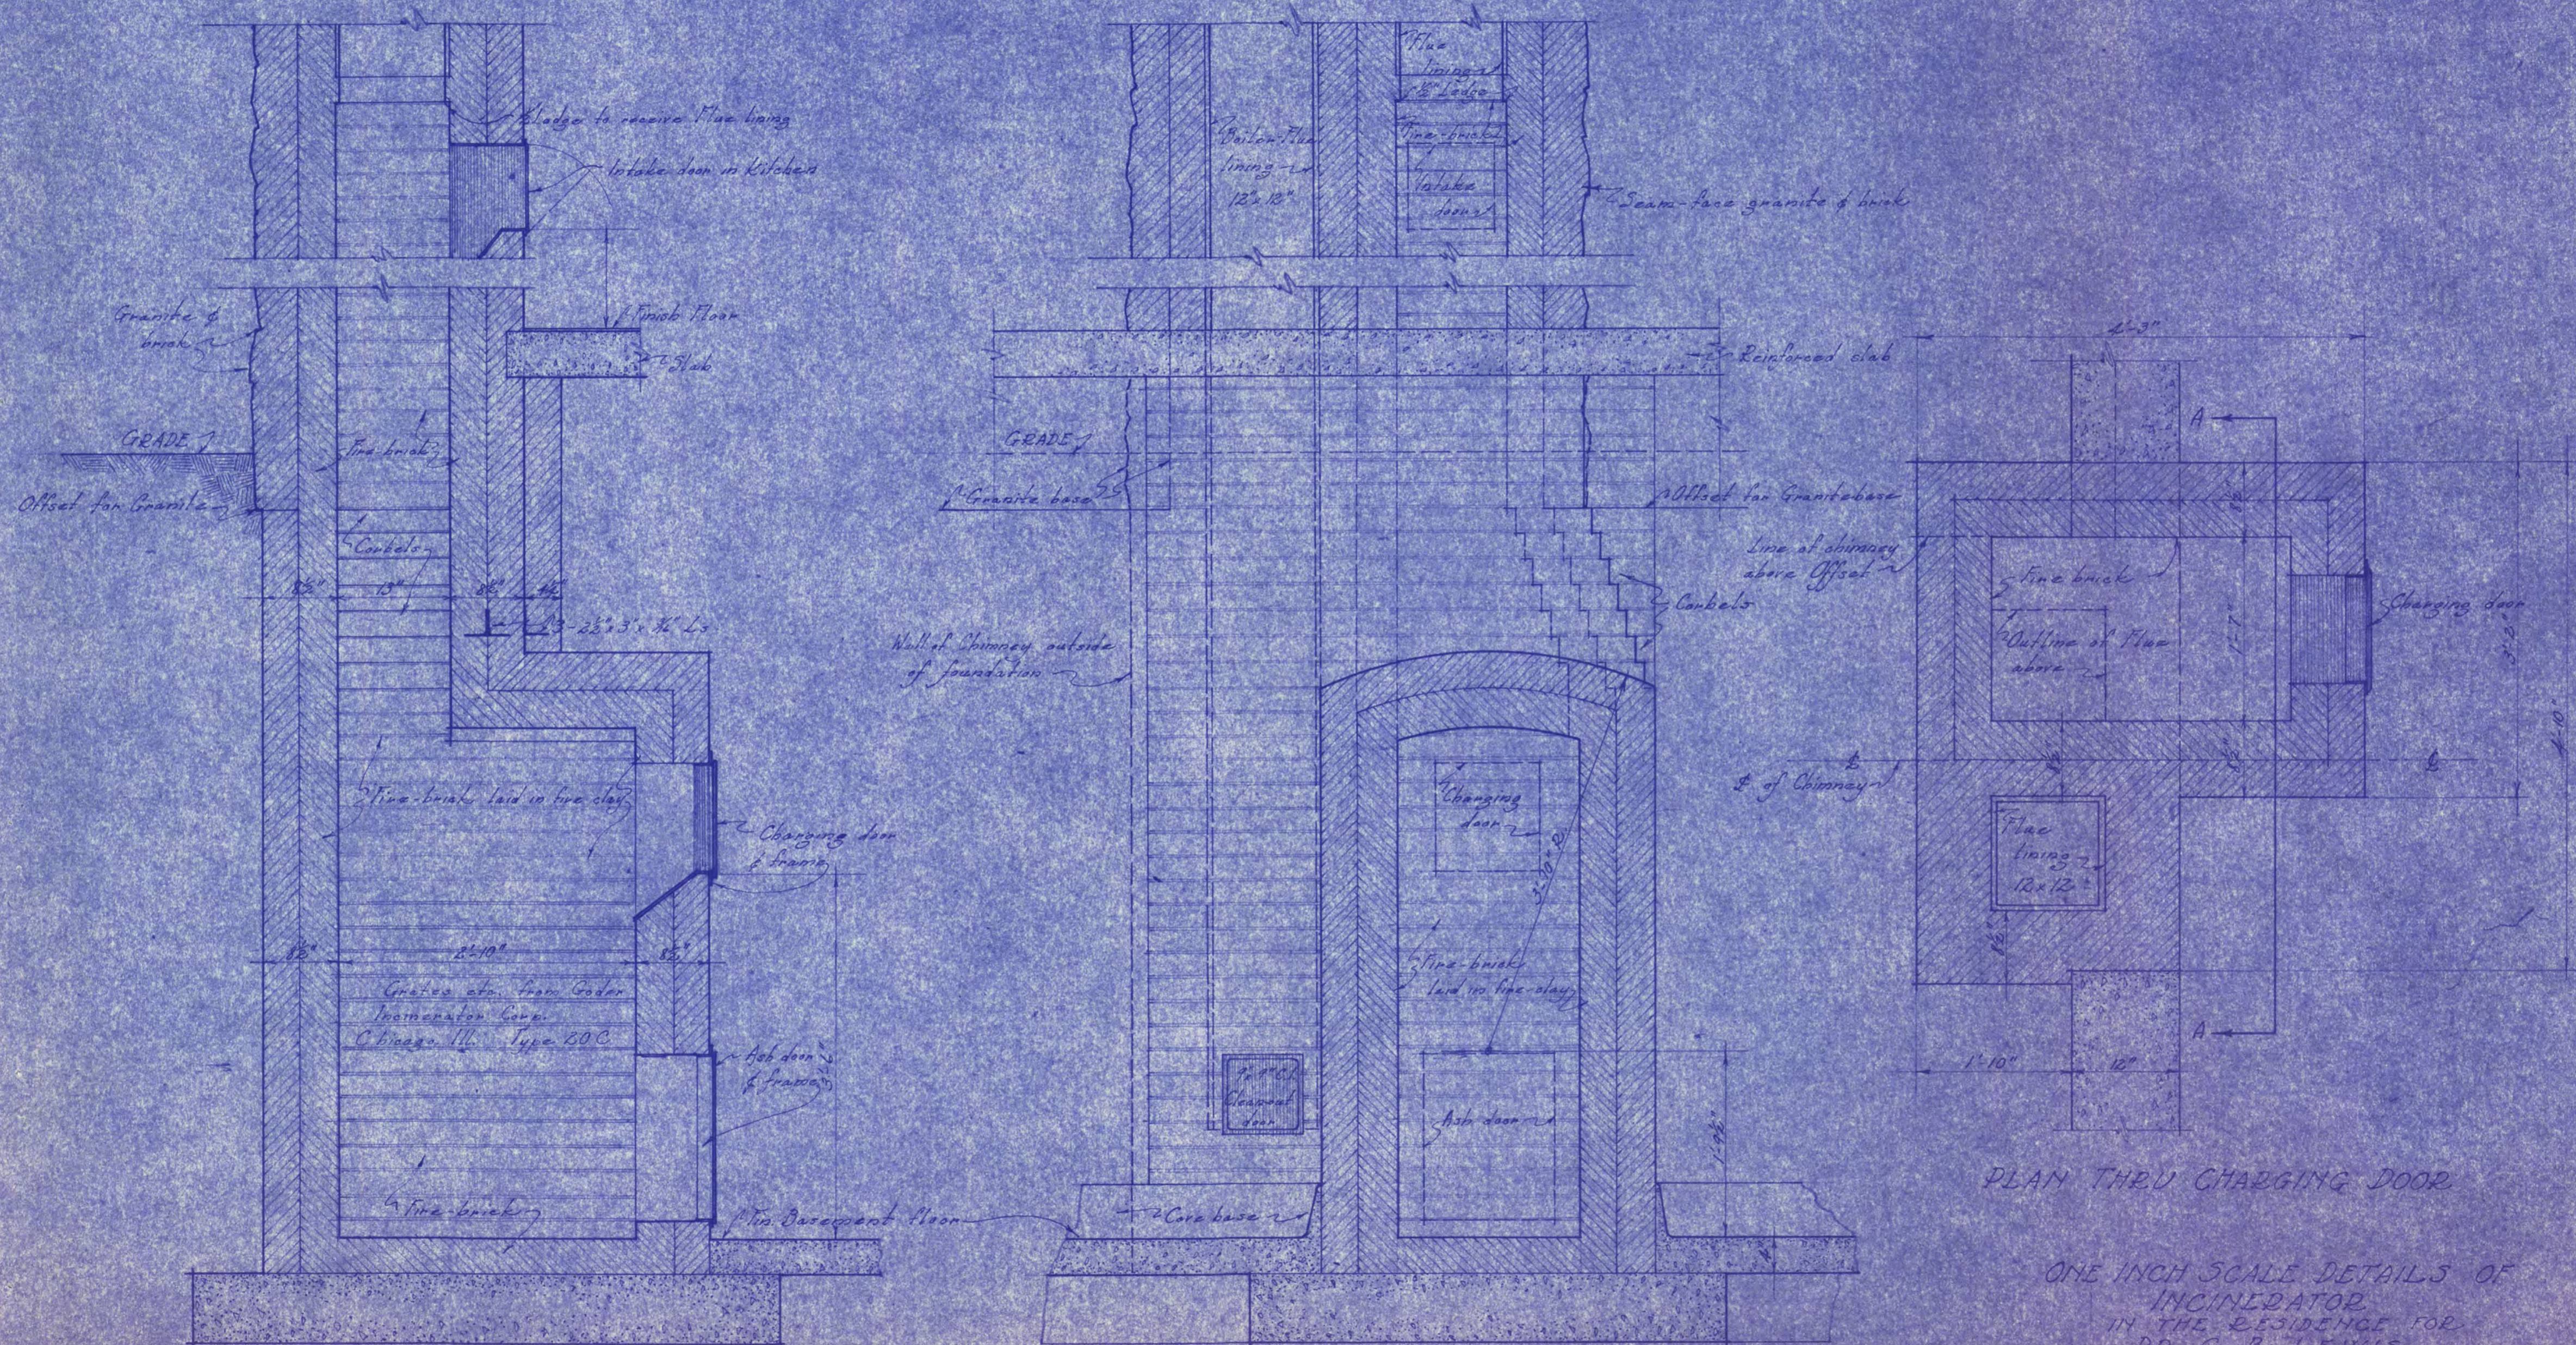

SECTION THRU INCINERATOR ON C-C

SECTION "AA"

PLAN THRU CHARGING DOOR

ONE INCH SCALE DETAILS OF  
INCINERATOR  
IN THE RESIDENCE FOR  
DR. C. B. LEWIS

LOUIS C. DINAULT ARCHITECT  
54 Clouds Mtn. Dulles, Va. 5/11/25  
Drawing No. 138-B-10



