




SECTION Z-Z
SCALE 1/8" = 1'-0"

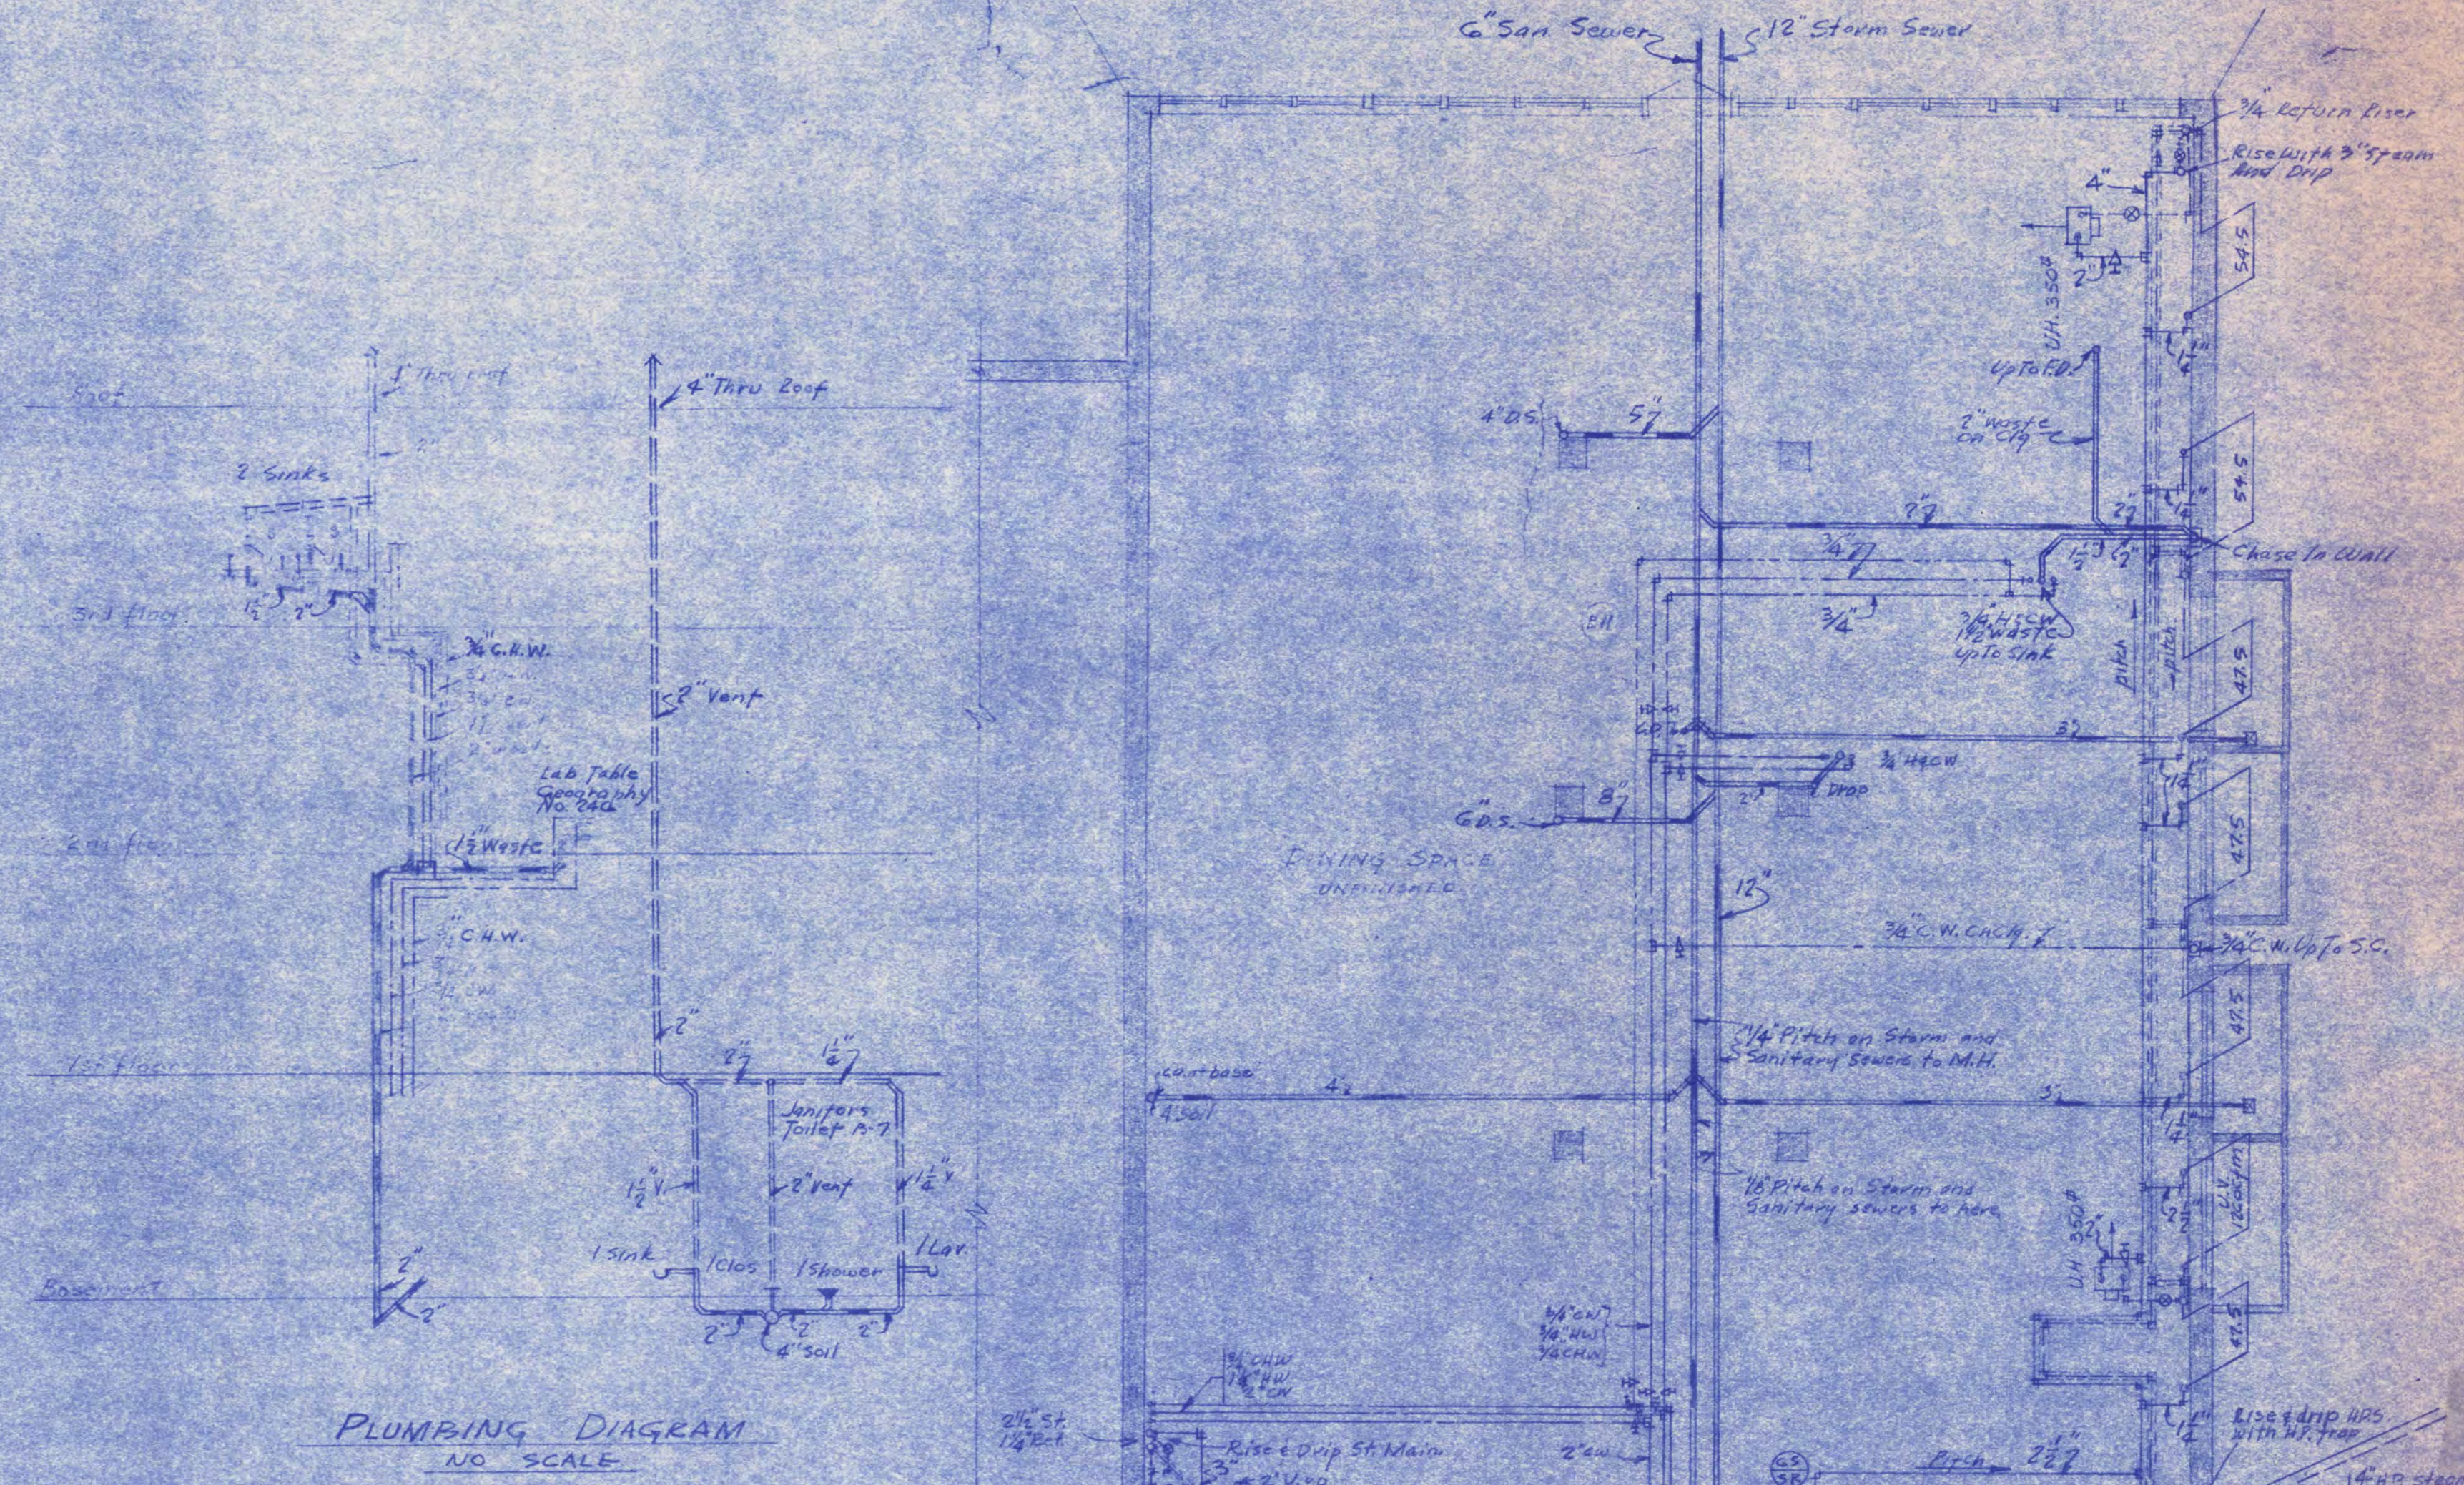


PLUMBING DIAGRAM
NO. 2

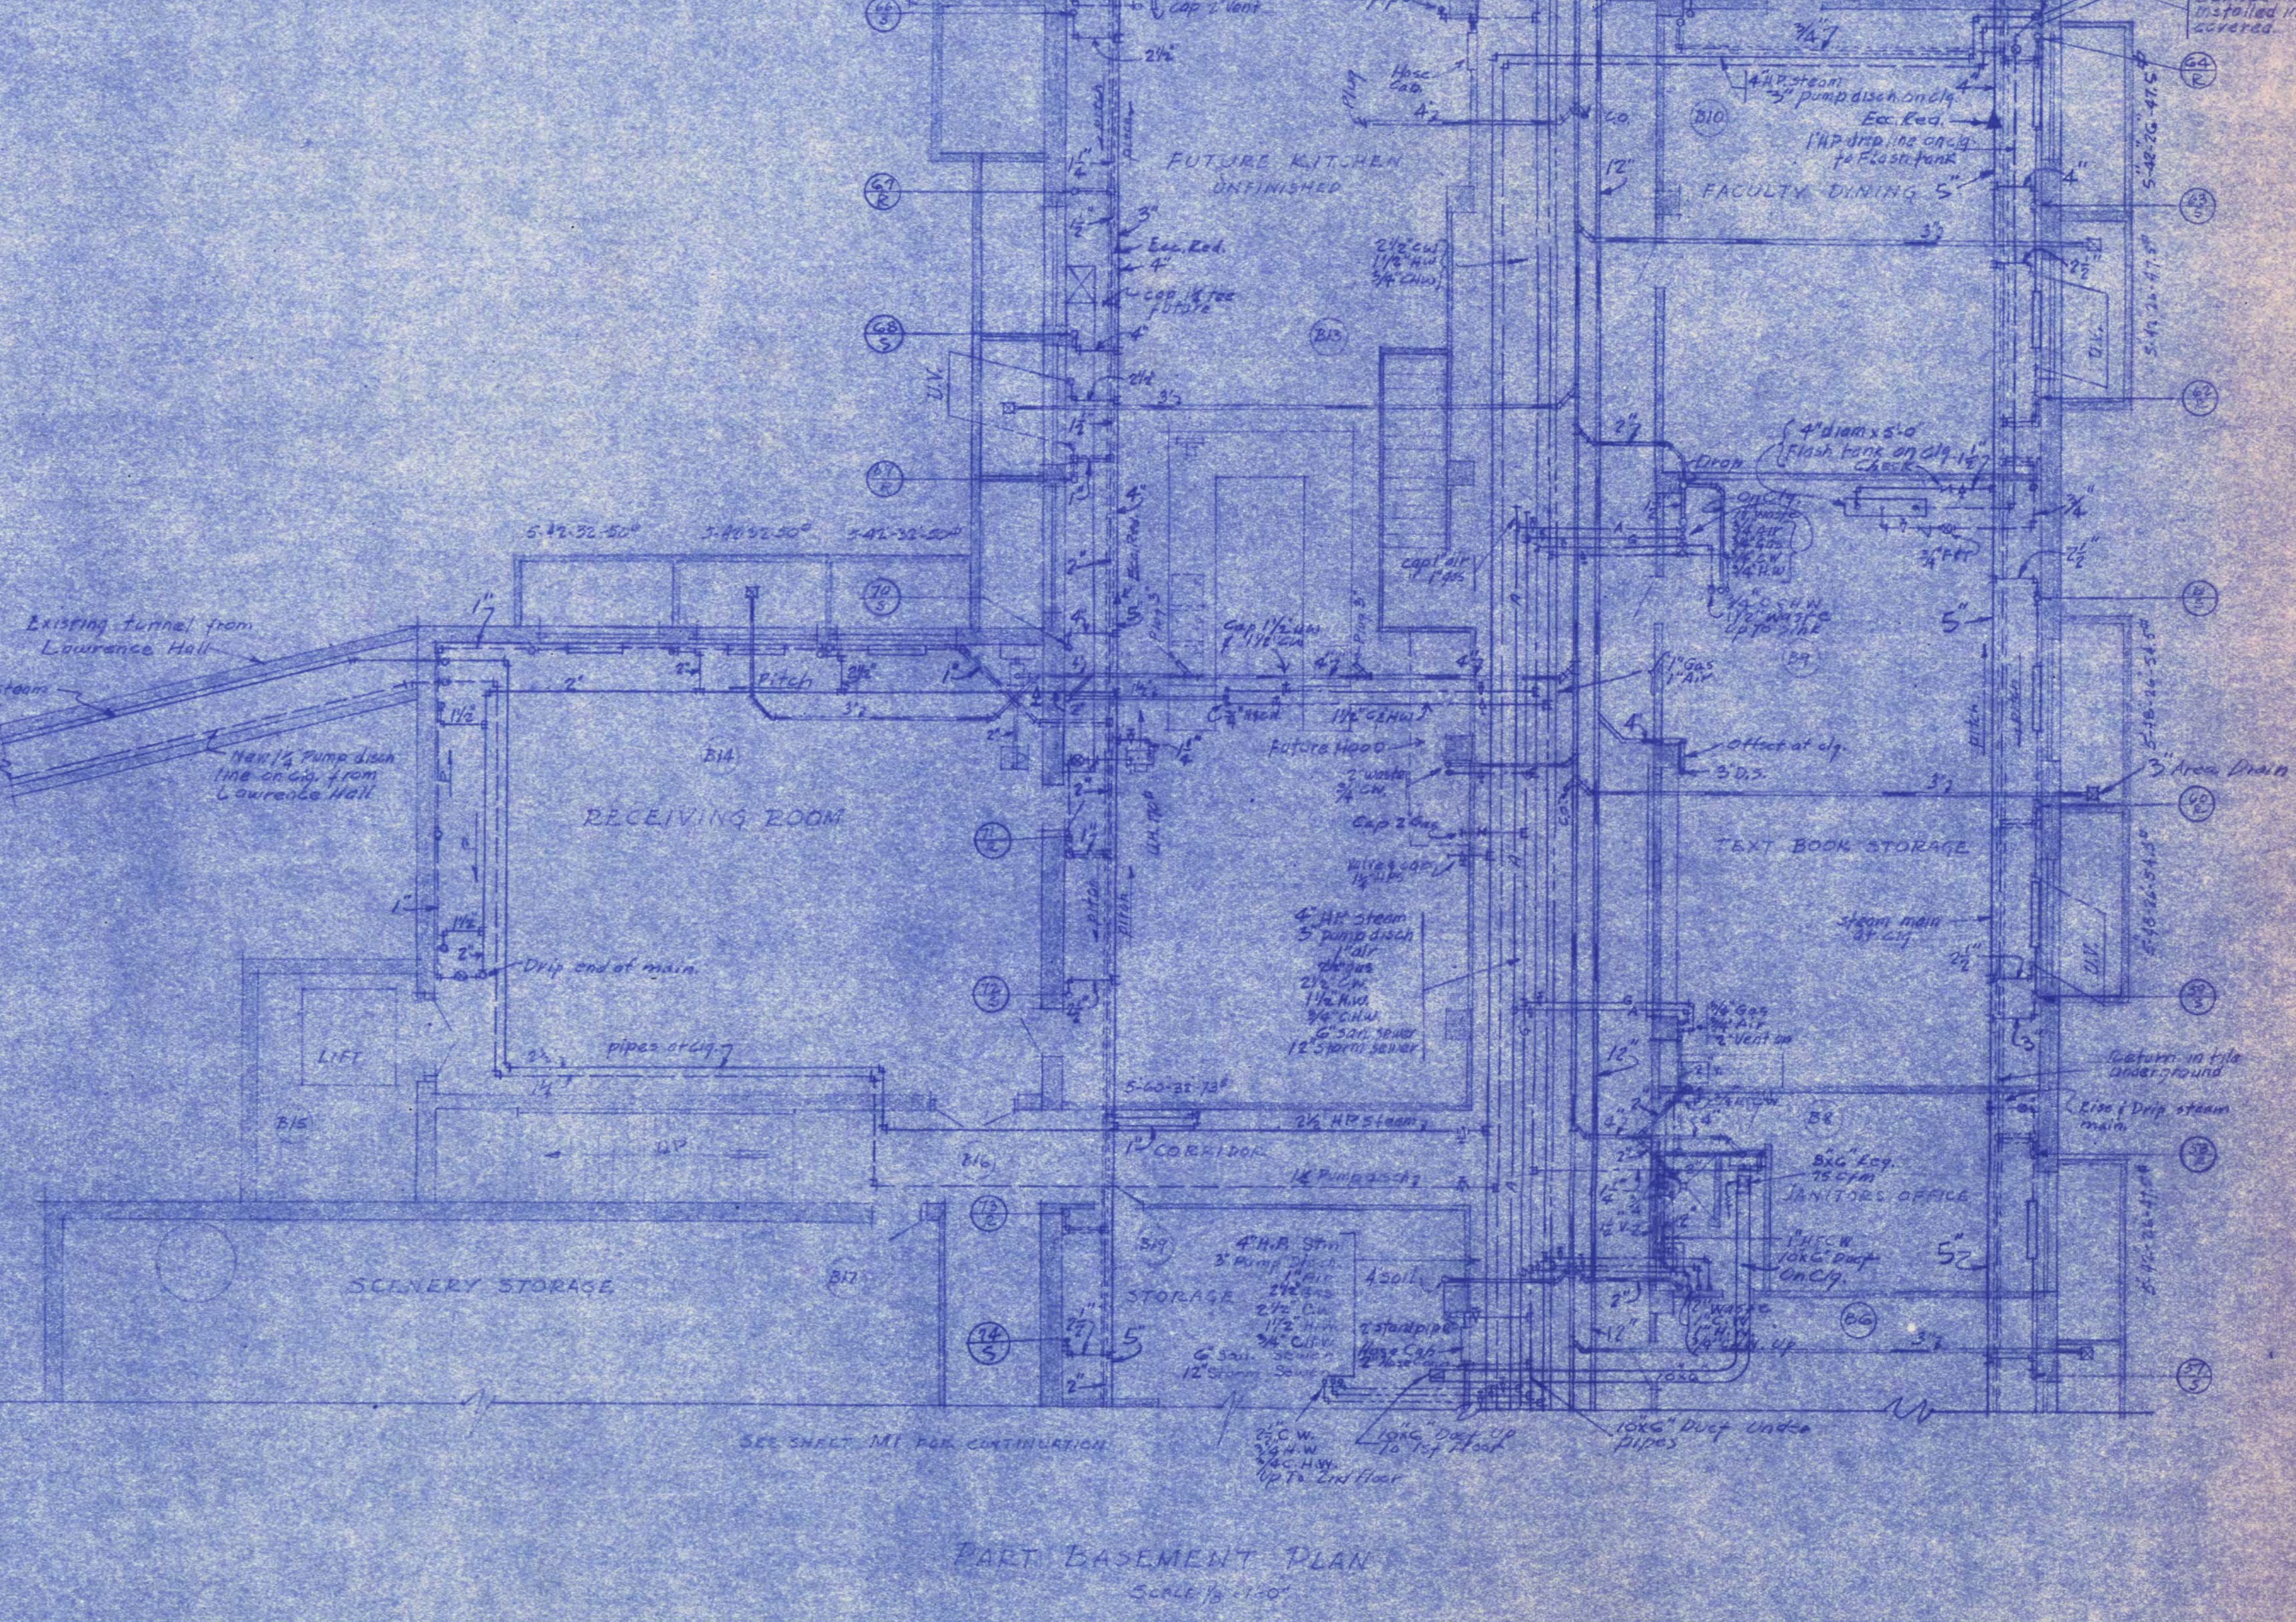


PART BASEMENT PLAN
SCALE 1/8" = 1'-0"

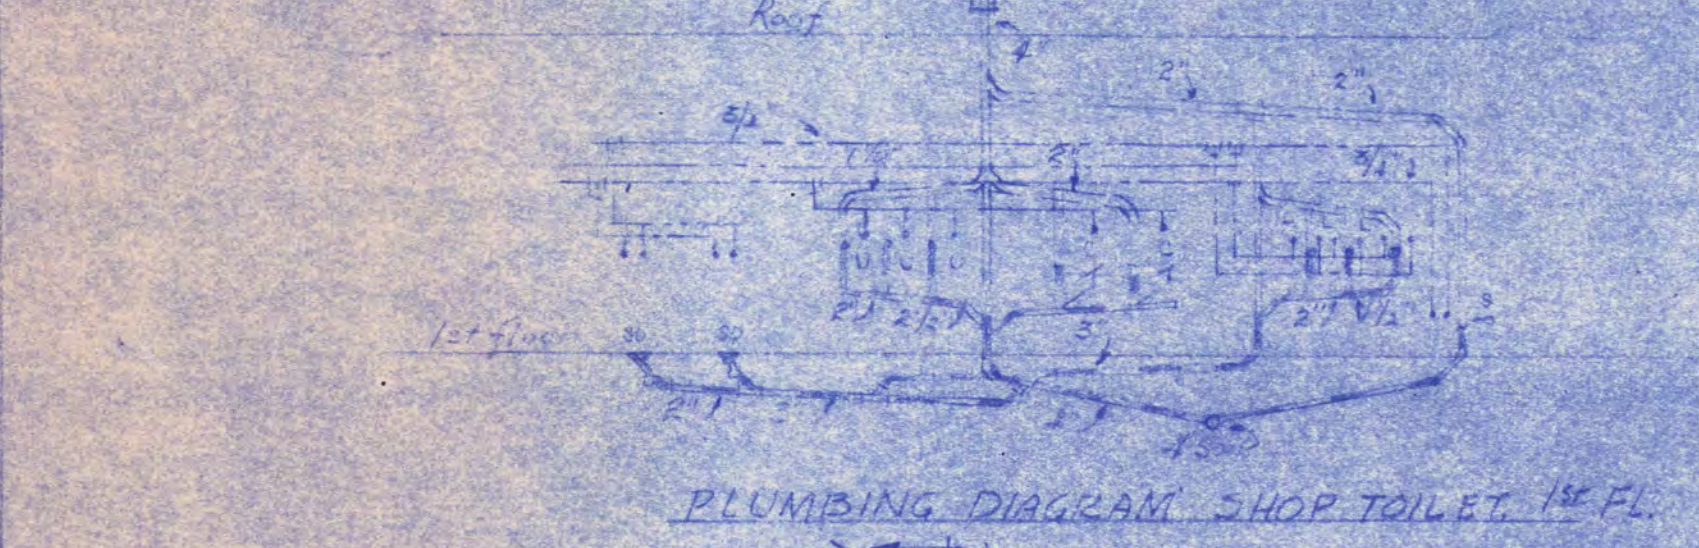


PLUMBING DIAGRAM SHOP TOILET

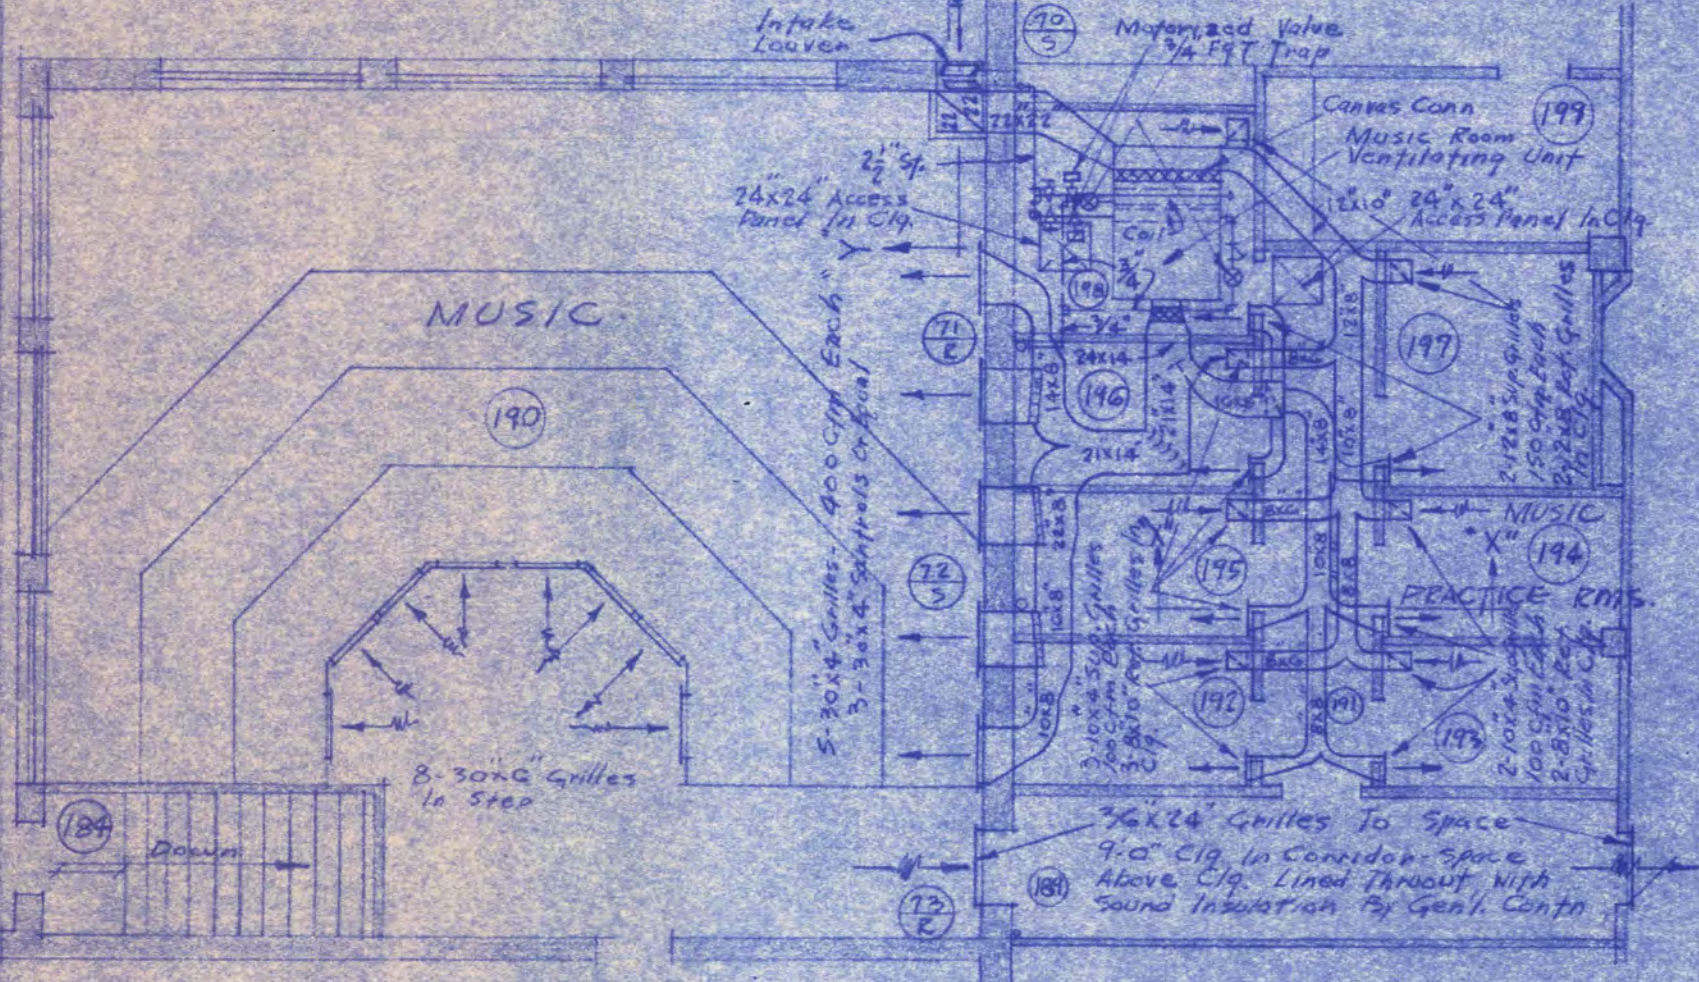


PLAN
SCALE 1/8" = 1'-0"

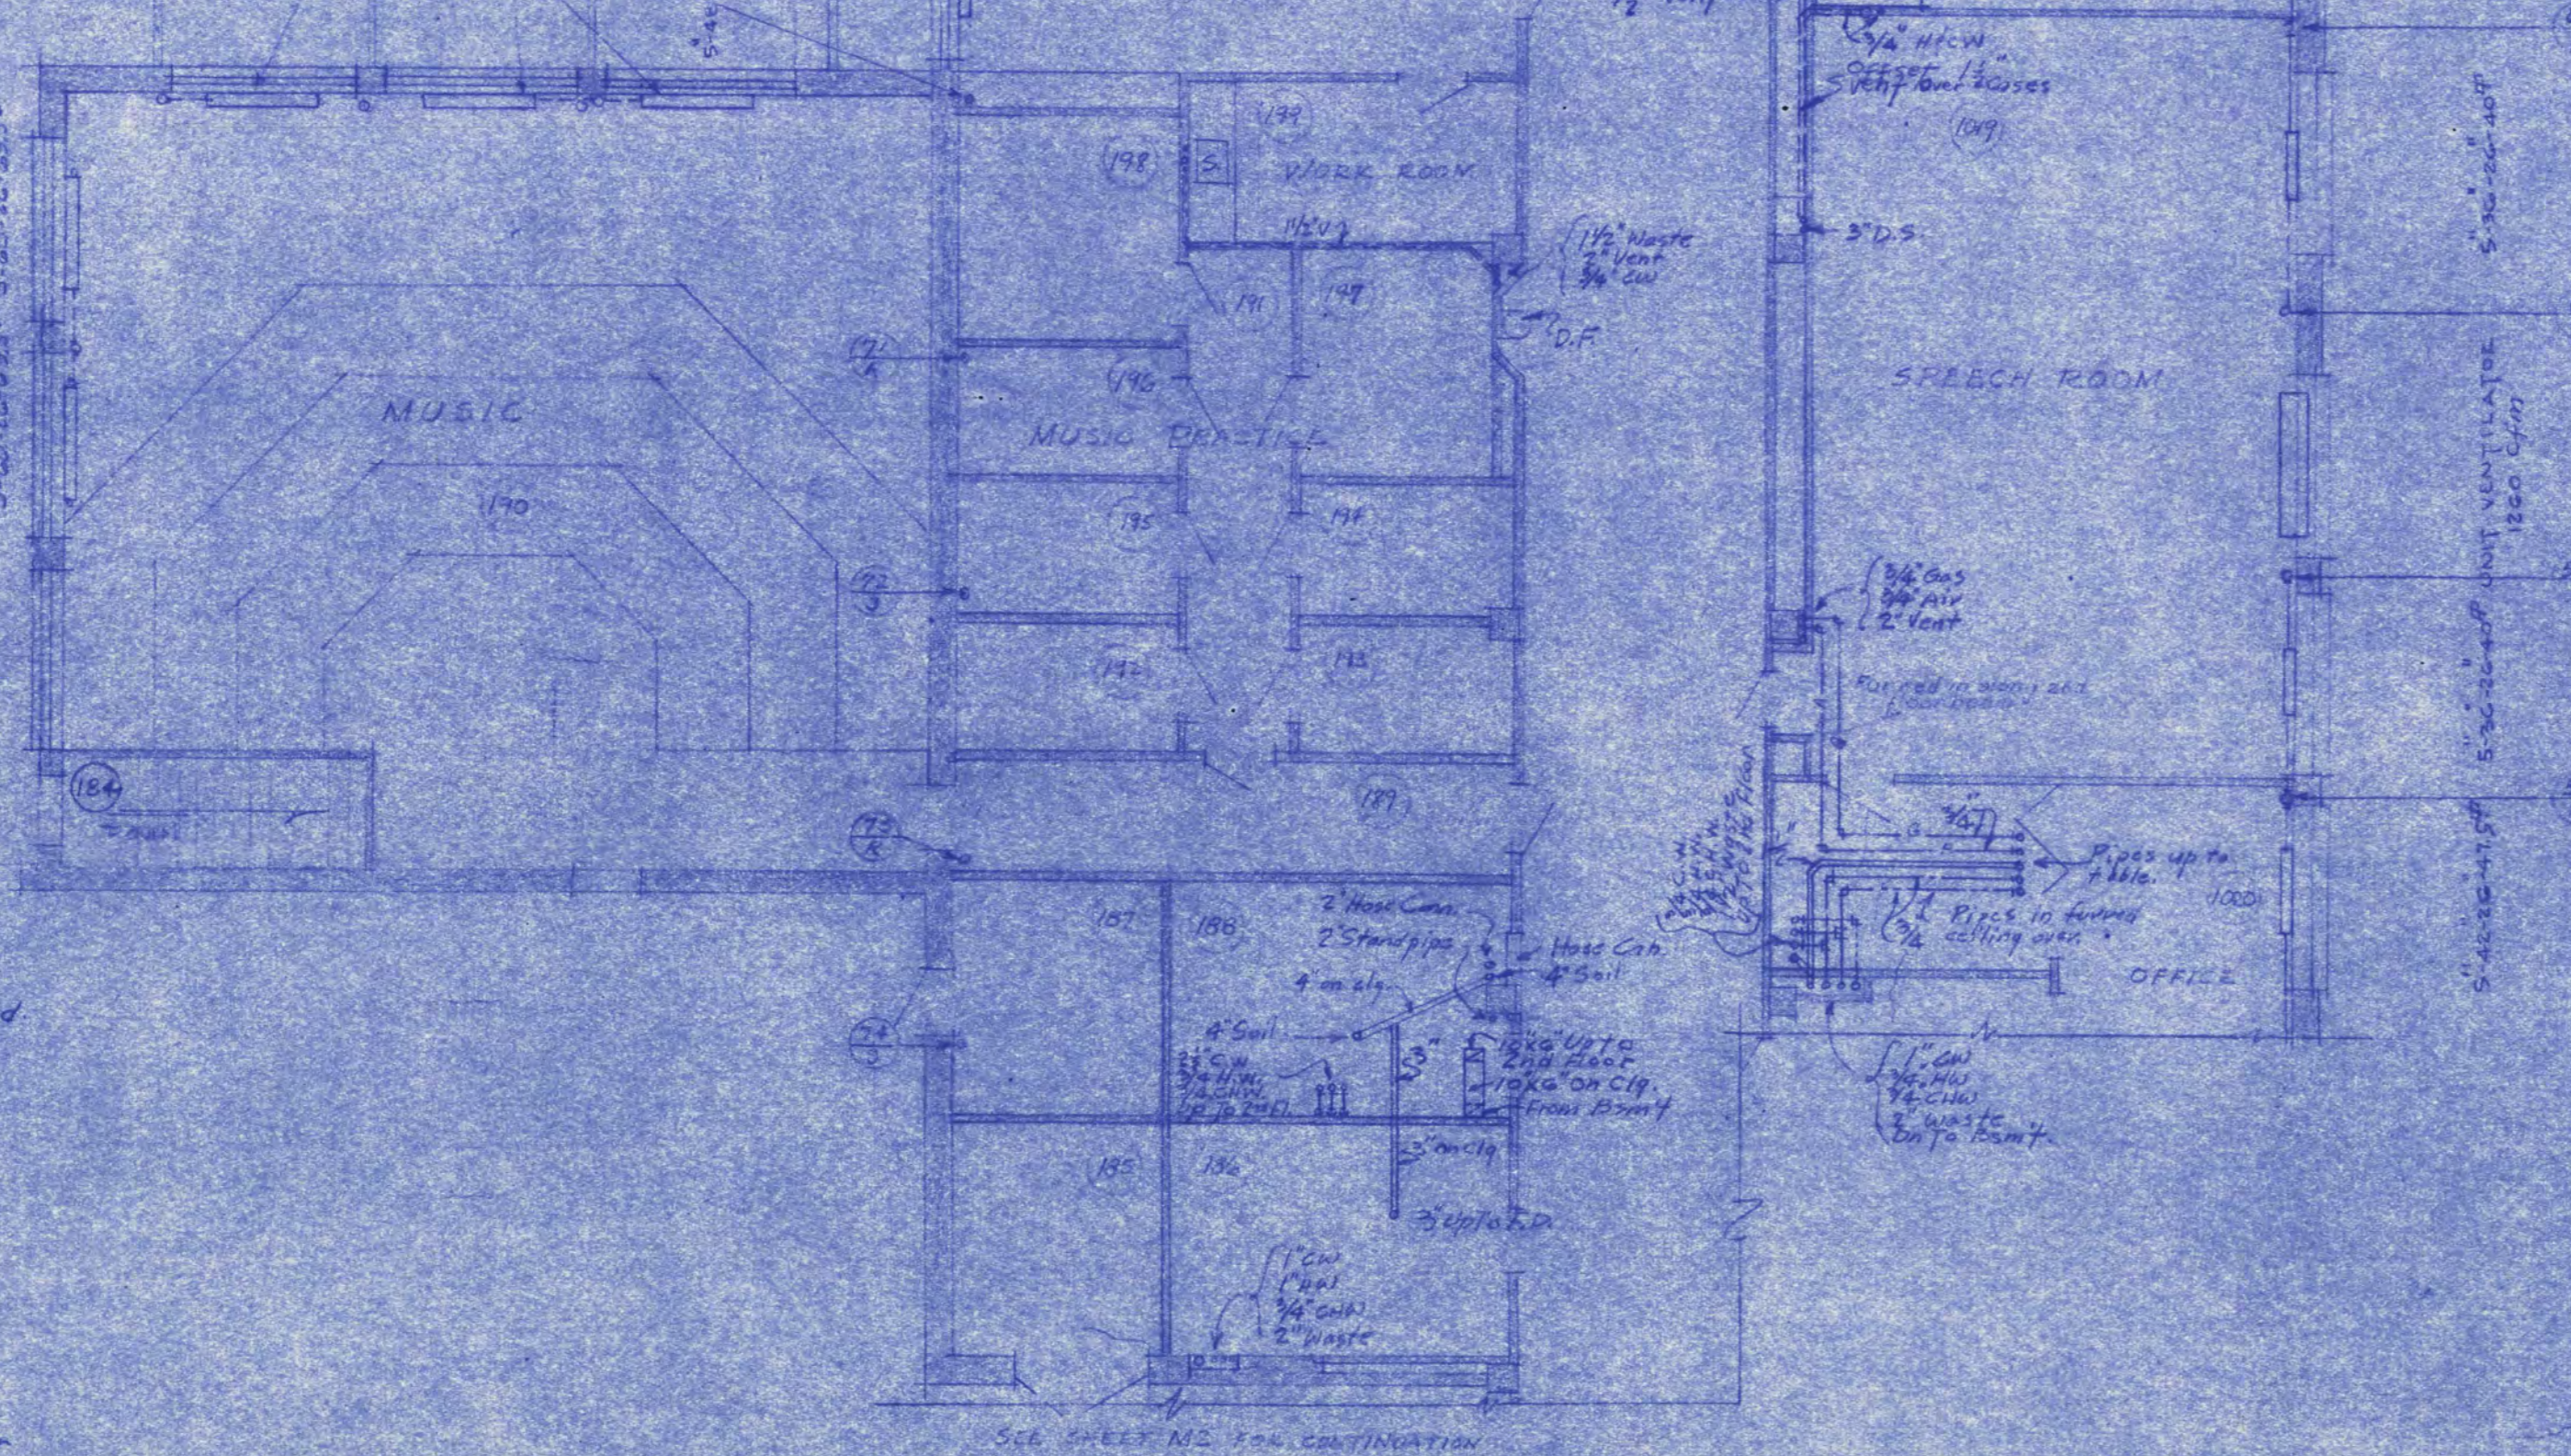

PART FIRST FLOOR PLAN
SCALE 1/8" = 1'-0"

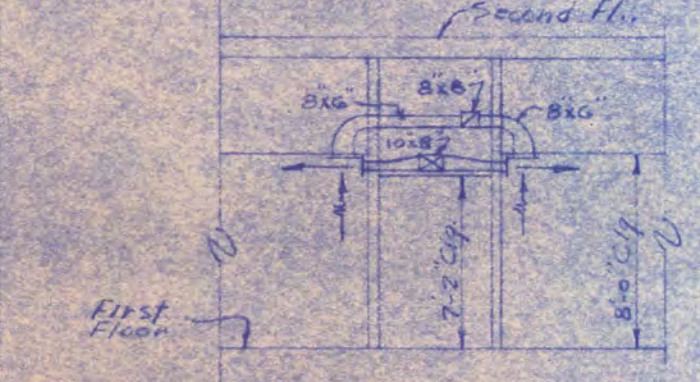


SECTION XX
SCALE 1/8" = 1'-0"

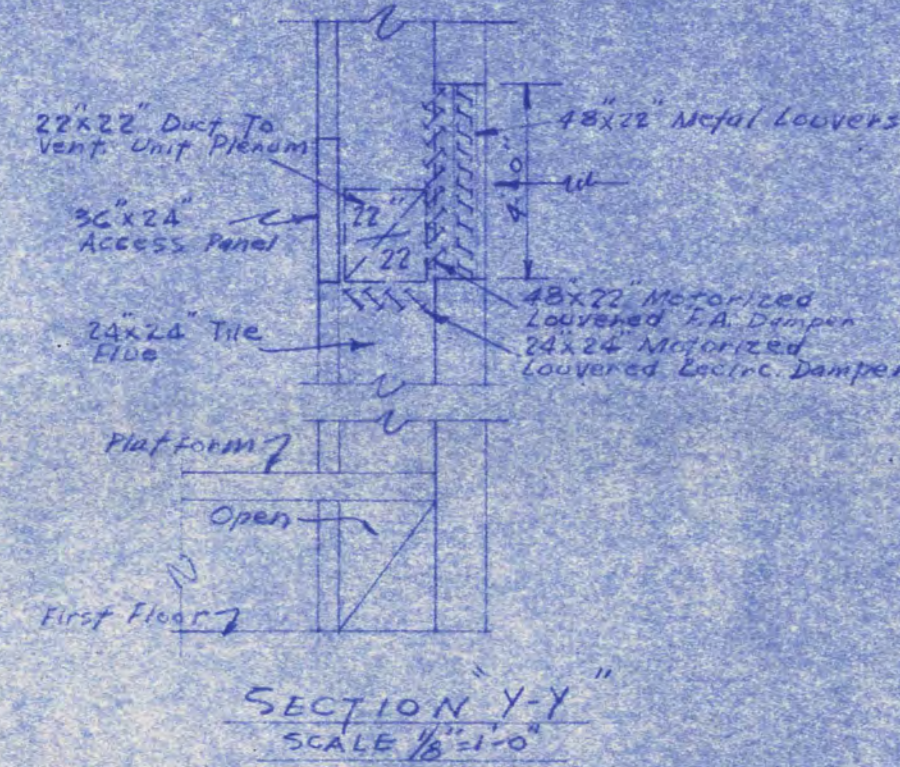

SECTION Y-Y
SCALE 1/8" = 1'-0"



VENTILATION OF MUSIC ROOM AND MUSIC PRACTICE ROOMS
SCALE 1/8" = 1'-0"

MAIN BUILDING & AUDITORIUM FOR STATE TEACHERS COLLEGE SAINT CLOUD, MINN.		SHEET NO. M-6
DEPT. OF ADMINISTRATION, STATE OF MINNESOTA SAINT CLOUD, MINN.		
DATE APR 24 1924	ARCHITECTS L. C. PRINCE & FRANK JACKSON ASSOCIATE ARCHITECTS SAINT CLOUD, MINN.	CONTRACT NO. 339
REVISIONS APPROVED BY PRESIDENT OF STATE TEACHERS COLLEGE BOARD	ENGINEERS GARDNER & MOORE ENGINEERS SAINT PAUL, MINNESOTA LEBLANC & COMPANY CONSULTING ARCHITECTS & ENGINEERS SAINT CLOUD, MINN.	
DRAWN BY APPROVED BY COMMISSIONER OF ADMINISTRATION	AS AUTHORIZED SIGNATURE	

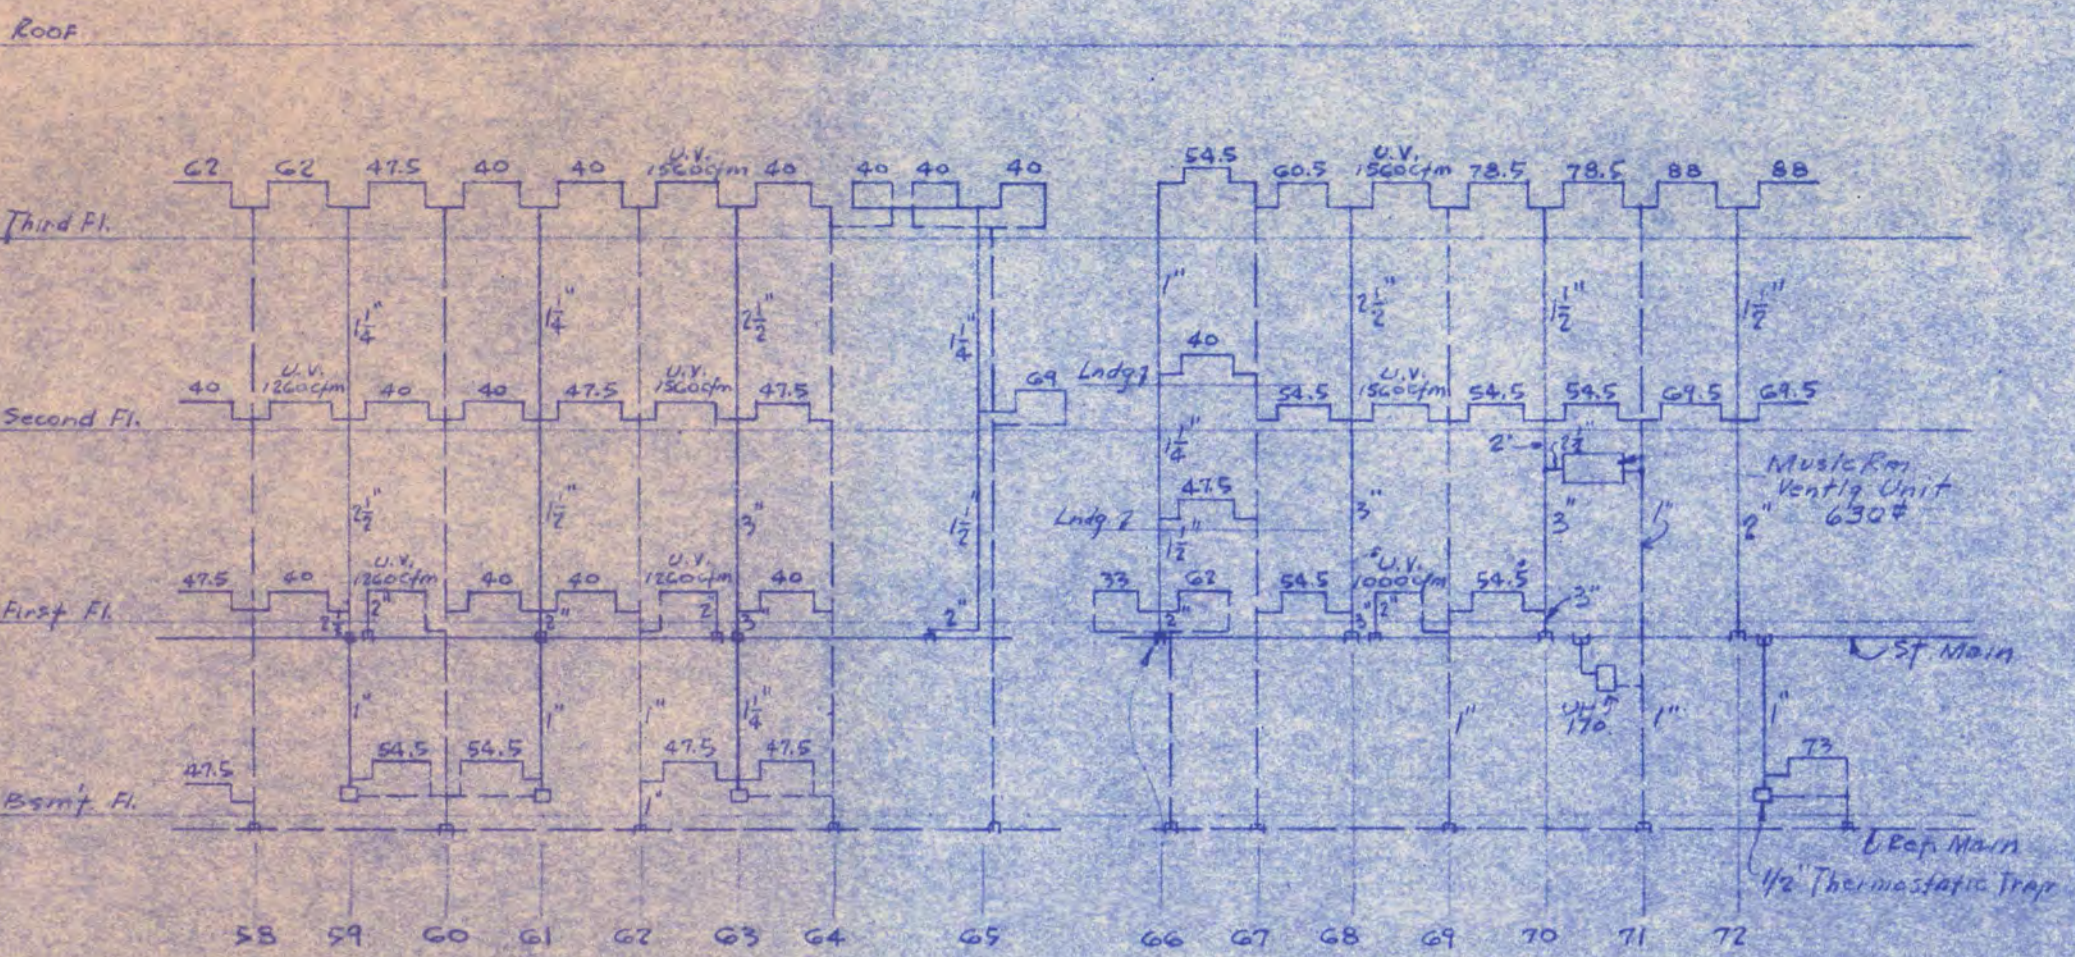


NOTE: 1. All radiators from 111A
 1/2" Thermastic trap
 2. All Radiator Units 1/2" Outlet Above


HEATING RISER DIAGRAM
 No SCALE

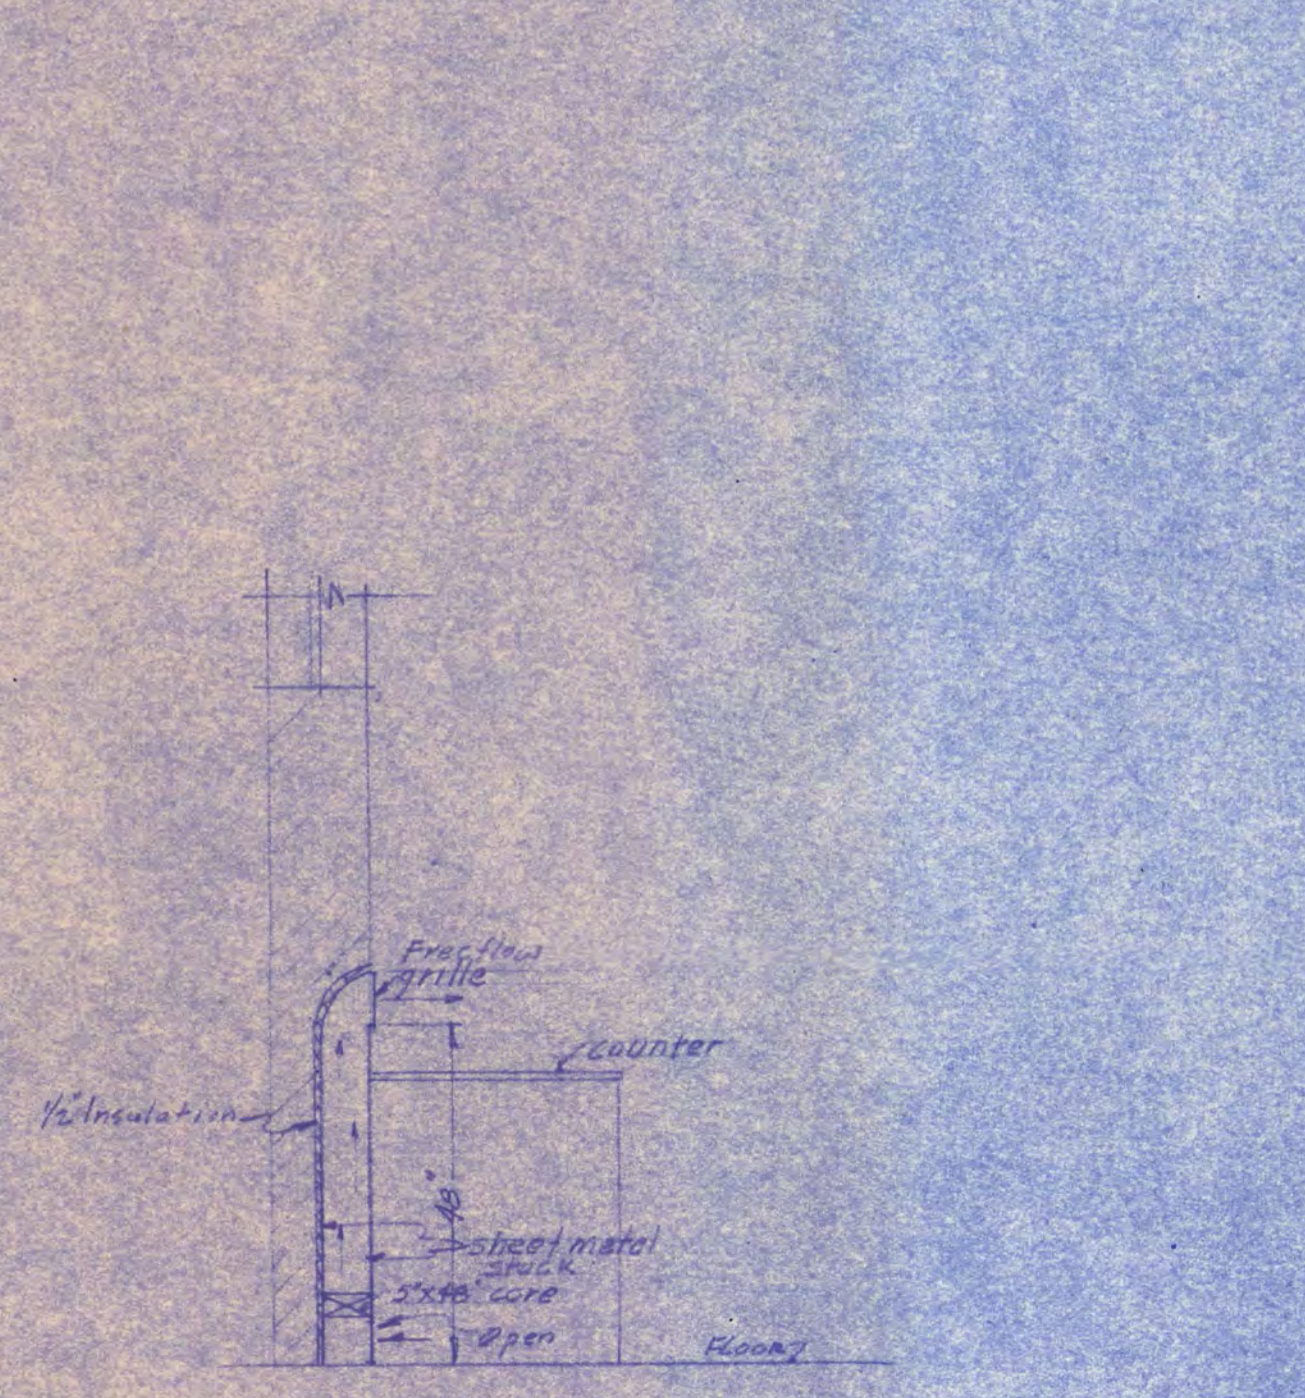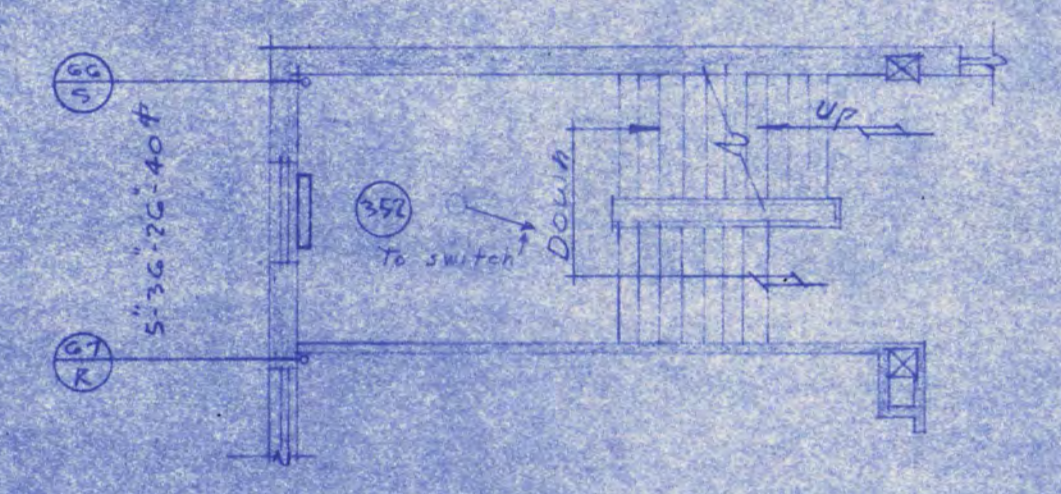


DETAIL OF SPECIAL SHEET METAL CABINET
 FOR RADIATORS 1ST FLOOR SHOP SECTION
 SCALE 1/2" = 1'-0"

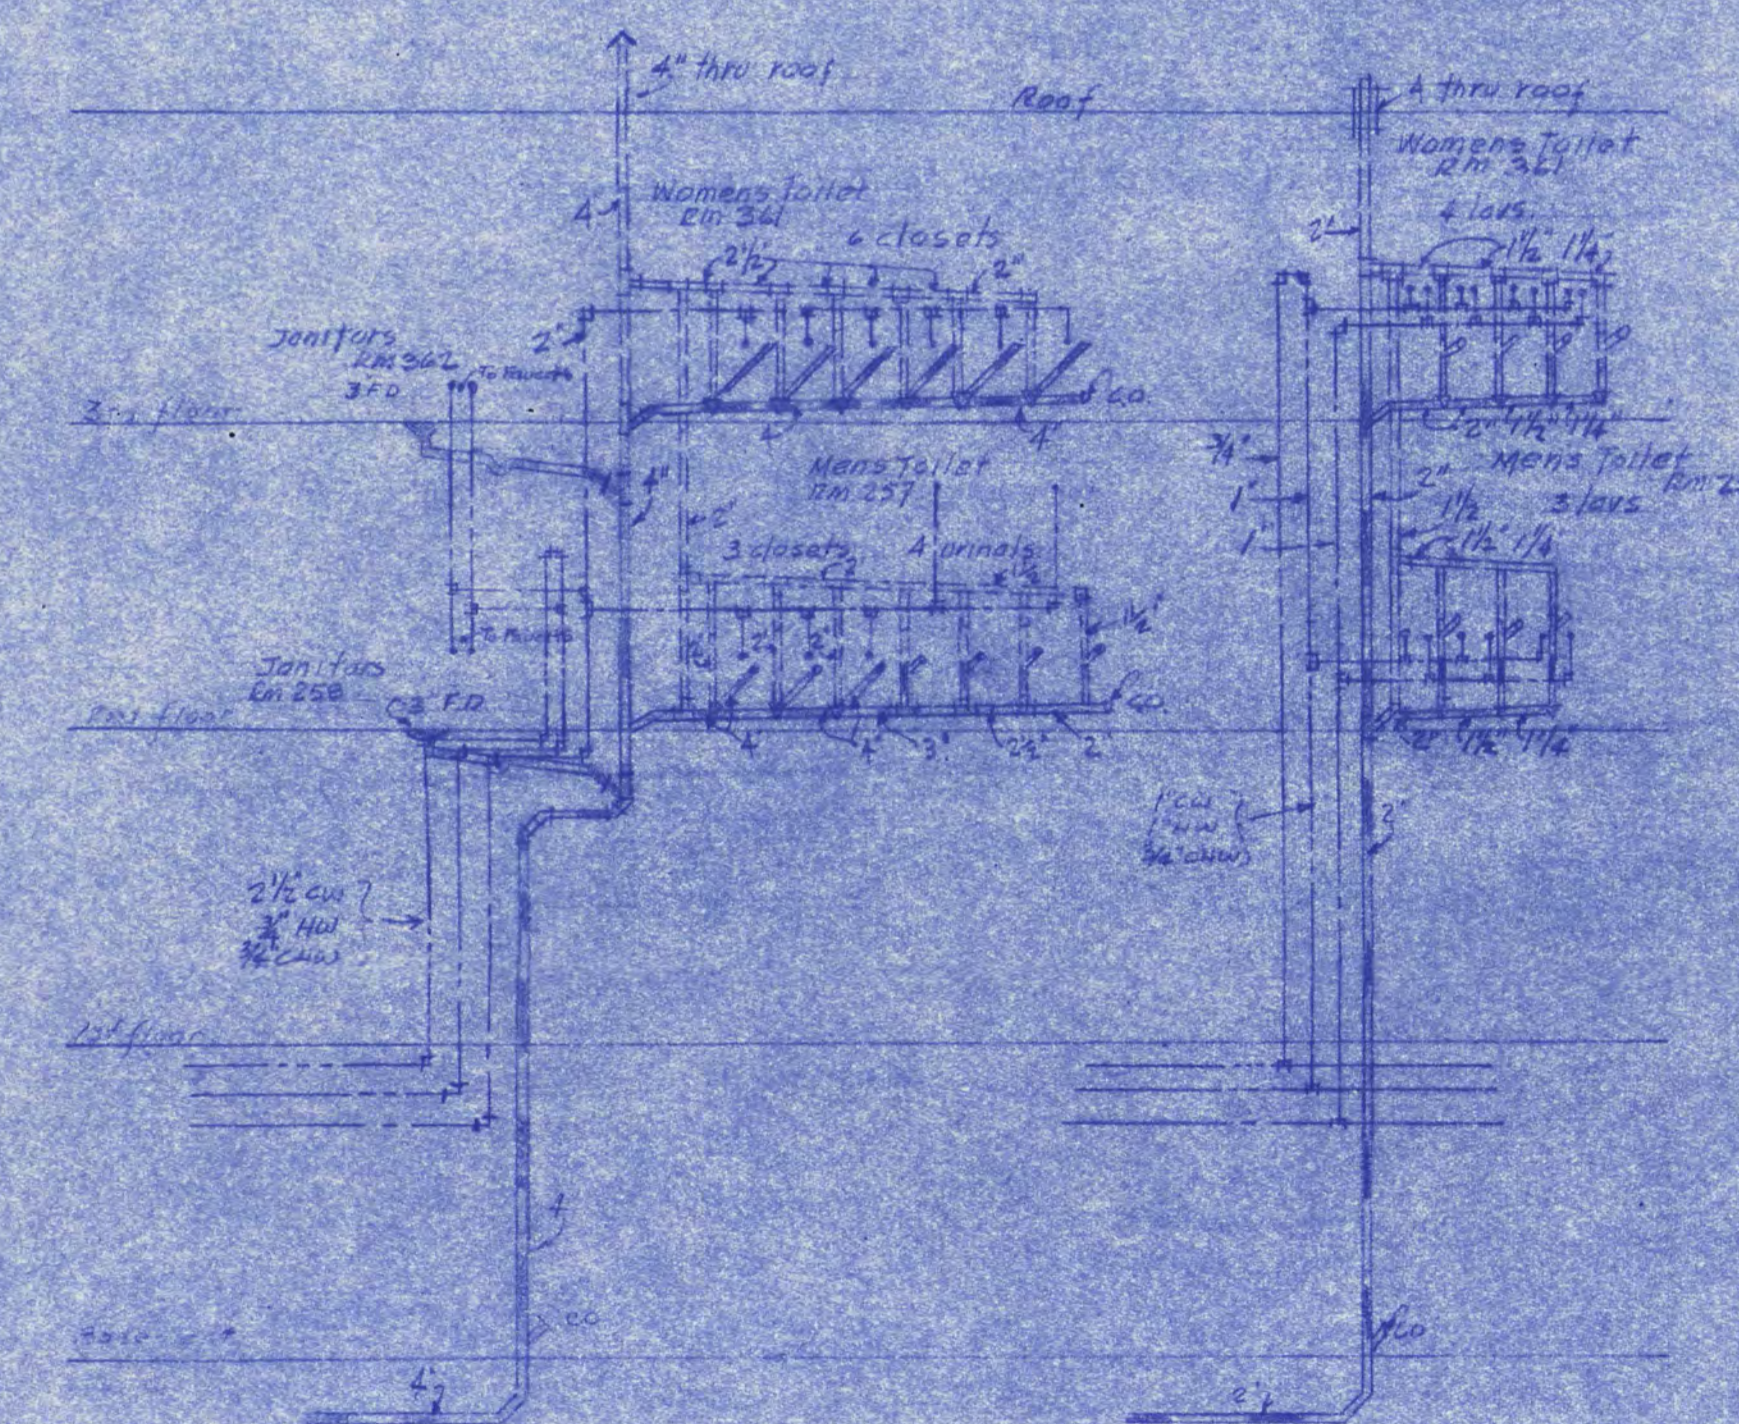

PLUMBING RISER DIAGRAM
 TOILET ROOMS 257-321
 No SCALE

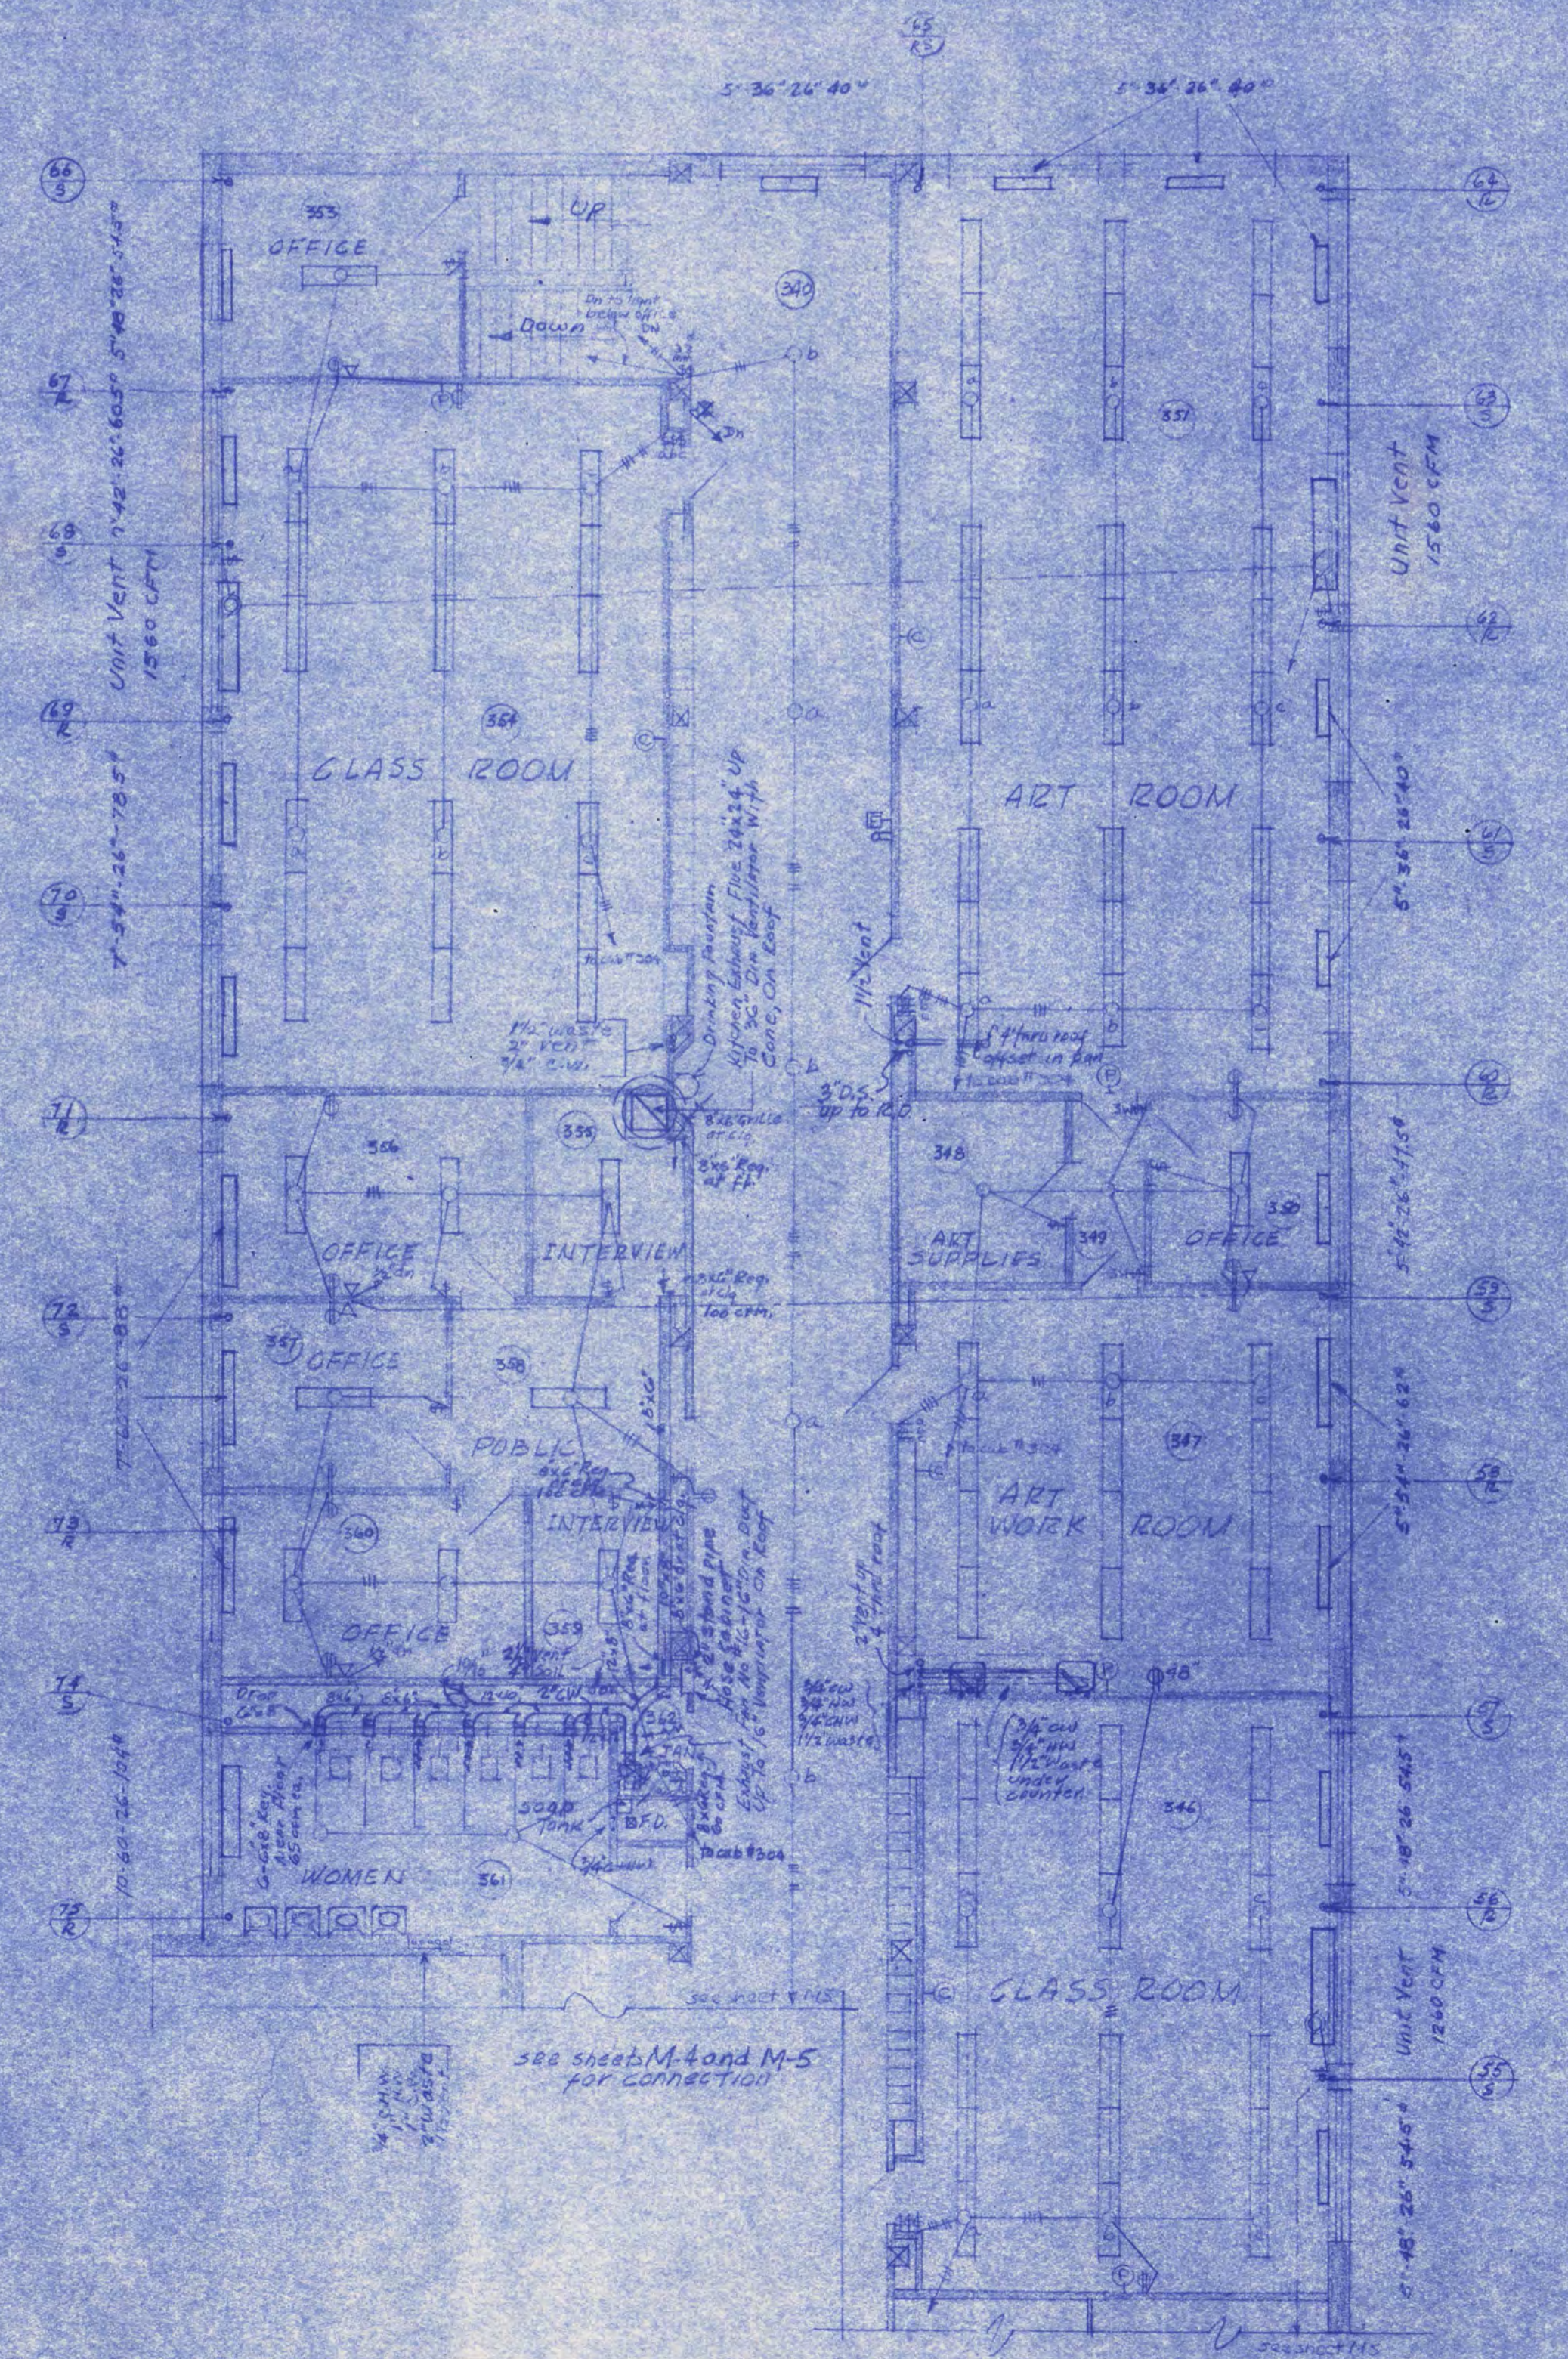


PART THIRD FLOOR PLAN
 SCALE 1/8" = 1'-0"

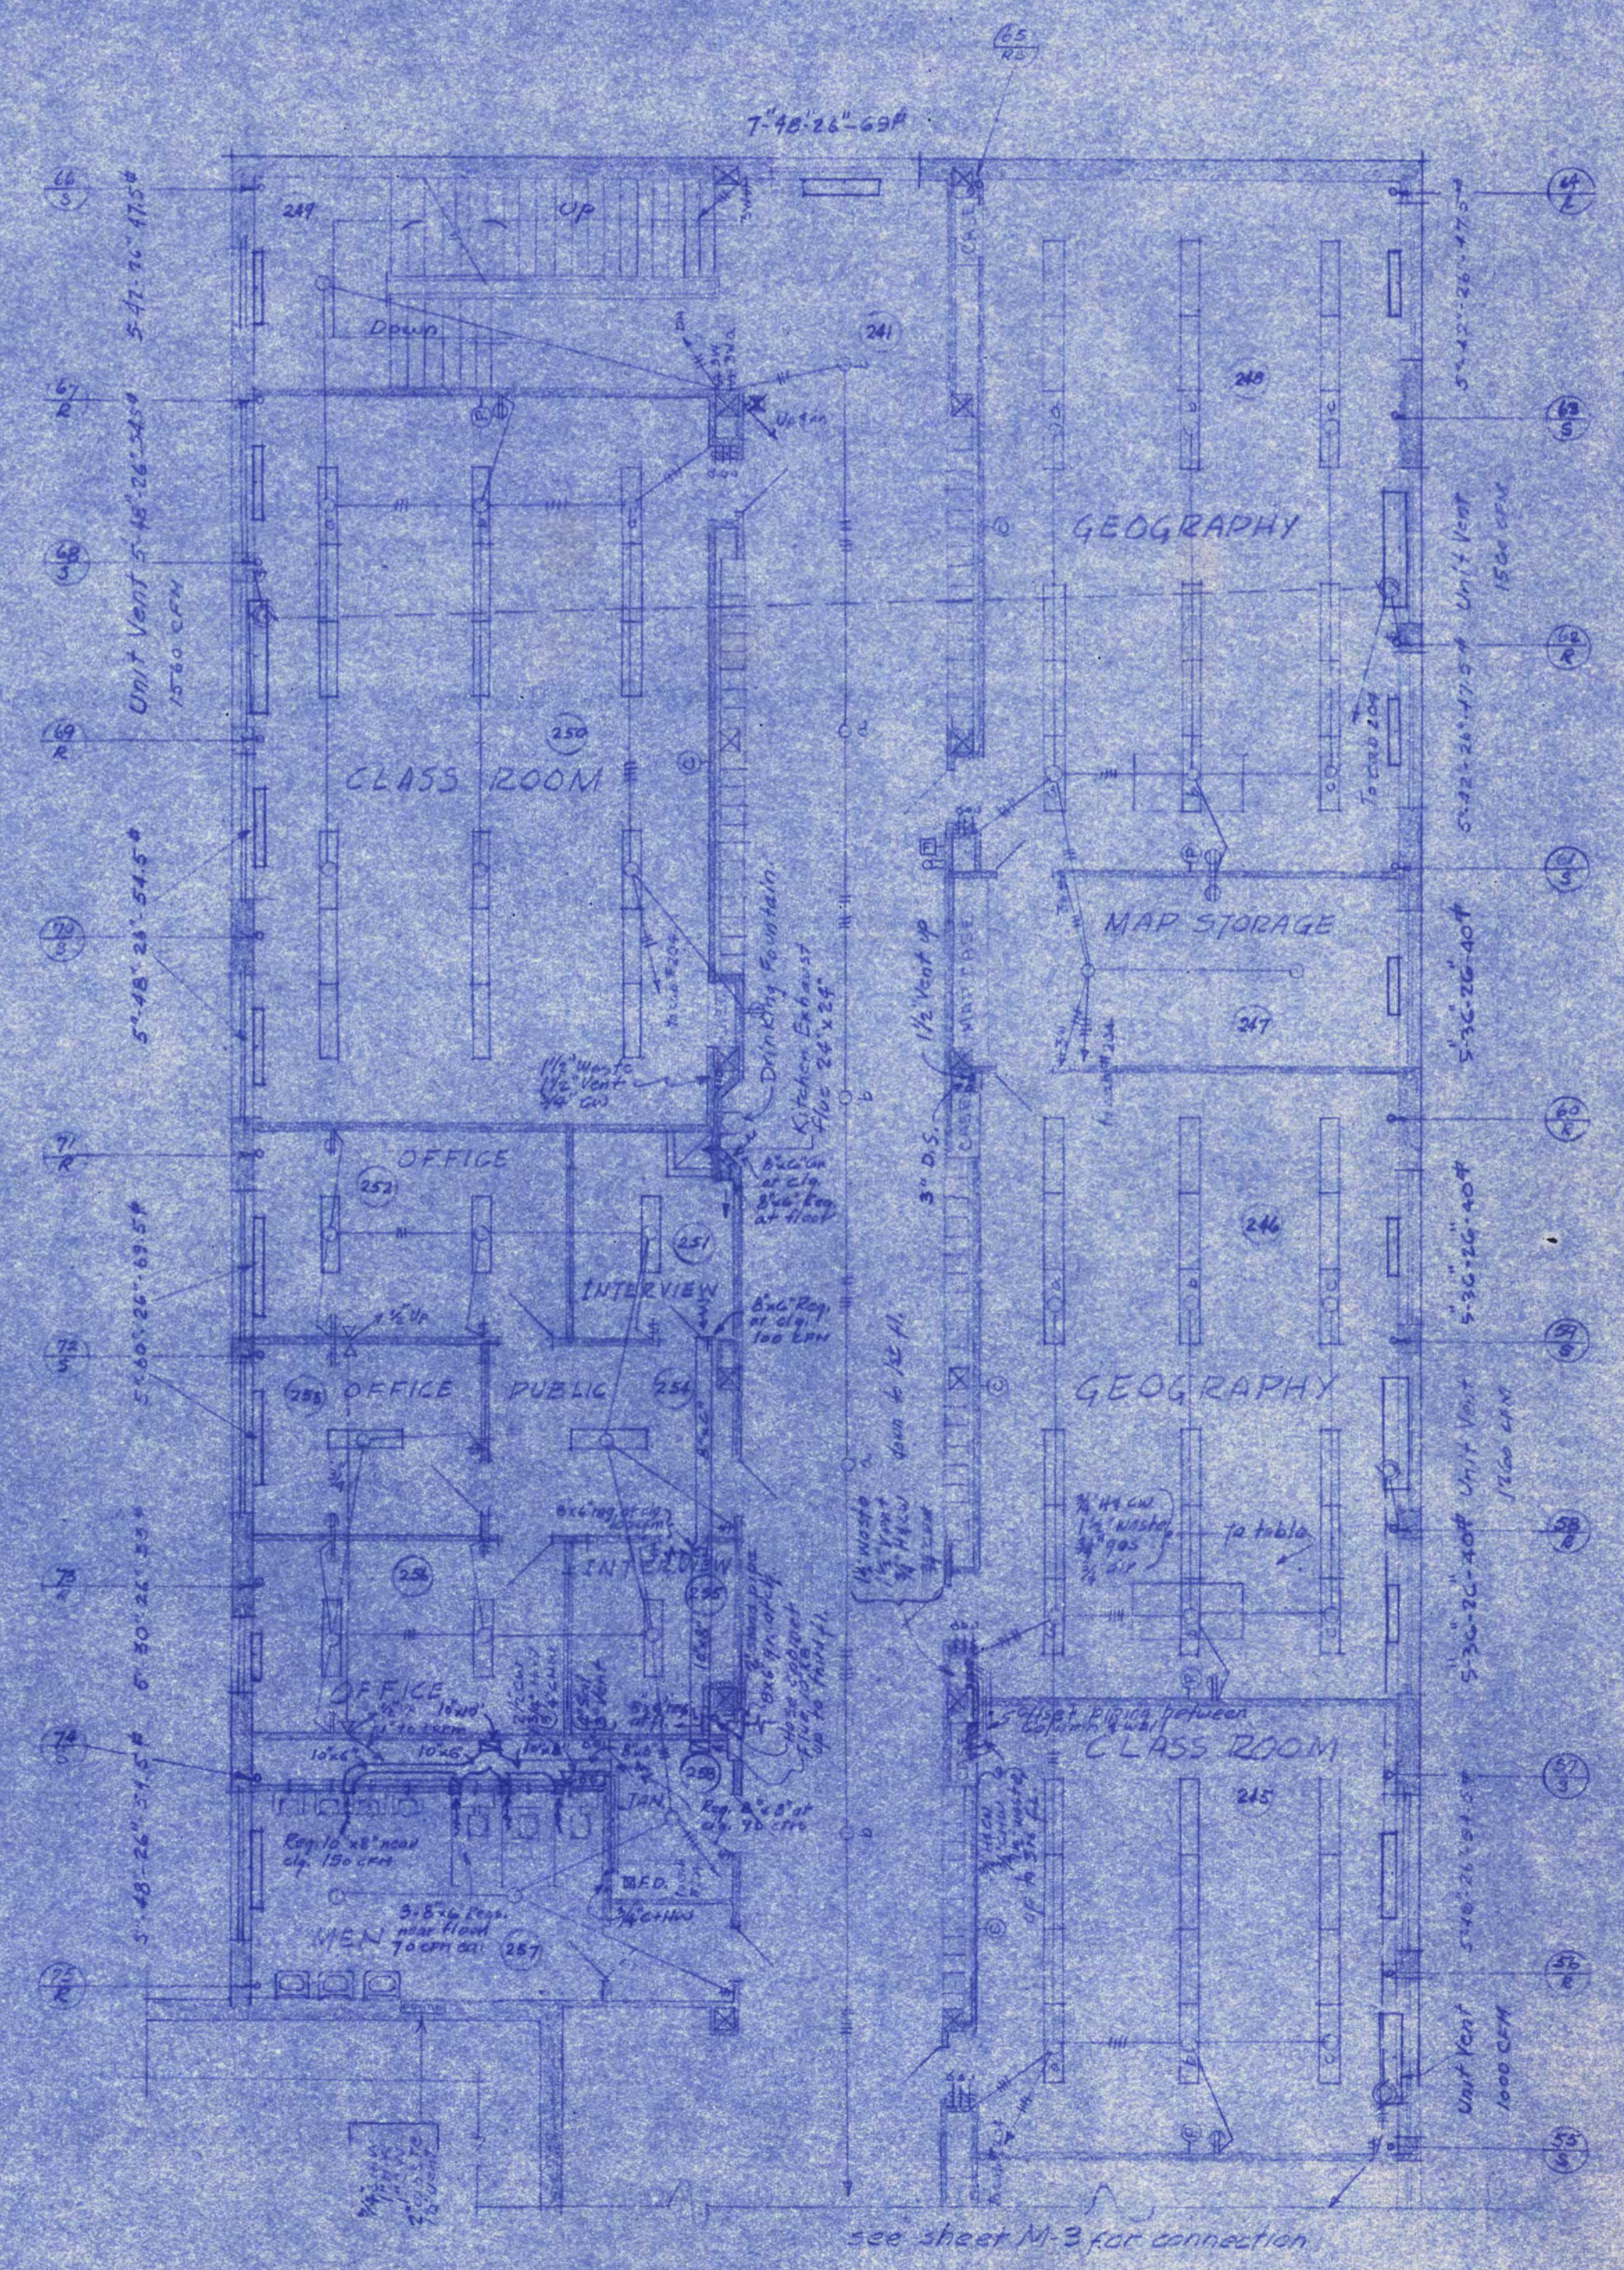


PART SECOND FLOOR PLAN
 SCALE 1/8" = 1'-0"


MAIN BUILDING & AUDITORIUM FOR STATE TEACHERS COLLEGE SAINT CLOUD, MINN.			
DEPT. OF ADMINISTRATION, STATE OF MINNESOTA SAINT PAUL, MINN.			
DATE	DESIGNED BY	ASSOCIATE ARCHITECTS	SHEET NO.
FEB 8 1943	SAUNMAN & BROSIE - ENGINEERS	SAINT PAUL, MINN.	M-7
REVISED	APPROVED BY	PRICE OF ST. CLOUD TEACHERS COL.	
	ELLENBERG & CO. CONSULTING ARCHITECTS & ENGINEERS		
DRAWN BY	APPROVED BY	CONTRACT NO.	
B	CHAS. G. ADMINISTRATION	338	
	AN AUTHORIZED SIGNATURE		

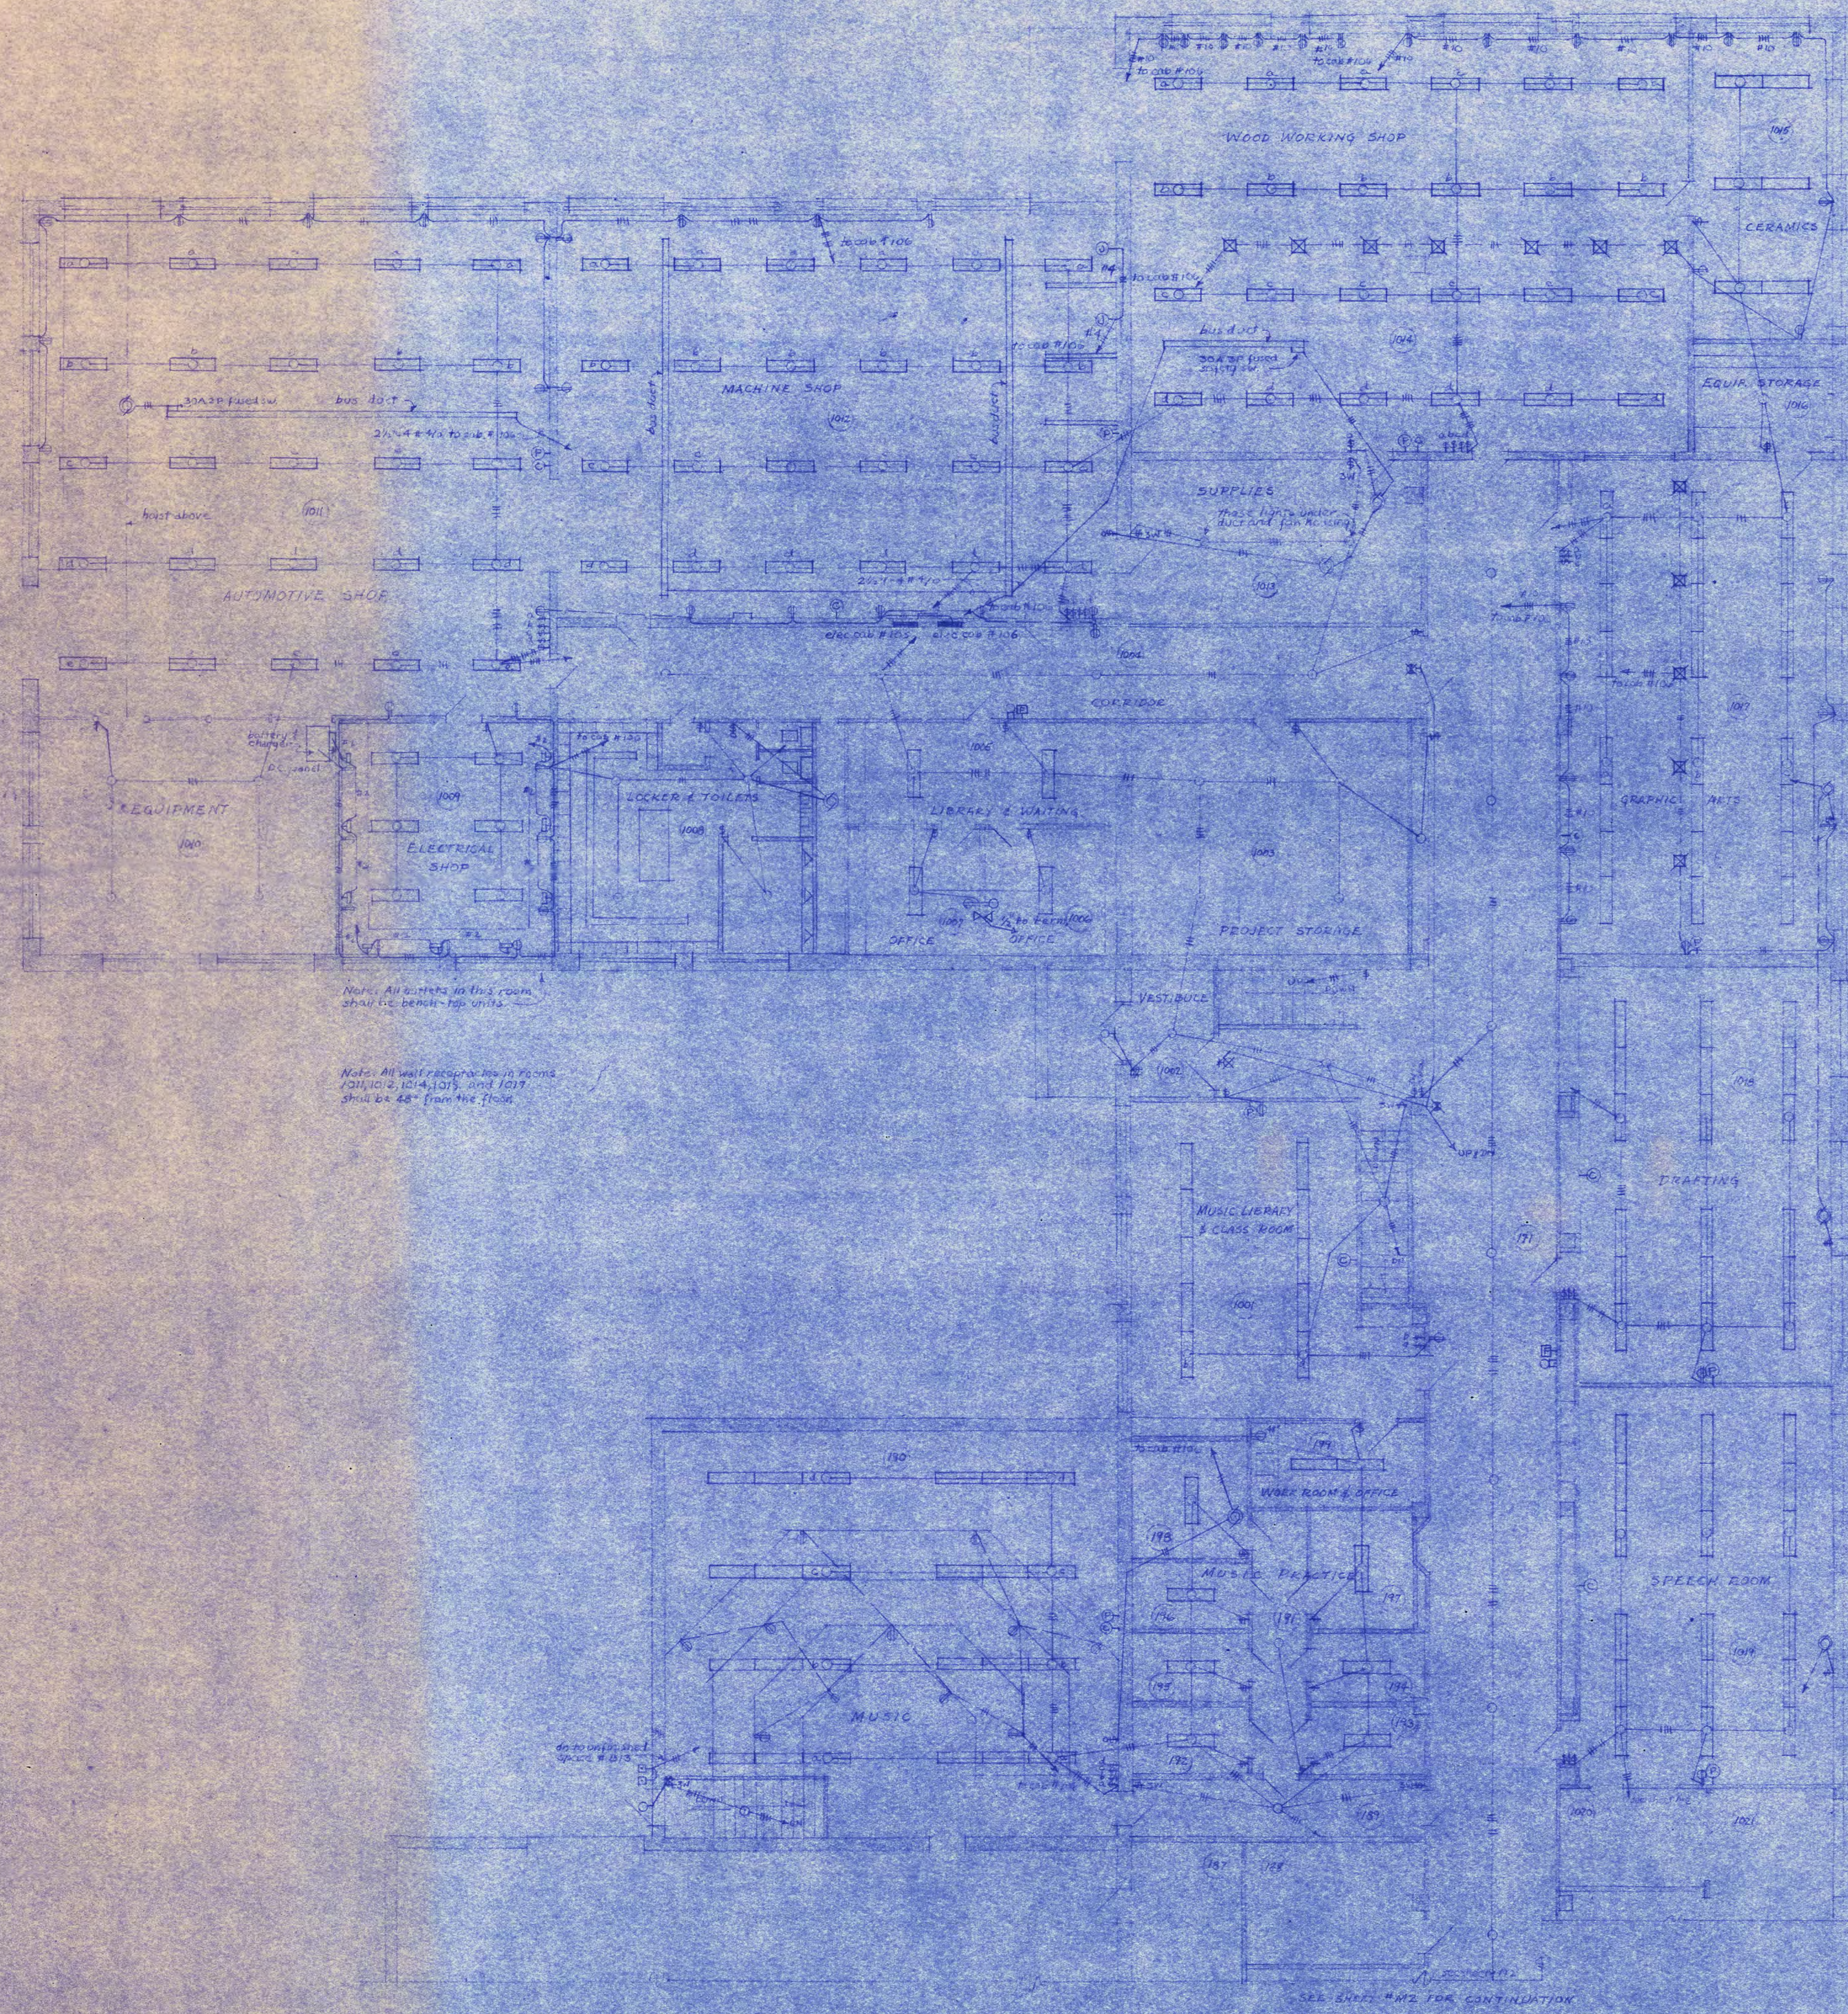

PART FIRST FLOOR PLAN
SCALE 1/8" = 1'-0"

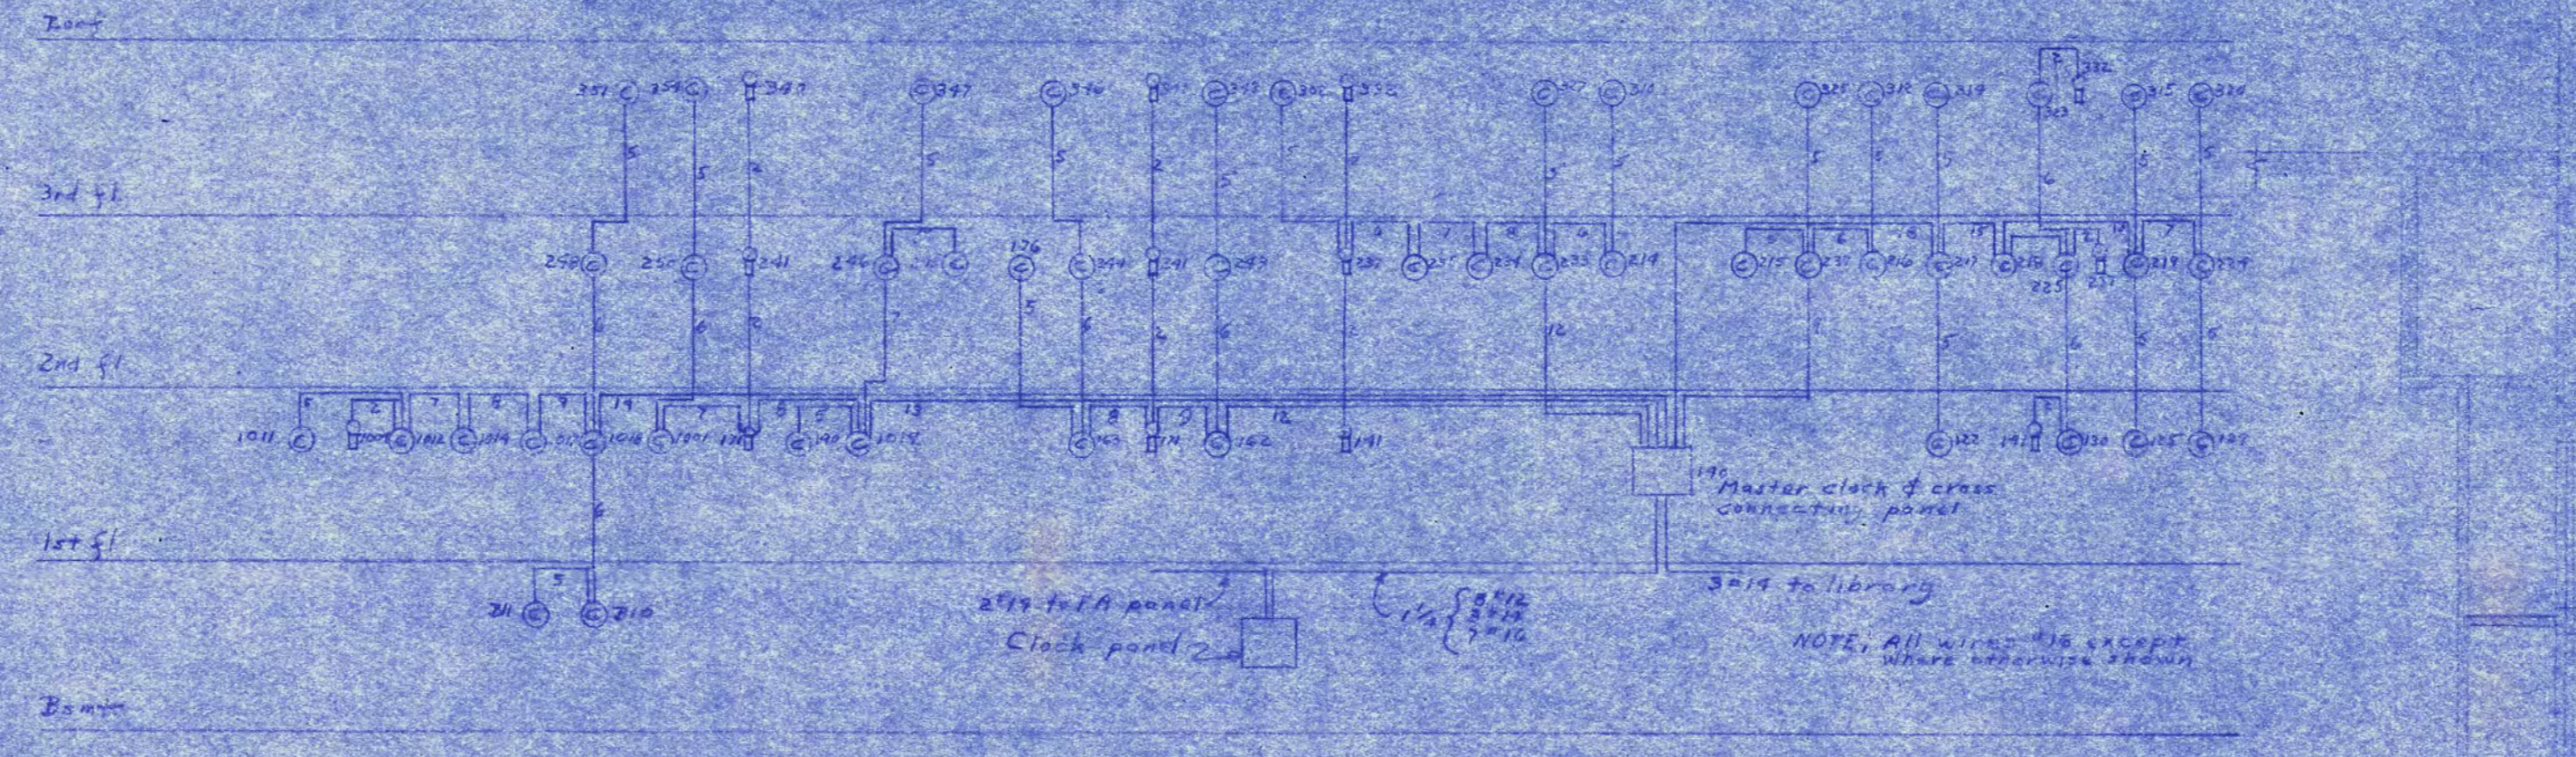

CLOCK & SIGNAL WIRING DIAGRAM
SCALE 1/8" = 1'-0"

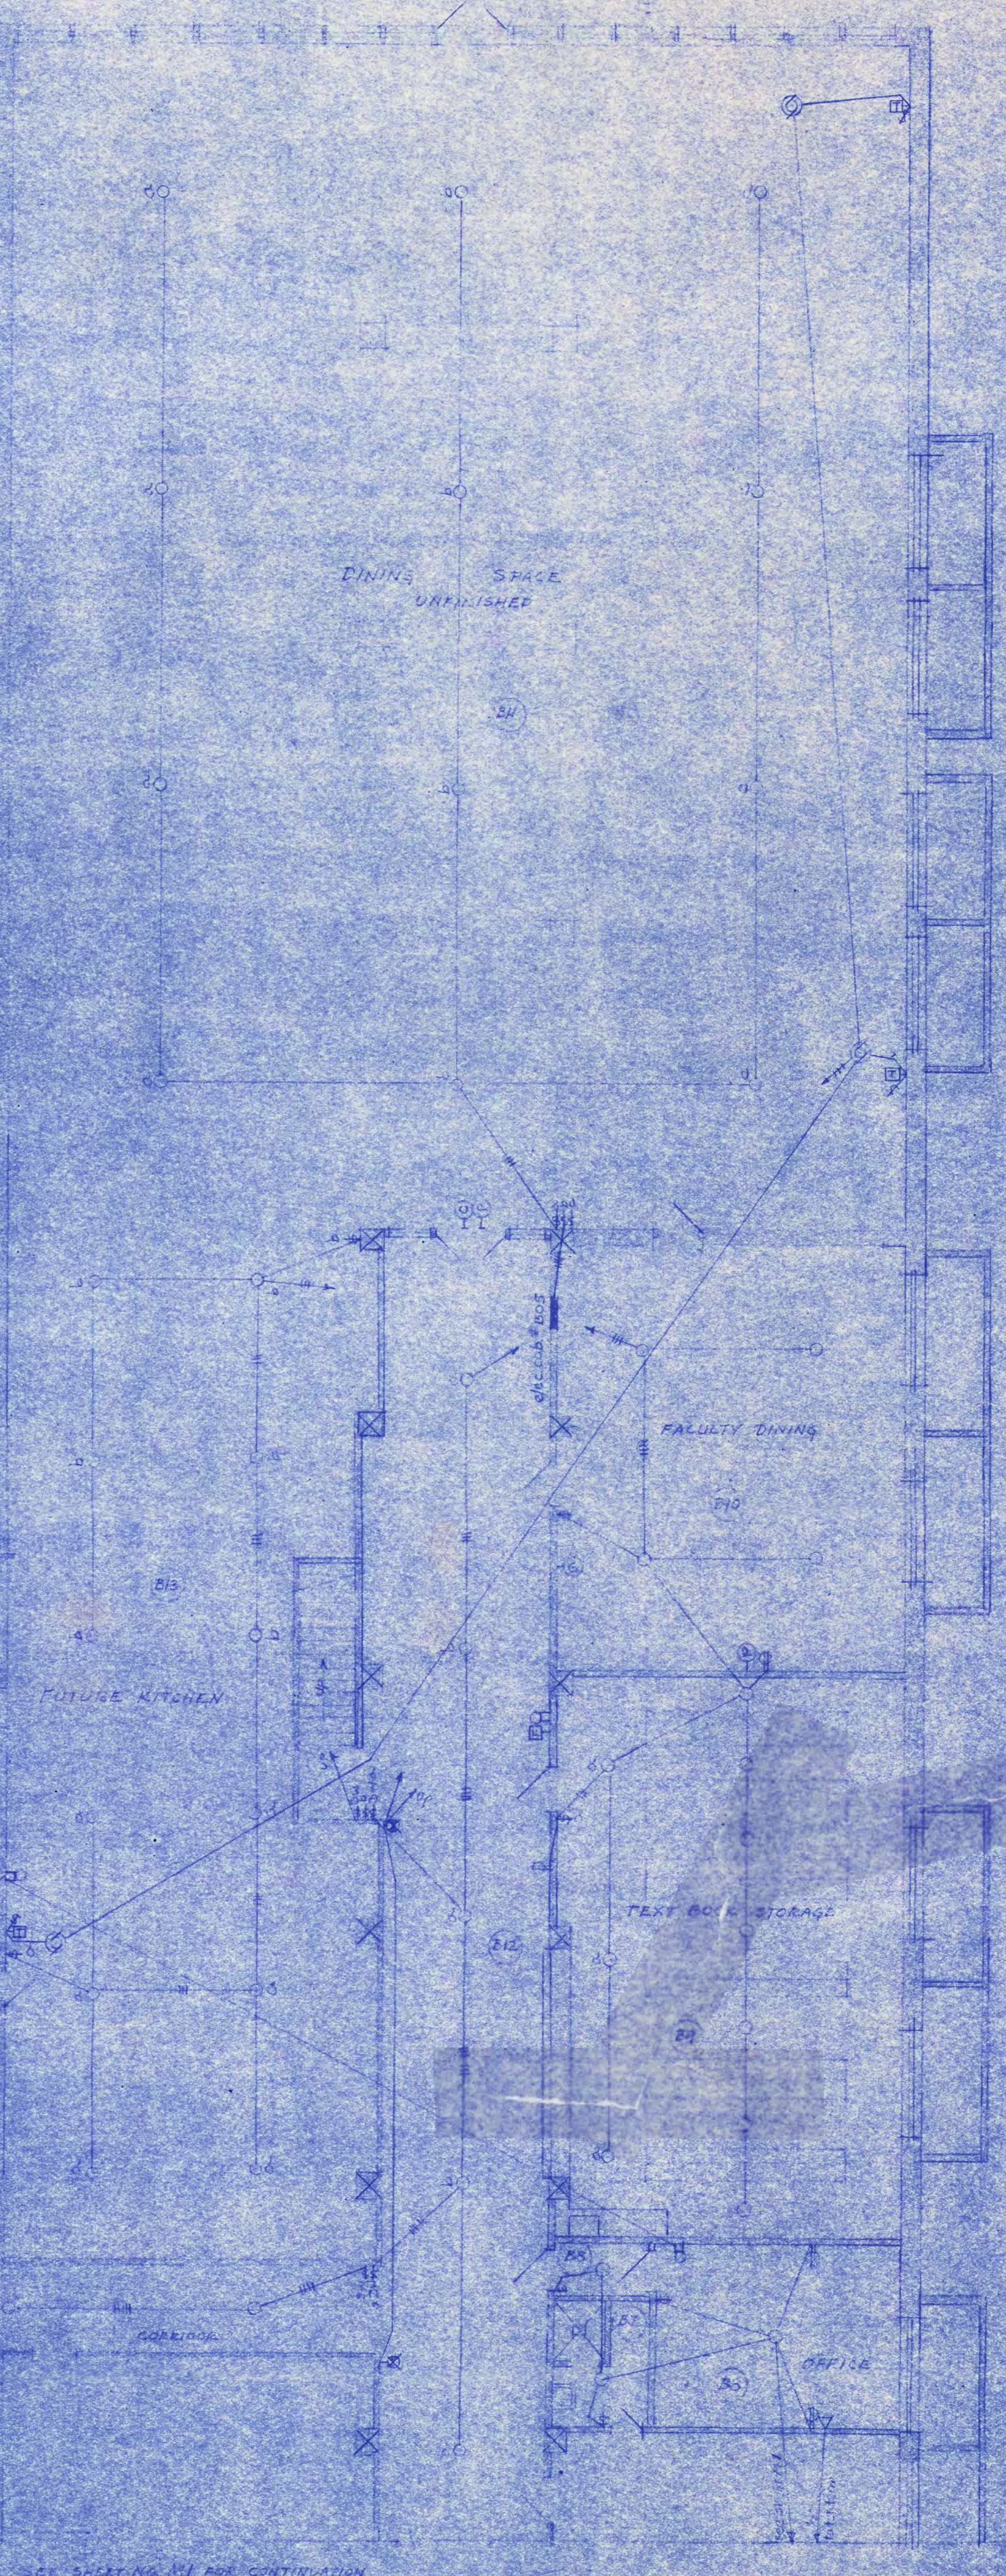

PART BASEMENT PLAN
SCALE 1/8" = 1'-0"

MAIN BUILDING & AUDITORIUM STATE TEACHERS COLLEGE SAINT CLOUD, MINN. DEPT. OF ADMINISTRATION, STATE OF MINNESOTA			
DATE	DESIGNED BY	ARCHITECT	SHEET NO.
FEB 8 1917	SAUBMAN & HOSAC	SAINT CLOUD, MINN.	M8
REVISIONS	APPROVED BY	CONSULTING ARCHITECTS & ENGINEERS	CONTRACT NO.
			338
DRAWN BY	APPROVED BY	PRES. OF STATE TEACHERS COLLEGE	